


NOTE:
 ALL CONDUITS/CIRCUITRY SHALL BE
 CONCEALED IN THE CONCRETE SLABS,
 BEHIND WALLS, OR IN CHASES.


architects inc.
 Montgomery, Alabama

GENERAL NOTES:

1. ELECTRICAL CONTRACTOR RESPONSIBLE FOR ALL RACEWAY FOR SECURITY CAMERAS. PROVIDE SINGLE GANG JUNCTION BOXES AND 3/4" CONDUIT FROM EACH CAMERA TO THE EXISTING IDF. COORDINATE ALL LOCATIONS AND MOUNTING HEIGHT ROUGH-IN WITH SECURITY CONTRACTOR PRIOR TO INSTALLATION.
2. COORDINATE ALL LOCATIONS AND CONDUIT REQUIREMENTS WITH ARCHITECTURAL SECURITY SHEETS PRIOR TO BIDS. PROVIDE CONDUIT TO ADDITIONAL SECURITY DEVICES SHOWN ON ARCHITECTURAL SECURITY PLANS THAT ARE NOT SHOWN ON THE E-SHEETS.

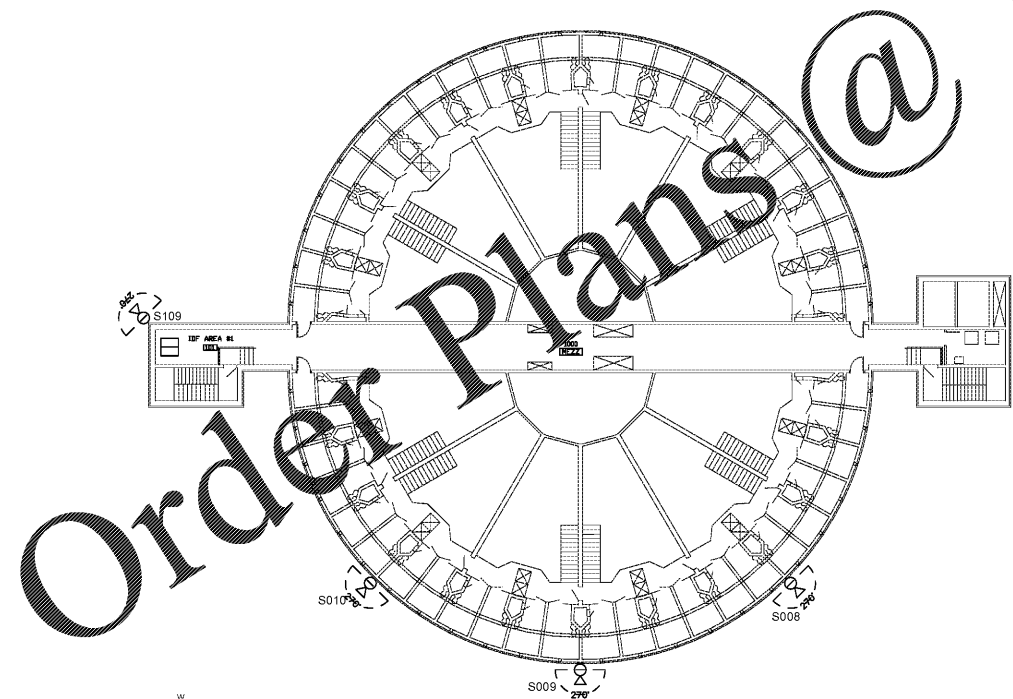

1
 E5.6 BUILDING 1000 MEZZANINE PLAN - BASE BID - SECURITY
 SCALE: 1/8"=1'-0"

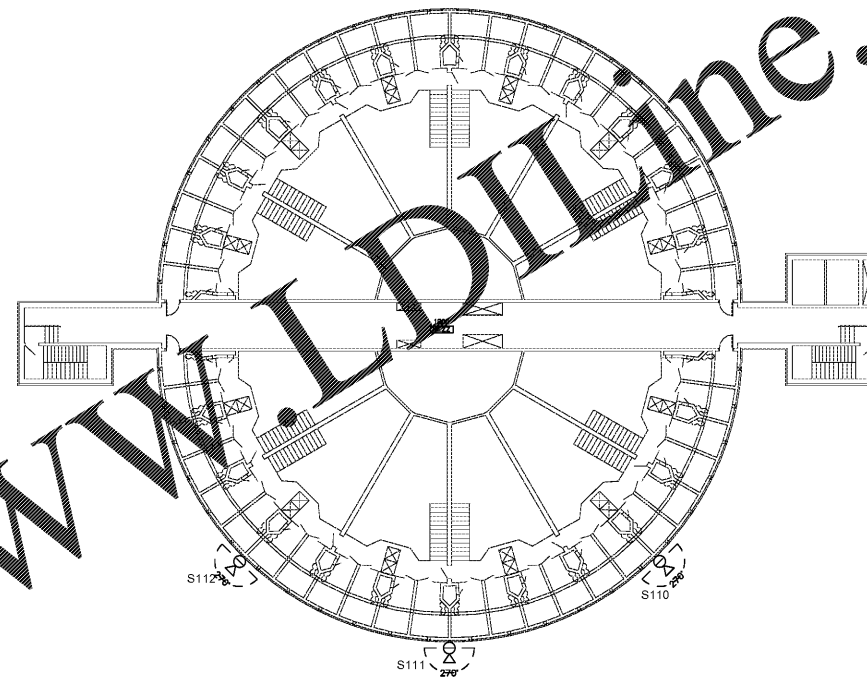

2
 E5.6 BUILDING 1200 MEZZANINE PLAN - ALTERNATE - SECURITY
 SCALE: 1/8"=1'-0"


Order Plans @ WWW.PHJARCHITECTS.COM

CIP-2017-001
 UPGRADES TO THE MOBILE COUNTY METRO JAIL
 For The MOBILE COUNTY COMMISSION
 MOBILE, ALABAMA



DRAWN	J.C.T.	CHECK	K.A.G.
DATE	April 2, 2019 RTA		
REVISED			
REVISED			

SHEET TITLE	EXISTING BUILDINGS MEZZANINE - SECURITY
JOB NO.	PH&J 1801-GV
SEQUENCE NO.	163 OF 175

 

Gunn & Associates, P.C.
 Consulting Engineers
 3102 Highway 14
 Millbrook, AL 36054
 500 Southland Drive Suite 250
 Hoover, AL 35226
 Tel: 334.285.1273
 GAA18-192

E5.6

© PH&JARCHITECTS, INC.
 ALL RIGHTS RESERVED