


NOTE:
ALL CONDUITS/CIRCUITRY SHALL BE
CONCEALED IN THE CONCRETE SLABS.
BEHIND WALLS, OR IN CHASES.

GENERAL NOTES:

1. ELECTRICAL CONTRACTOR RESPONSIBLE FOR ALL RACEWAY FOR SECURITY CAMERAS. PROVIDE SINGLE GANG JUNCTION BOXES AND 3/4" CONDUIT FROM EACH CAMERA TO THE EXISTING IDF. COORDINATE ALL LOCATIONS AND MOUNTING HEIGHT ROUGH-IN WITH SECURITY CONTRACTOR PRIOR TO INSTALLATION.
2. COORDINATE ALL LOCATIONS AND CONDUIT REQUIREMENTS WITH ARCHITECTURAL SECURITY SHEETS PRIOR TO BIDS. PROVIDE CONDUIT TO ADDITIONAL SECURITY DEVICES SHOWN ON ARCHITECTURAL SECURITY PLANS THAT ARE NOT SHOWN ON THE E-SHEETS.

 
Order Plans @ www.LDOnline.com

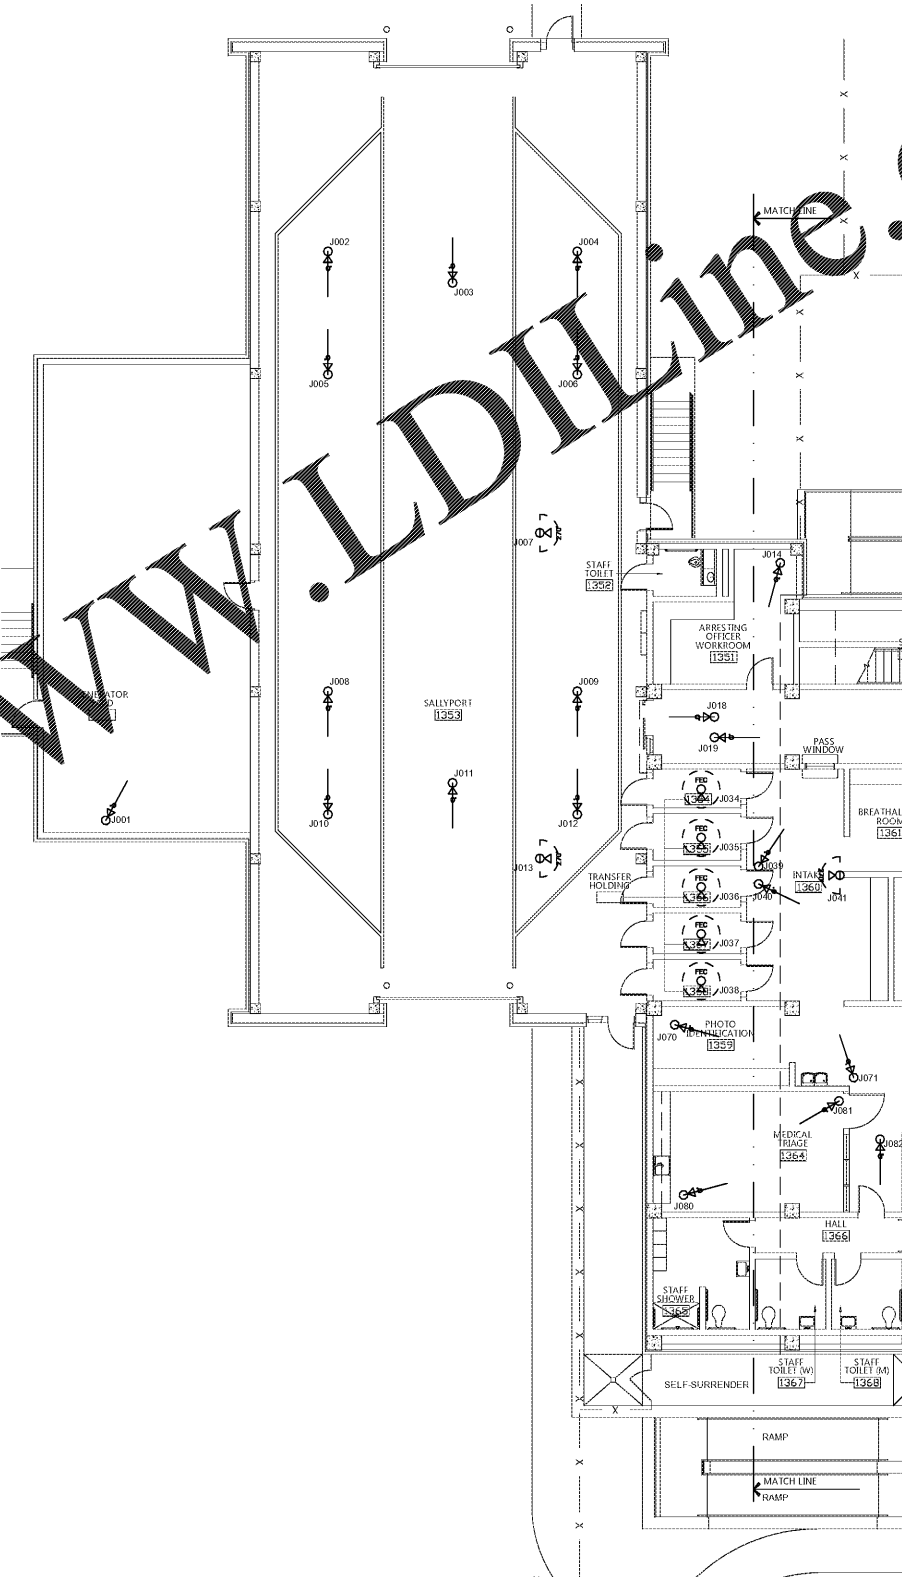

SALLY PORT

1ST FLOOR PLAN - BASE BID - SECURITY

SCALE: 1/8"=1'-0"



GA Gunn & Associates, P.C.
Consulting Engineers
3102 Highway 14
Milledgeville, AL 36864
500 Southland Drive Suite 210
Hoover, AL 35226
Tel: 334.285.1273
GAP18-192

CIP-2017-001
UPGRADES TO THE MOBILE COUNTY METRO JAIL
For The MOBILE COUNTY COMMISSION
MOBILE, ALABAMA




DRAWN: J.C.T.	CHECK: K.A.G.
DATE: April 2, 2019 RTA	
REVISED:	
REVISED:	

SHEET TITLE
SALLY PORT - 1ST FLOOR
PLAN - BASE BID -
SECURITY

CIP NO.
PH&J 1801-GV

SEQUENCE
NO. 164 OF 175

E5.7
© PH&J ARCHITECTS, INC.
ALL RIGHTS RESERVED

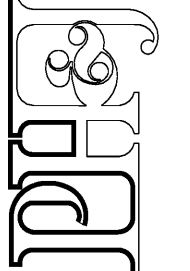

architects inc.
Montgomery,
Alabama