


GENERAL NOTES:

1. ELECTRICAL CONTRACTOR RESPONSIBLE FOR ALL RACEWAY FOR SECURITY CAMERAS. PROVIDE SINGLE GANG JUNCTION BOXES AND 3/4" CONDUIT FROM EACH CAMERA TO THE EXISTING IDF. COORDINATE ALL LOCATIONS AND MOUNTING HEIGHT ROUGH-IN WITH SECURITY CONTRACTOR PRIOR TO INSTALLATION.
2. COORDINATE ALL LOCATIONS AND CONDUIT REQUIREMENTS WITH ARCHITECTURAL SECURITY SHEETS PRIOR TO BIDS. PROVIDE CONDUIT TO ADDITIONAL SECURITY DEVICES SHOWN ON ARCHITECTURAL SECURITY PLANS THAT ARE NOT SHOWN ON THE E-SHEETS.

NOTE:
ALL CONDUITS/CIRCUITRY SHALL BE CONCEALED IN THE CONCRETE SLABS. BEHIND WALLS, OR IN CHASES.


SHEET NOTES:

- ① ROUTE CONDUIT FOR SECURITY CAMERAS TO THE IDF ON THE FIRST FLOOR.

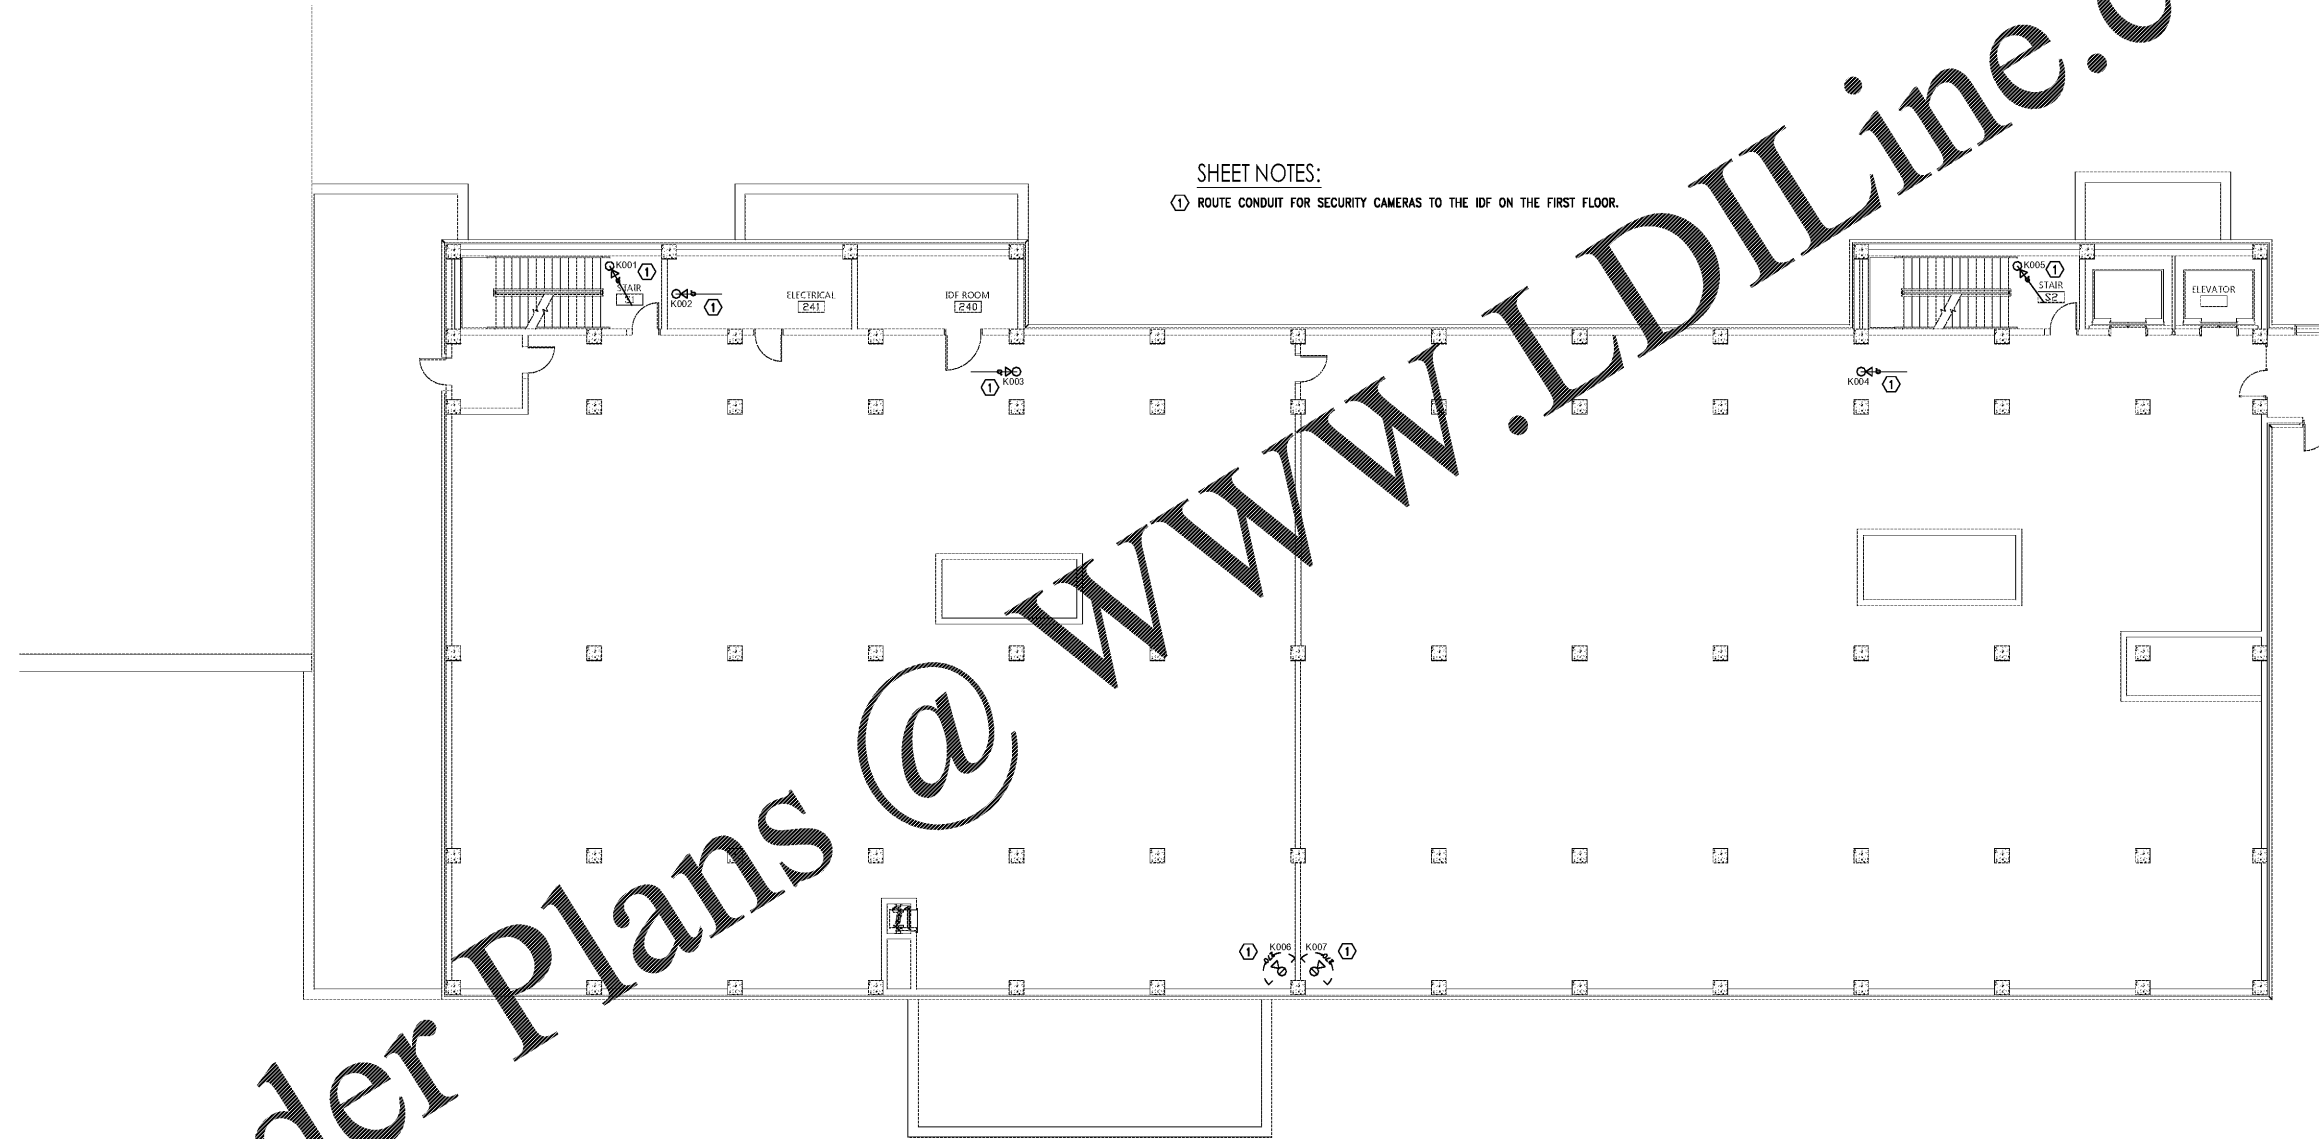

Order Plans @ www.LDILine.com

 ① 2ND FLOOR PLAN - ALTERNATE - SECURITY
SCALE: 1/8"=1'-0"



GA Gunn & Associates, P.C.
Consulting Engineers
3102 Highway 14
Montgomery, AL 36104
Tel: 334.285.1273

500 Southland Drive Suite 250
Hoover, AL 35226
GAP18-192

CIP-2017-001
UPGRADES TO THE MOBILE COUNTY METRO JAIL
For The MOBILE COUNTY COMMISSION
MOBILE, ALABAMA



DRAWN: J.C.T.	CHECK: K.A.G.
DATE: April 2, 2019 RTA	
REVISED:	
REVISED:	


SHEET TITLE
2ND FLOOR PLAN -
ALTERNATE - SECURITY

JOB NO.
PH&J 1801-GV

SEQUENCE
NO. 166 OF 175

E5.9

© PH&J ARCHITECTS, INC.
ALL RIGHTS RESERVED

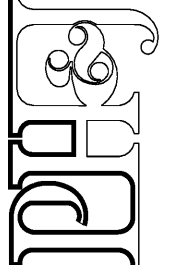

architects inc.
Montgomery, Alabama