


NOTE:
ALL CONDUITS/CIRCUITRY SHALL BE CONCEALED IN THE CONCRETE SLABS, BEHIND WALLS, OR IN CHASES.

GENERAL NOTES:

1. ELECTRICAL CONTRACTOR RESPONSIBLE FOR ALL RACEWAY FOR SECURITY CAMERAS. PROVIDE SINGLE GANG JUNCTION BOXES AND 3/4" CONDUIT FROM EACH CAMERA TO THE EXISTING IDF. COORDINATE ALL LOCATIONS AND MOUNTING HEIGHT ROUGH-IN WITH SECURITY CONTRACTOR PRIOR TO INSTALLATION.
2. COORDINATE ALL LOCATIONS AND CONDUIT REQUIREMENTS WITH ARCHITECTURAL SECURITY SHEETS PRIOR TO BIDS. PROVIDE CONDUIT TO ADDITIONAL SECURITY DEVICES SHOWN ON ARCHITECTURAL SECURITY PLANS THAT ARE NOT SHOWN ON THE E-SHEETS.

SHEET NOTES:

- ① ROUTE CONDUIT FOR SECURITY CAMERAS TO THE IDF ON THE FIRST FLOOR.

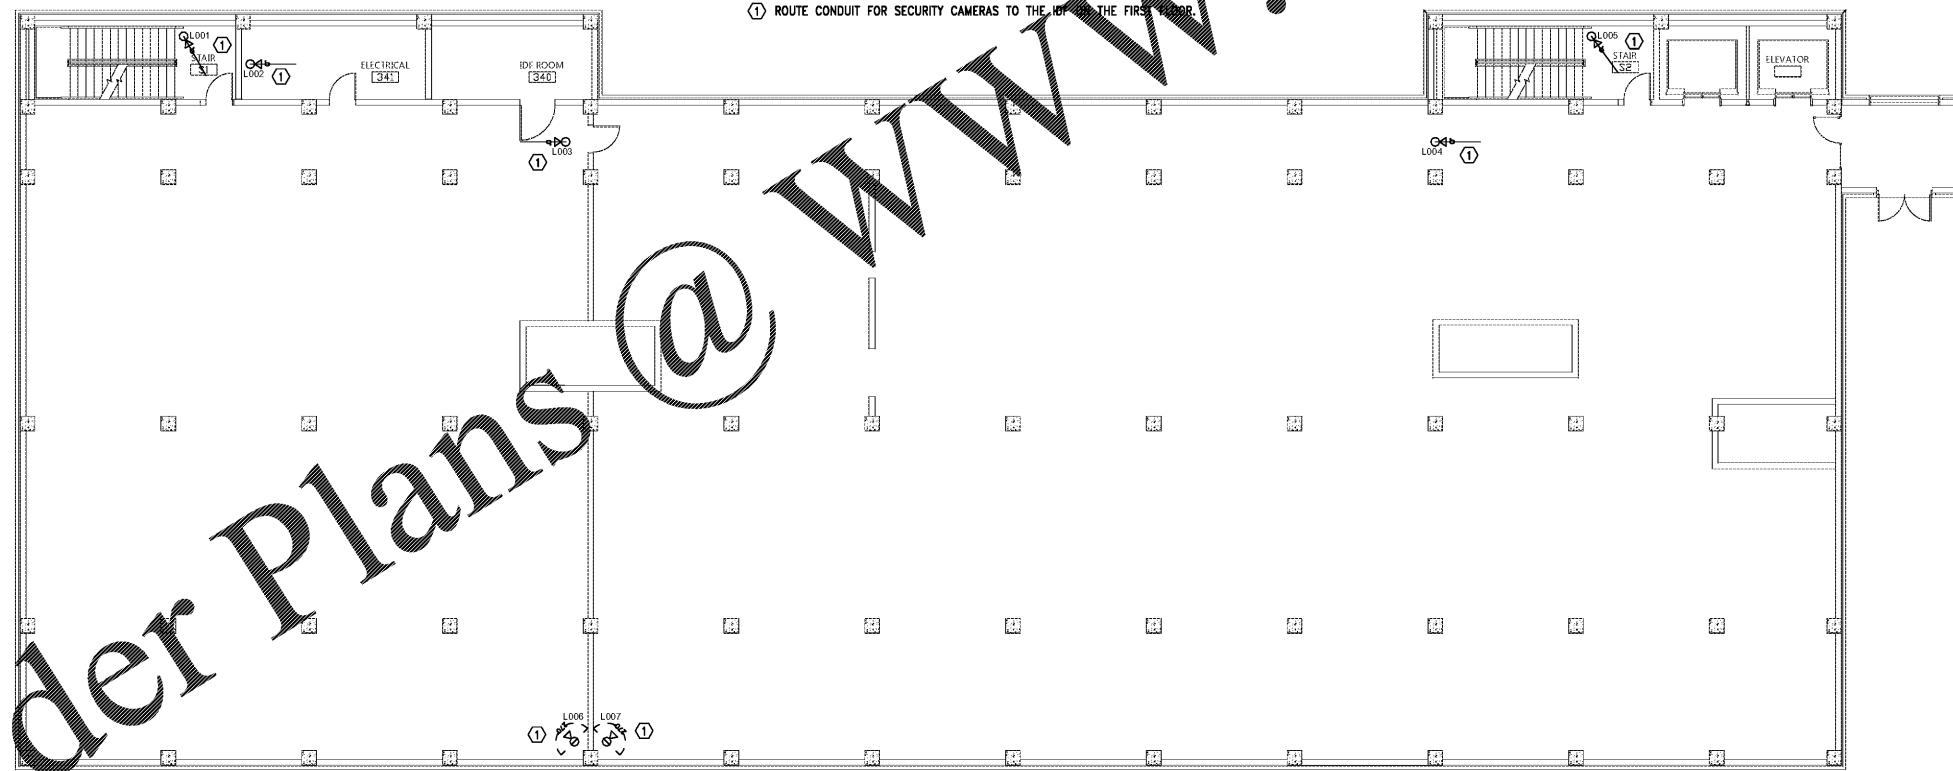

Order Plans @ WWW.LDILine.com

architects inc.
Montgomery, Alabama

CIP-2017-001
UPGRADES TO THE MOBILE COUNTY METRO JAIL
FOR THE MOBILE COUNTY COMMISSION
MOBILE, ALABAMA




DRAWN	J.C.T.	CHECK	K.A.G.
DATE	April 2, 2019 RTA		
REVISED			
REVISED			

SHEET TITLE
3RD FLOOR PLAN -
ALTERNATE - SECURITY

JOB NO.
PH&J 1801-GV

SEQUENCE
NO. 167 OF 175

 1 3RD FLOOR PLAN - ALTERNATE - SECURITY
SCALE: 1/8"=1'-0"



GA Gunn & Associates, P.C.
Consulting Engineers
3102 Highway 14
Millbrook, AL 36054
500 Southland Drive Suite 250
Hoover, AL 35226
Tel: 334.285.1273
GAP18-192

E5.10

© PH&J ARCHITECTS, INC.
ALL RIGHTS RESERVED