



WHOLE SHEET
CLOSED

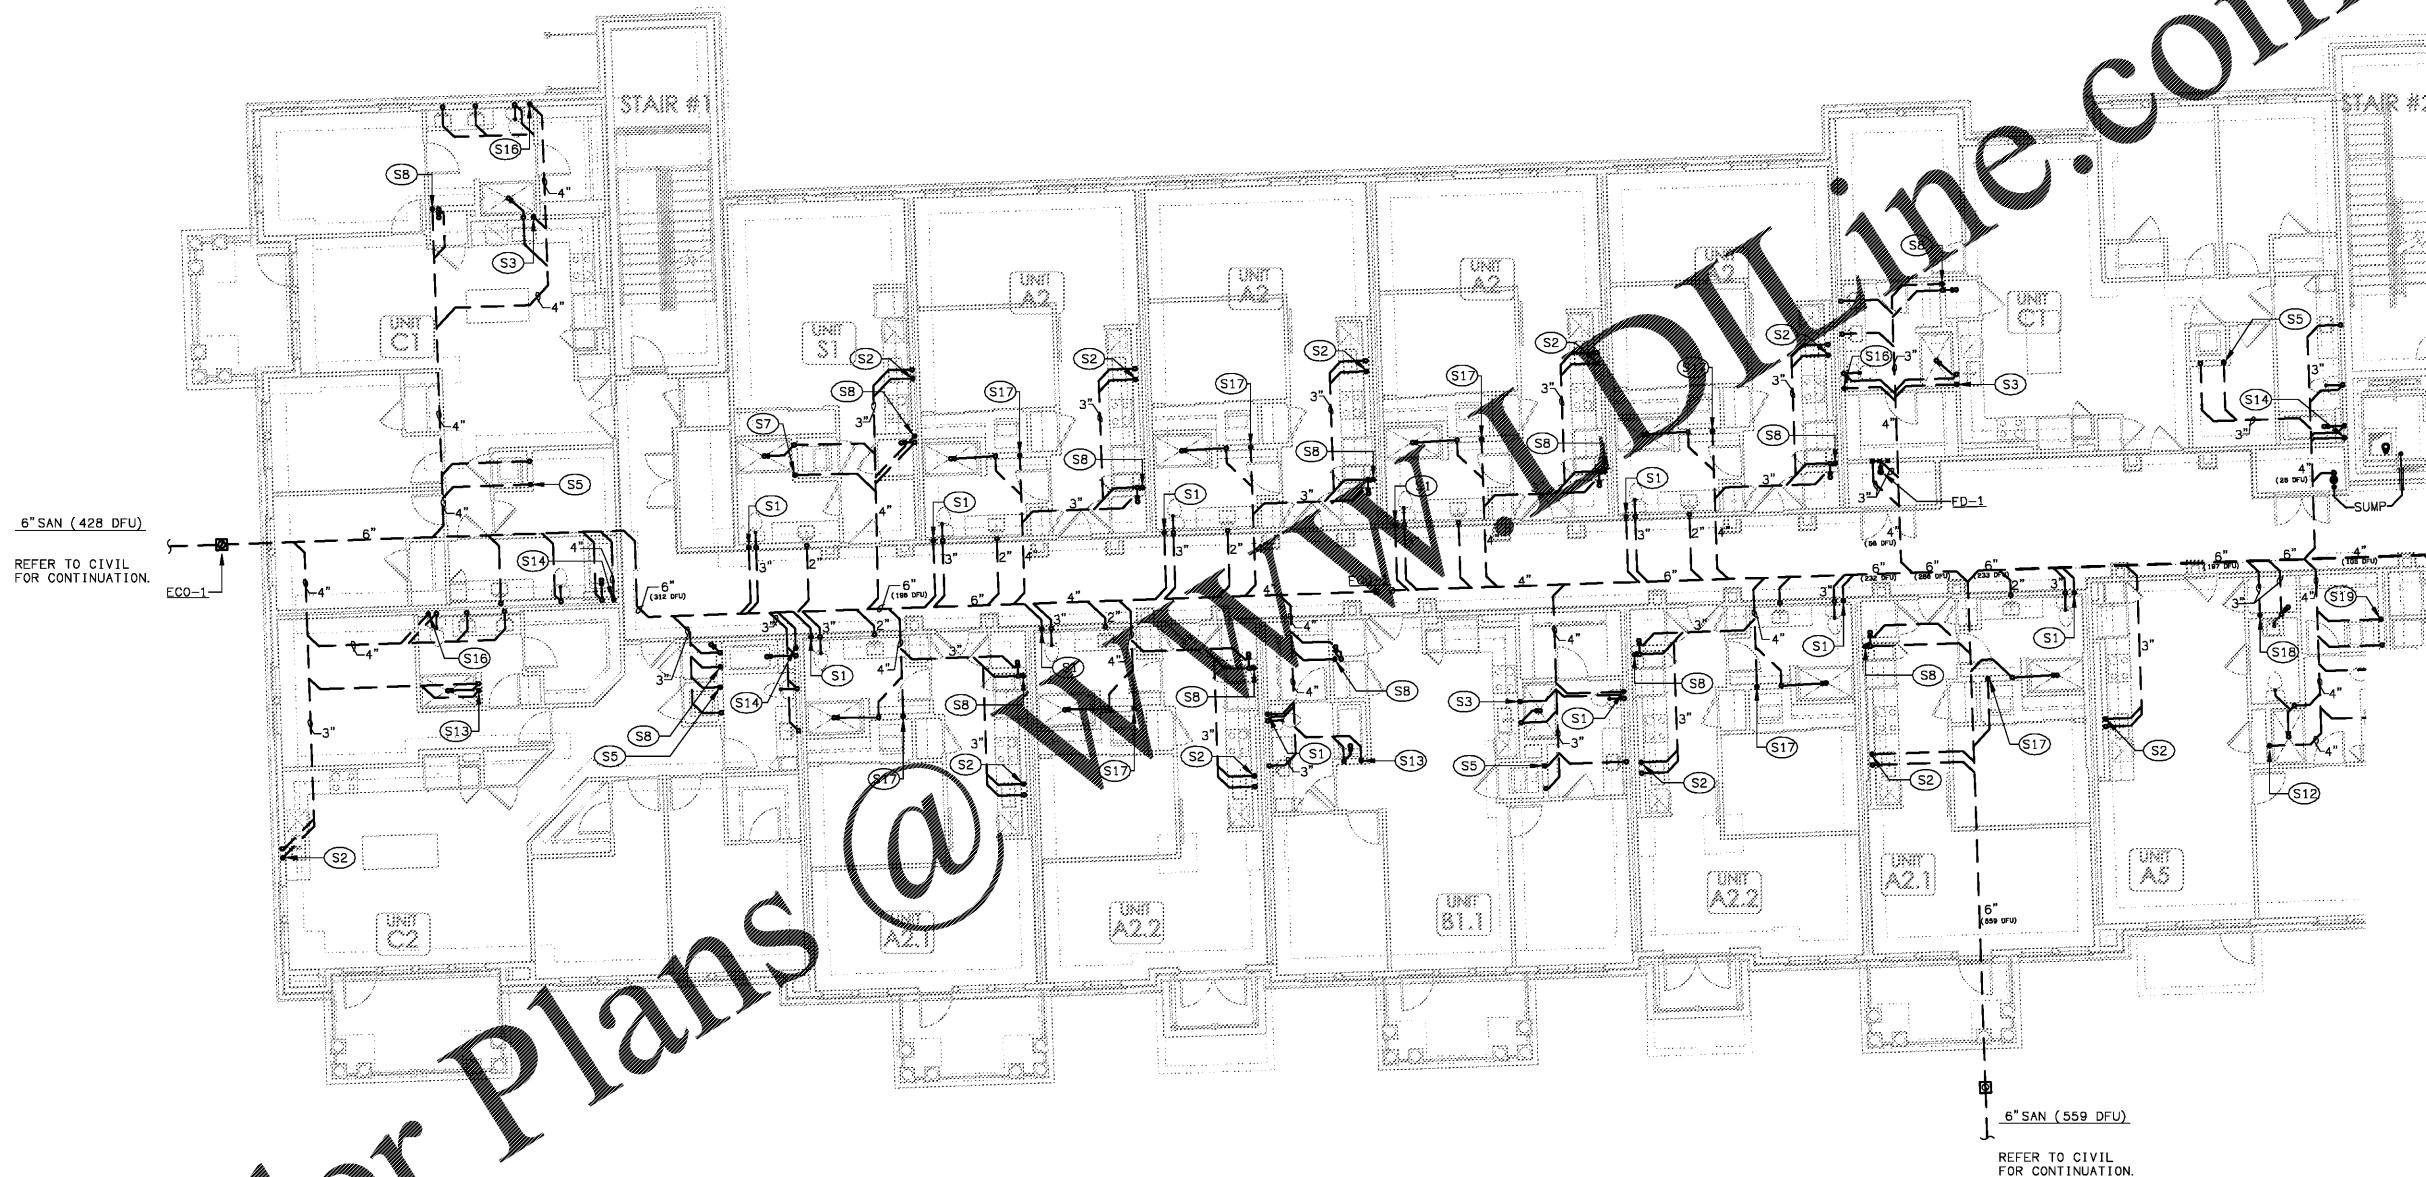


Order Plans @

WWW.Online.com

1 PARTIAL BUILDING PLAN A - (00) UNDERGROUND - PLUMBING PLAN
SCALE: 1/8" = 1'-0"

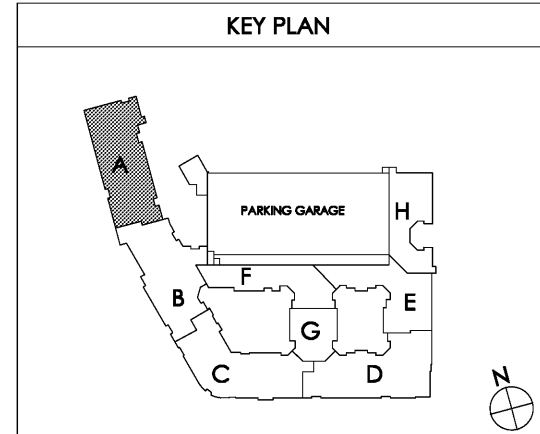

Common North, Prospect, KY

MiGre
 Engineers LLC

780 FLORIDA CENTRAL PARKWAY
 SUITE 224
 LONGWOOD, FL 32750
 PH: 407.336.7999
 PROJECT #: 18025

Lyric at Norton Commons
 Prospect, Kentucky
 Bristol Development Group
 381 Mallory Station Rd, Suite 204
 Franklin, TN 37067


charlan • brock
 associates
 architects • planners
 1770 fennell street
 maitland florida 32751-7208
 407.660.8900 • 407.875.5948
 www.cbaarchitects.com

PARTIAL BUILDING
 PLAN A - UNDERGROUND
 PLUMBING
 PLAN

date: 06-04-2019
 job no: 3789.16
 drawn by: GNIK
 reviewed by: GNIK
 file: 18025-P-BLDG
 issue history:
 07-03-2019

P0.01A

This drawing is the property of MiGre Engineers LLC. It is to be used only for the project and location specified. It is not to be reproduced, changed or copied in any form or manner whatsoever, nor are they to be employed in any field party, without first obtaining the express written permission from C.B.A., Inc. All dimensions and notes are in inches unless otherwise specified.