



Order Plans @

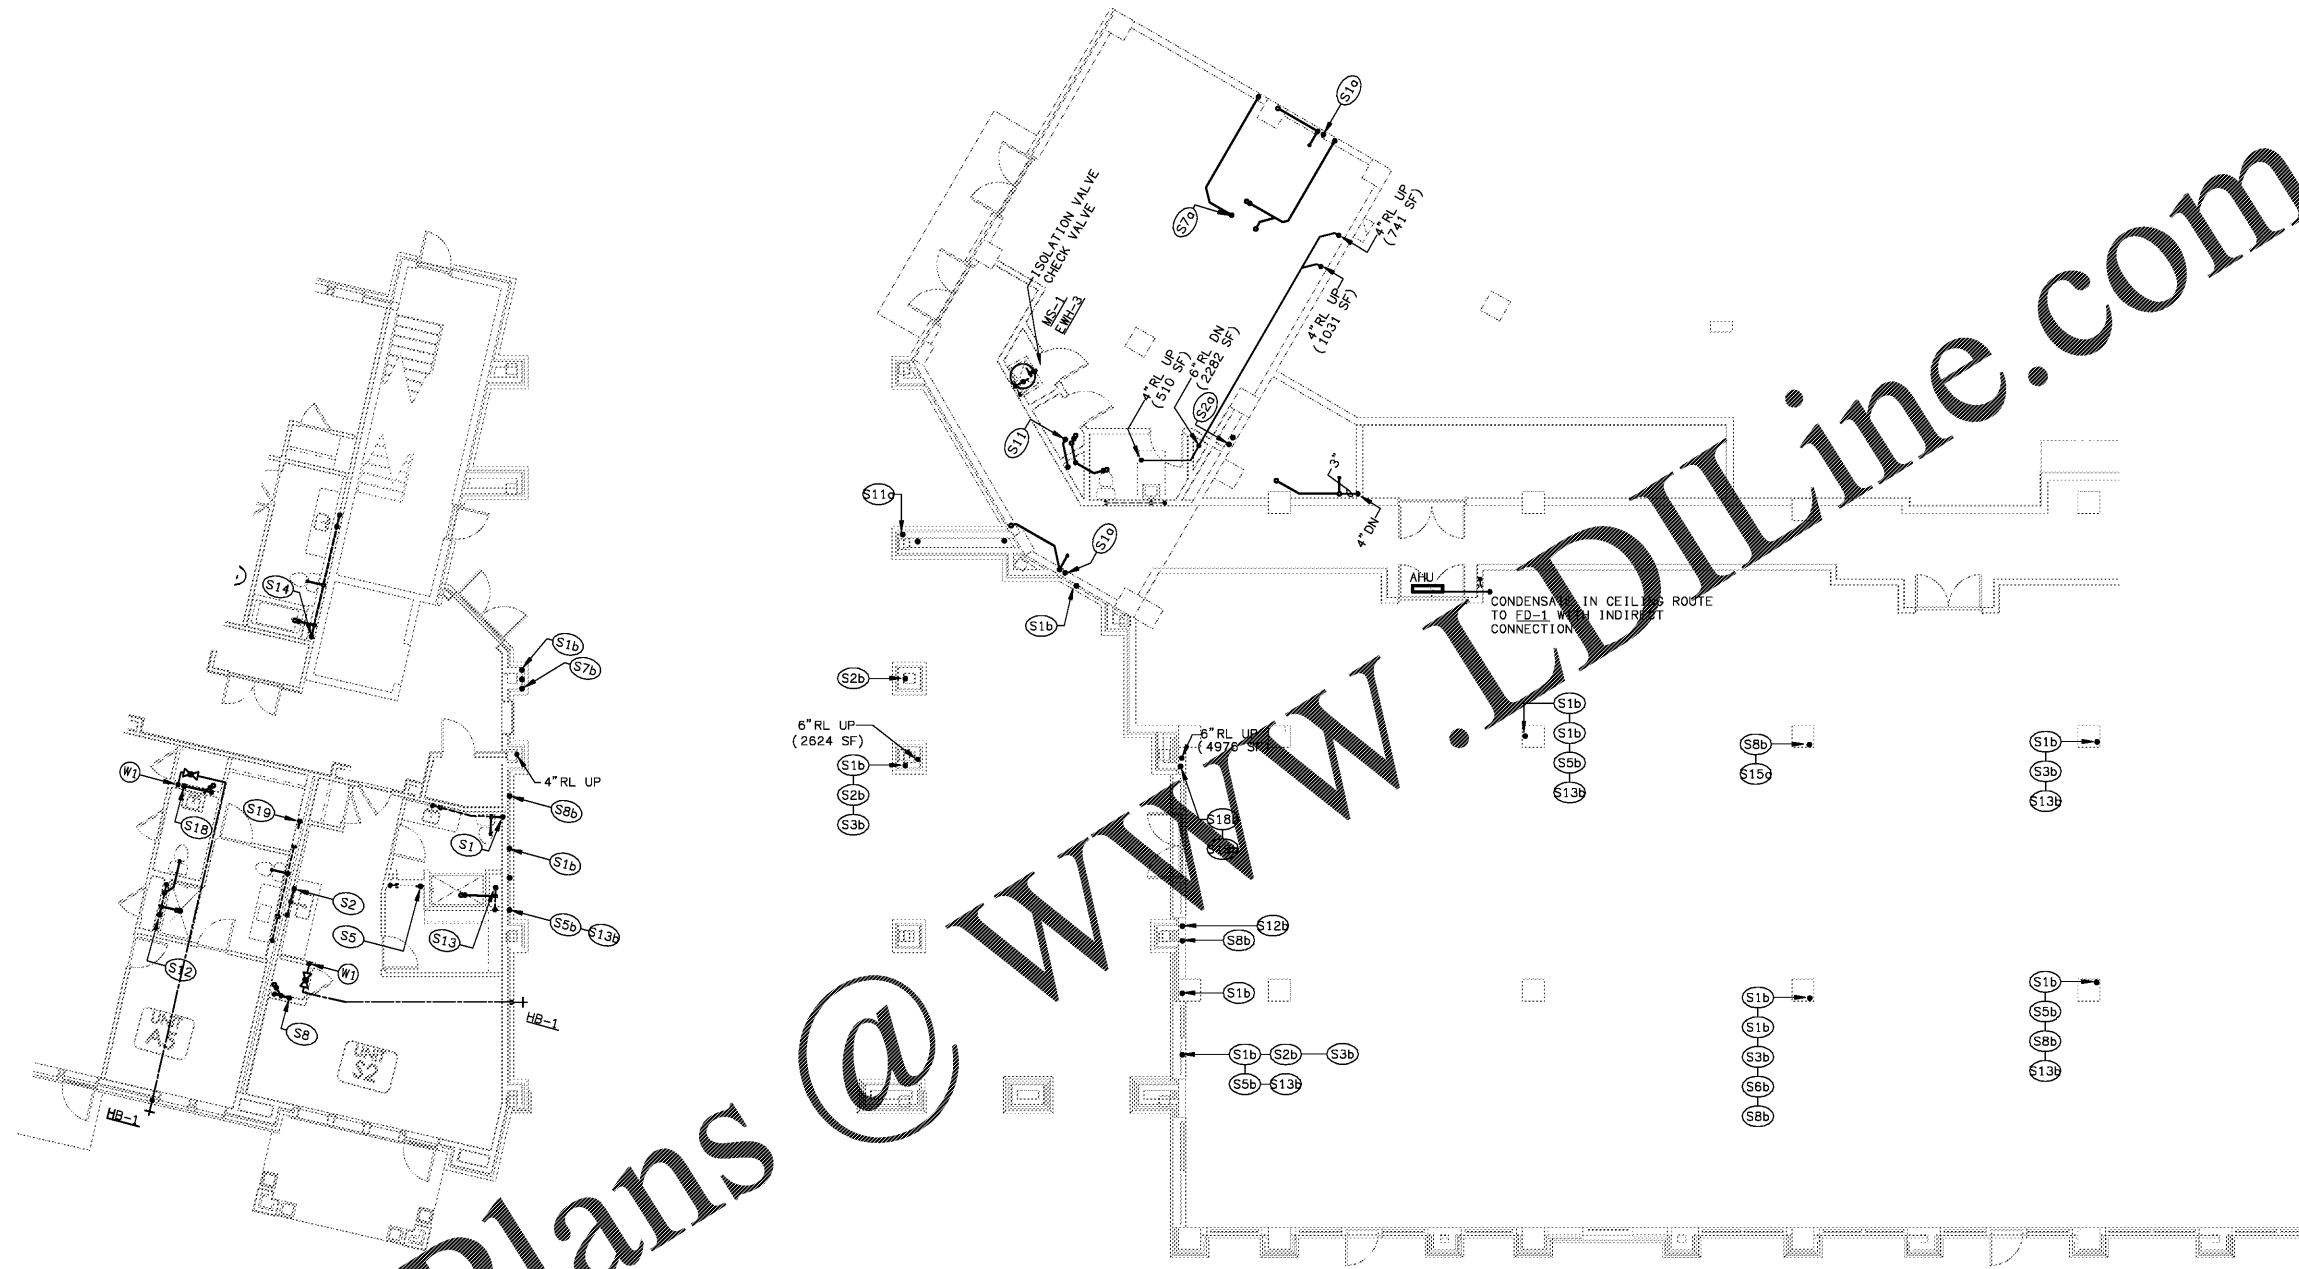

1 PARTIAL BUILDING PLAN B - (00) BASEMENT - PLUMBING PLAN  
SCALE: 1/8" = 1'-0"

18025-P-BLDG

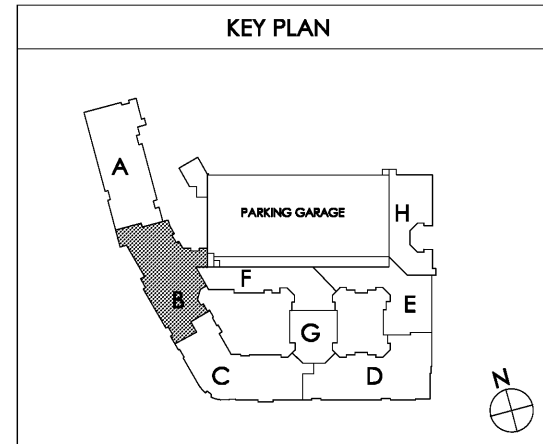


Common North, Prospect, KY



**MiGre**  
Engineers LLC

780 FLORIDA CENTRAL PARKWAY  
SUITE 224  
LONGWOOD, FL 32750  
PH: 407.336.7999  
PROJECT #: 18025

Lyric at Norton Commons  
Prospect, Kentucky

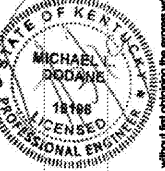

Bristol Development Group  
381 Mallory Station Rd, Suite 204  
Franklin, TN 37067

**charlan • brock**  
associates

architects • planners

1770 fennell street  
maitland florida 32751-7208  
407.660.8900 • 407.875.5948  
www.cbaarchitects.com

PARTIAL BUILDING

PLAN B - UNDERGROUND

PLUMBING

PLAN

date: 06-04-2019  
job no: 3789.16  
drawn by: GNIK  
reviewed by: GNIK  
file: 18025-P-BLDG  
issue history:

07-03-2019

P0.01B

Charlan Brock Associates, Inc. hereby reserves its copyright in these plans, specifications and other documents. All rights are reserved. No part of these plans, specifications and other documents may be reproduced, stored in a retrieval system, or transmitted in any form or by any means, electronic, mechanical, photocopying, recording, or by any information storage and retrieval system, without the prior written permission of Charlan Brock Associates, Inc. All dimensions and notes are in feet and inches unless otherwise specified.