



18025-P-BLDG - PLUMBING PLAN C - (00) UNDERGROUND - PLUMBING PLAN

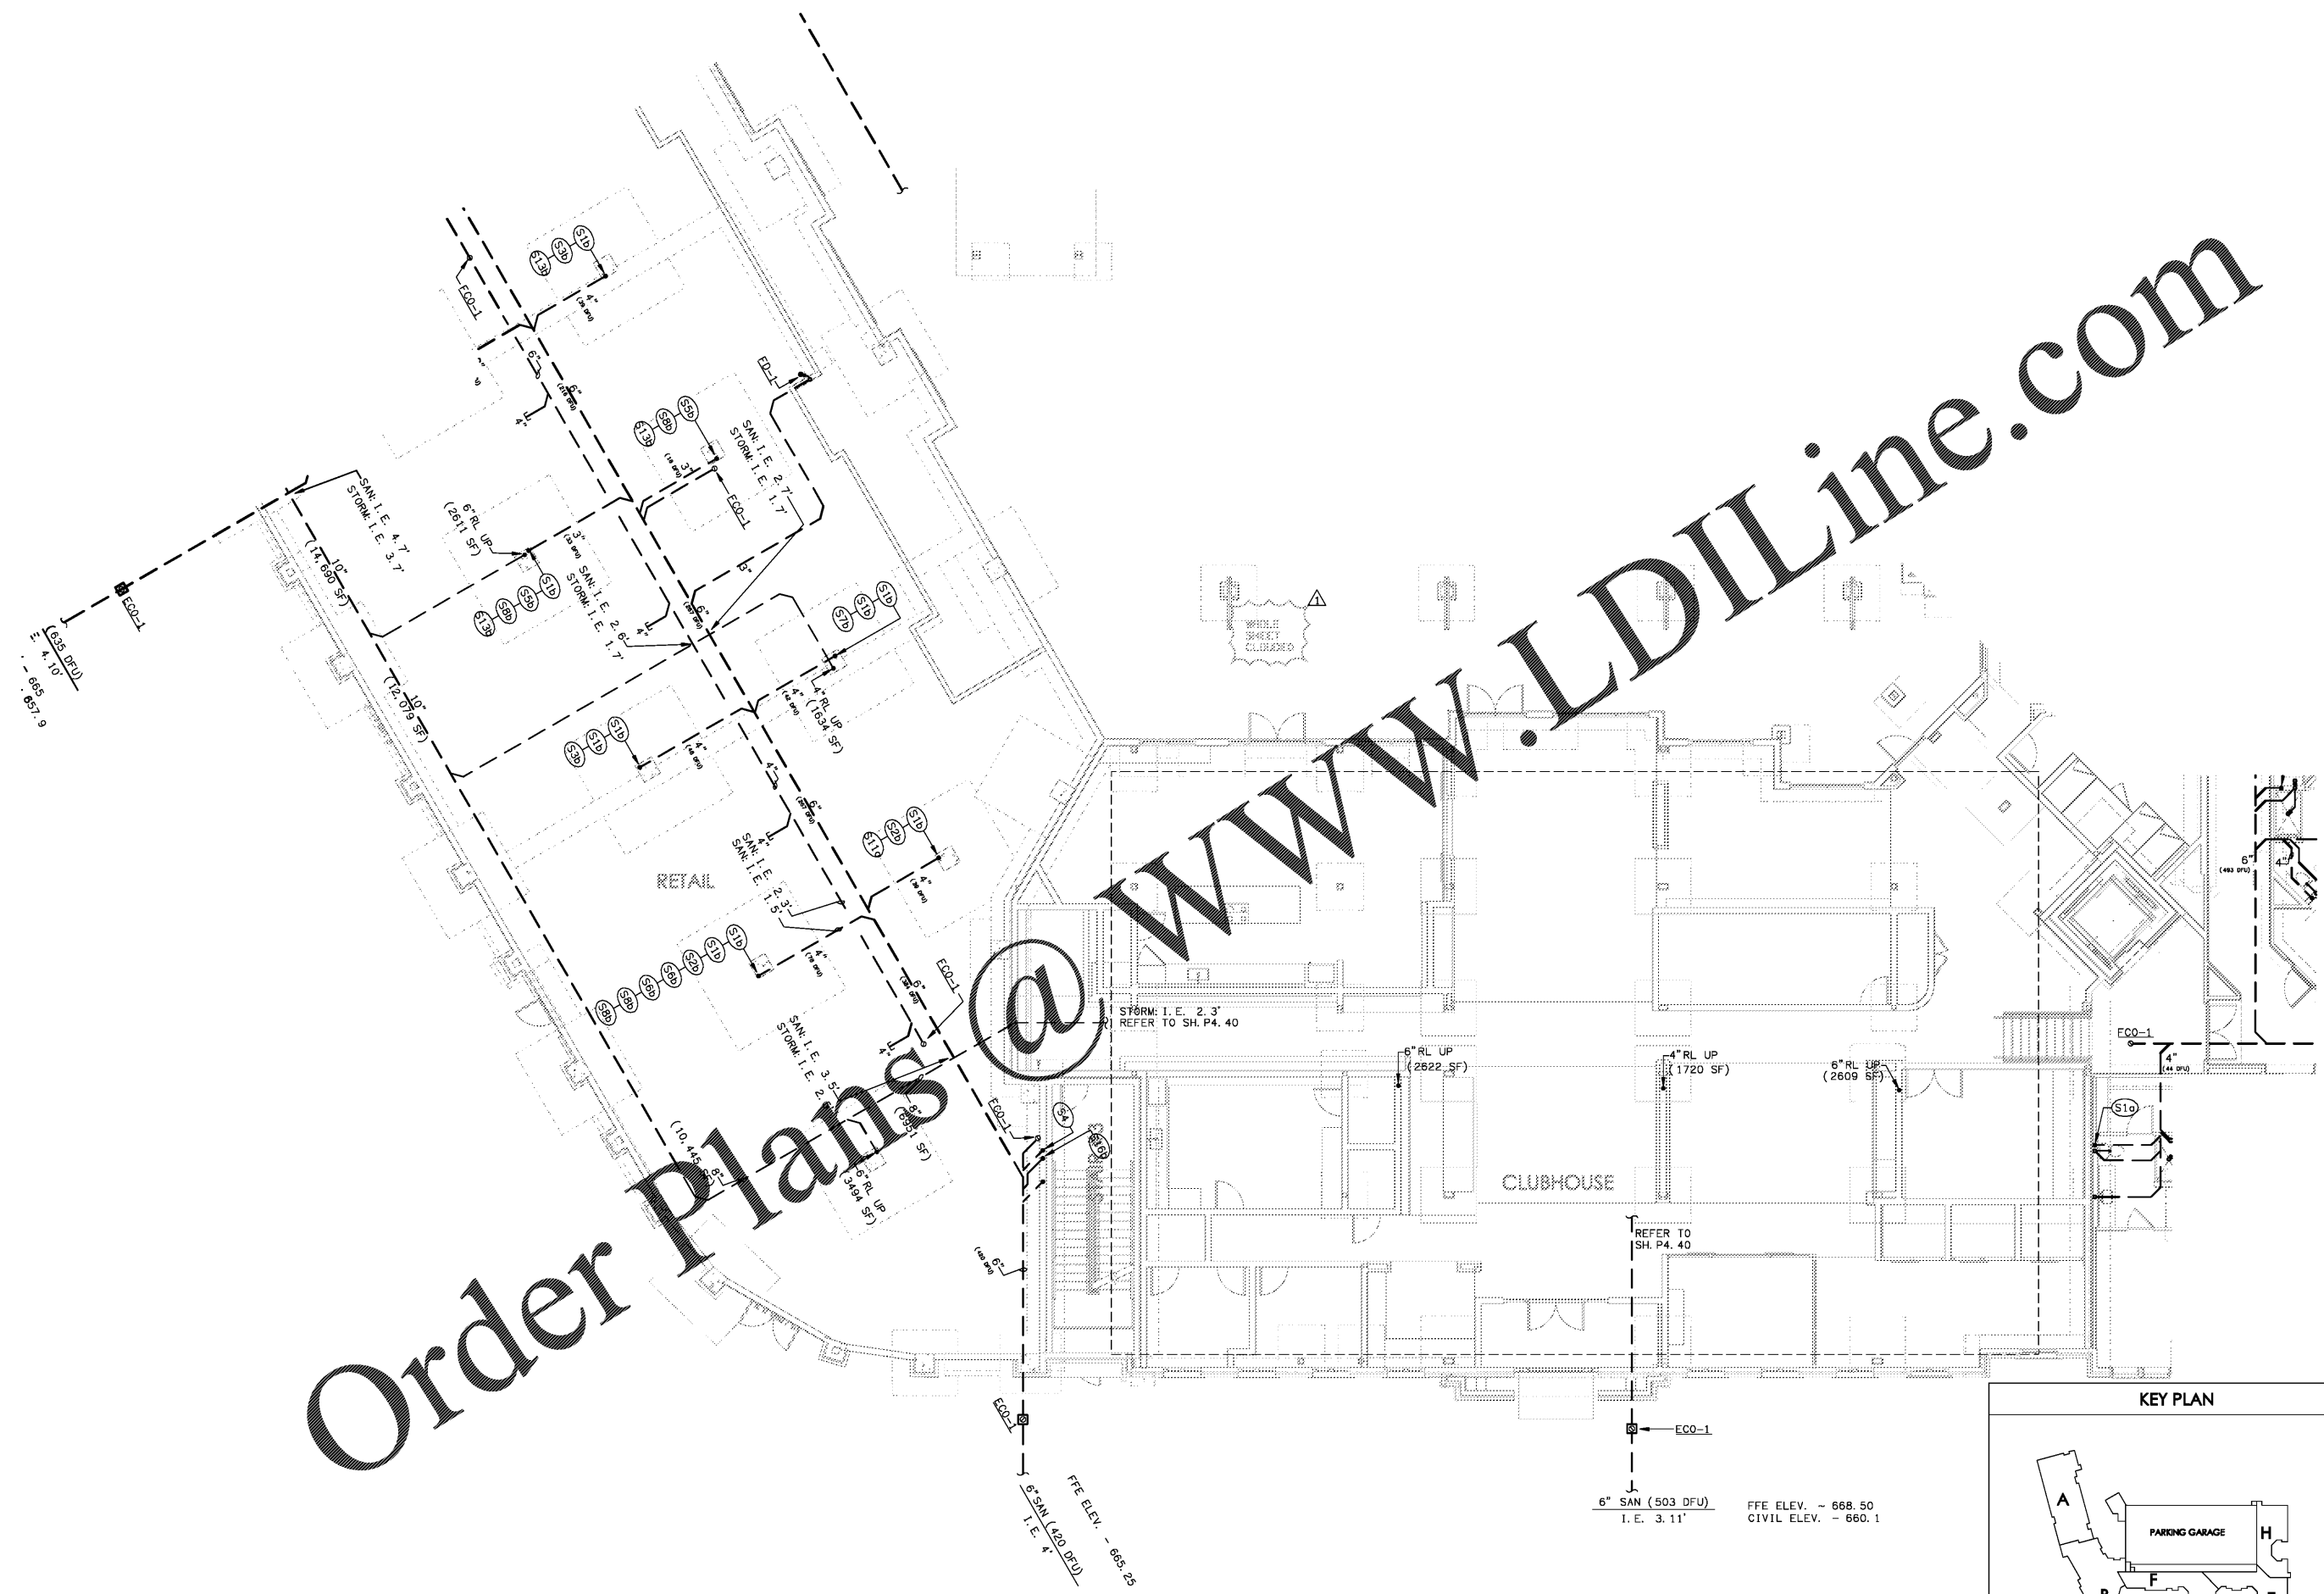

WWW.LDILine.com

Order Plans @

**1 PARTIAL BUILDING PLAN C - (00) UNDERGROUND - PLUMBING PLAN**  
 SCALE: 1/8" = 1'-0"  
 18025-P-BLDG

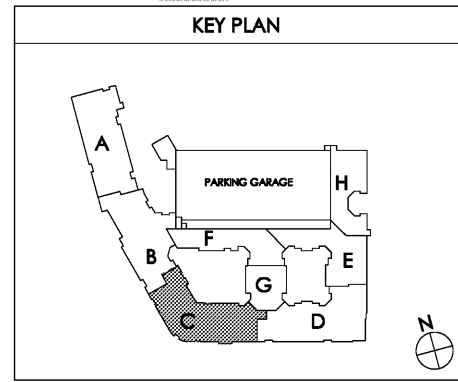


Common North, Prospect, KY



**MiGre**  
 Engineers LLC

780 FLORIDA CENTRAL PARKWAY  
 SUITE 224  
 LONGWOOD, FL 32750  
 PH: 407.336.7999  
 PROJECT #: 18025

Lyric at Norton Commons  
 Prospect, Kentucky

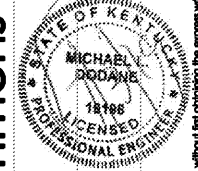

Bristol Development Group  
 381 Malloy Station Rd, Suite 204  
 Franklin, TN 37067

**charlan • brock**  
 associates

architects • planners  
 1770 fennell street  
 maitland florida 32751-7208  
 407.660.8900 • 407.875.5948  
 www.cbaarchitects.com

**PARTIAL BUILDING**  
**PLAN C - UNDERGROUND**  
**PLUMBING**  
**PLAN**

date: 06-04-2019  
 job no: 3789.16  
 drawn by: GNIK  
 reviewed by: GNIK  
 file: 18025-P-BLDG  
 issue history:  
 07-03-2019

**P0.01C**

charlan, brock & associates, inc. hereby reserves its copyright in these plans, specifications and details. These plans, specifications and details are not to be reproduced, changed or copied in any form or manner whatsoever, nor are they to be employed in any filed party, without first obtaining the express written permission from charlan, brock & associates, inc. written dimensions and note precedences over icons dimensions.  
 MICHAEL SODANE  
 18198  
 LICENSED  
 PROFESSIONAL ENGINEER  
 STATE OF KENTUCKY