



Order Plans @ WWW.IDLine.com

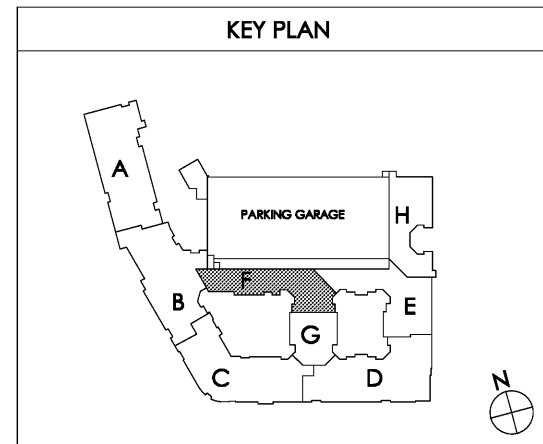

1 PARTIAL BUILDING PLAN F - (00) UNDERGROUND - PLUMBING PLAN
 SCALE: 1/8" = 1'-0"
 18025-P-BLDG

Common North, Prospect, KY
 MiGre Engineers LLC
 780 FLORIDA CENTRAL PARKWAY SUITE 224
 LONGWOOD, FL 32750
 PH: 407.336.7999
 PROJECT #: 18025

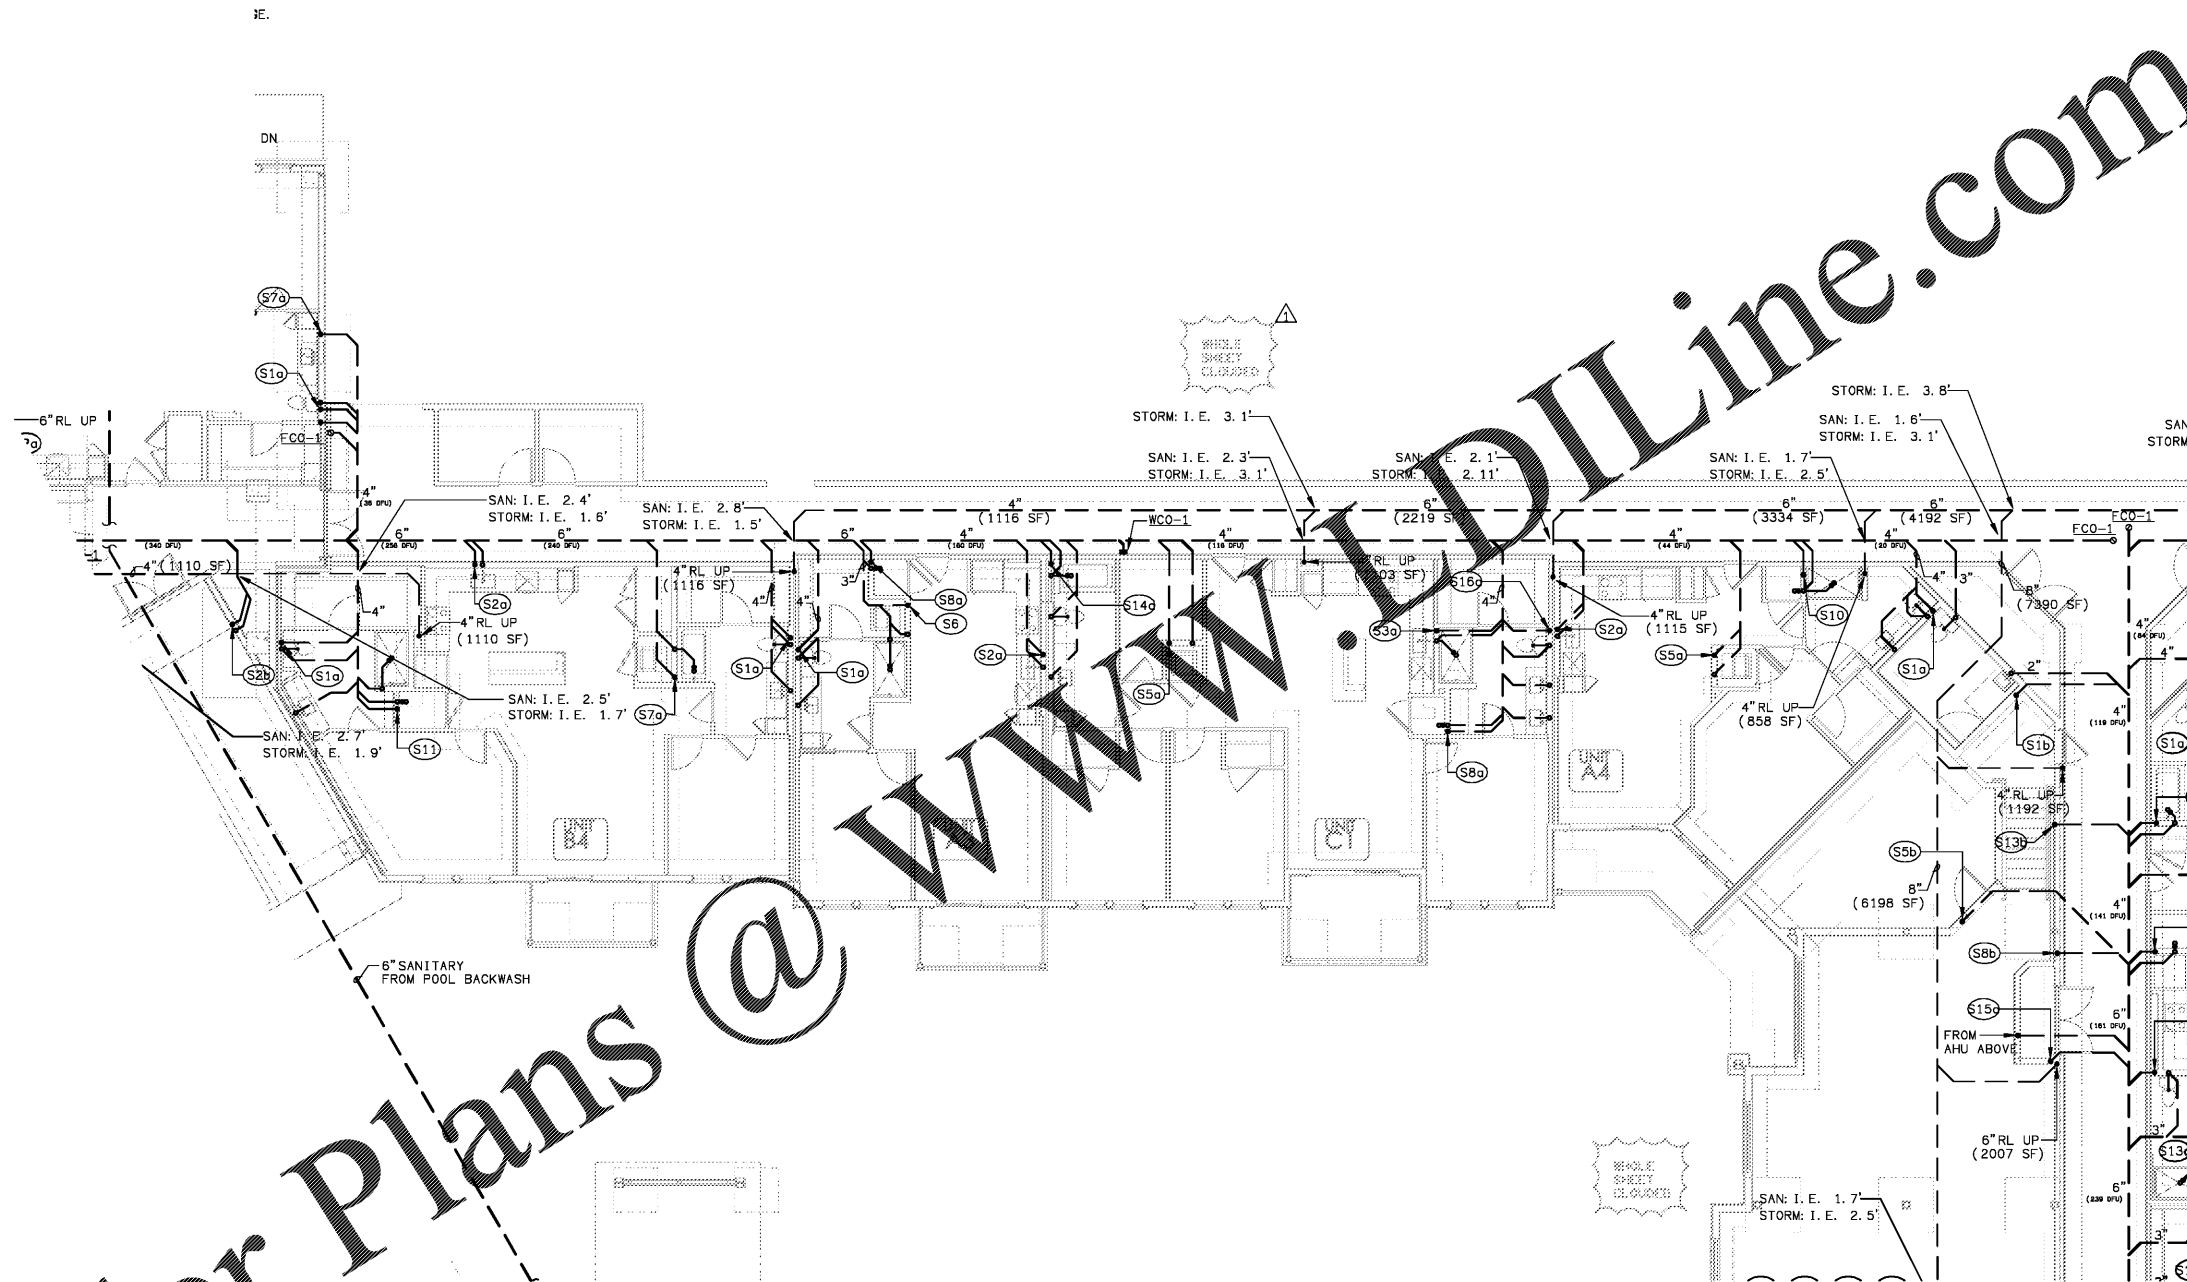

Lyric at Norton Commons
 Prospect, Kentucky
 Bristol Development Group
 381 Malloy Station Rd, Suite 204
 Franklin, TN 37067

charlan • brock associates
 architects • planners
 1770 fennell street
 maitland florida 32751-7208
 407.660.8900 • 407.875.5948
 www.cbaarchitects.com

PARTIAL BUILDING
 PLAN F - UNDERGROUND
 PLUMBING
 PLAN

date: 06-04-2019
 job no: 3789.16
 drawn by: GNIK
 reviewed by: GNIK
 file: 18025-P-BLDG
 issue history:
 07-03-2019

P0.01F

charlan • brock associates, Inc. hereby reserves its copyright in these plans, specifications and other documents. These plans, specifications and other documents are not to be reproduced, changed or copied in any form or manner whatsoever, nor are they to be assigned to any third party, without first obtaining the express written permission from C.B.A., Inc. All dimensions and notes precedence over scale dimensions.