



Order Plans @ WWW.DLine.com

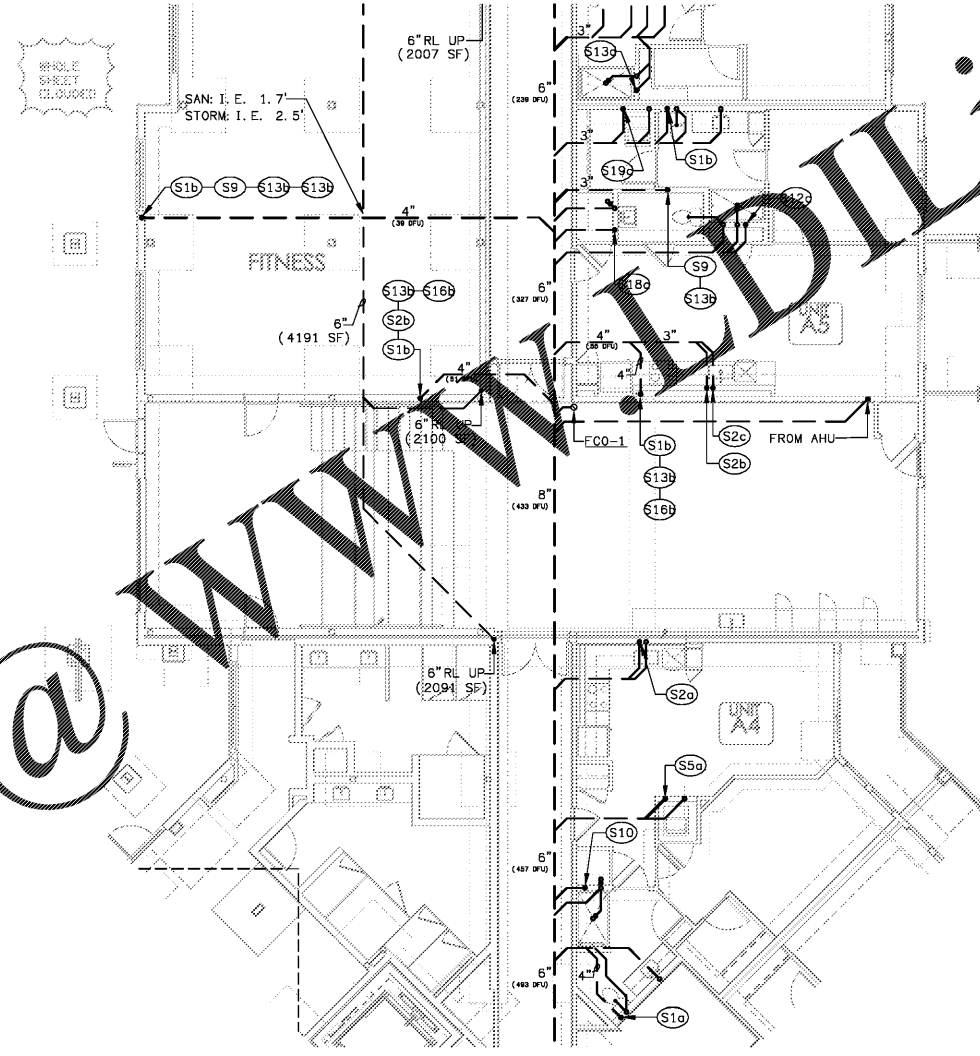


**1 PARTIAL BUILDING PLAN G - (00) UNDERGROUND - PLUMBING PLAN**  
 SCALE: 1/8" = 1'-0"

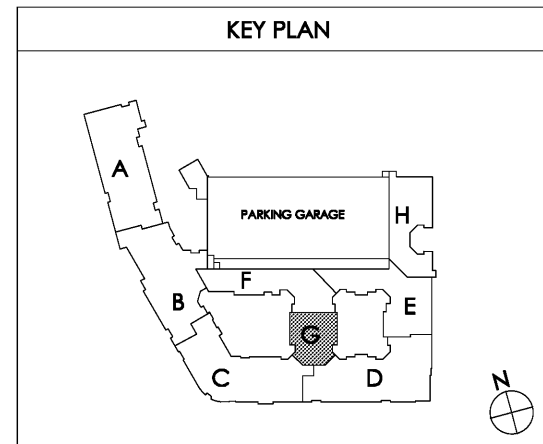

Common North, Prospect, KY  
 KY  
 KY

**MiGre**  
 Engineers LLC

780 FLORIDA CENTRAL PARKWAY  
 SUITE 224  
 LONGWOOD, FL 32750  
 PH: 407.336.7999  
 PROJECT #: 18025

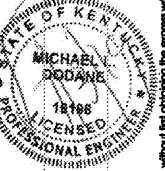

Lyric at Norton Commons  
 Prospect, Kentucky

Bristol Development Group  
 381 Malloy Station Rd, Suite 204  
 Franklin, TN 37067

**charlan • brock**  
 associates

architects • planners  
 1770 fennell street  
 maitland florida 32751-7208  
 407.660.8900 • 407.875.5948  
 www.cbaarchitects.com

PARTIAL BUILDING  
 PLAN G - UNDERGROUND  
 PLUMBING  
 PLAN

date: 06-04-2019  
 job no: 3789.16  
 drawn by: GNIK  
 reviewed by: GNIK  
 file: 18025-P-BLDG  
 issue history:  
 07-03-2019

P0.01G

charlan, brock & associates, inc. hereby reserves its copyright in these plans, specifications and other documents. No part of these plans, specifications and other documents may be reproduced, stored in a retrieval system, or transmitted in any form or by any means, without the prior written permission of charlan, brock & associates, inc. All dimensions and notes are in feet and inches unless otherwise indicated. The plans and specifications comply with the applicable minimum building codes and the applicable regulatory jurisdiction.