



Order Plans @ WWW.DIline.com

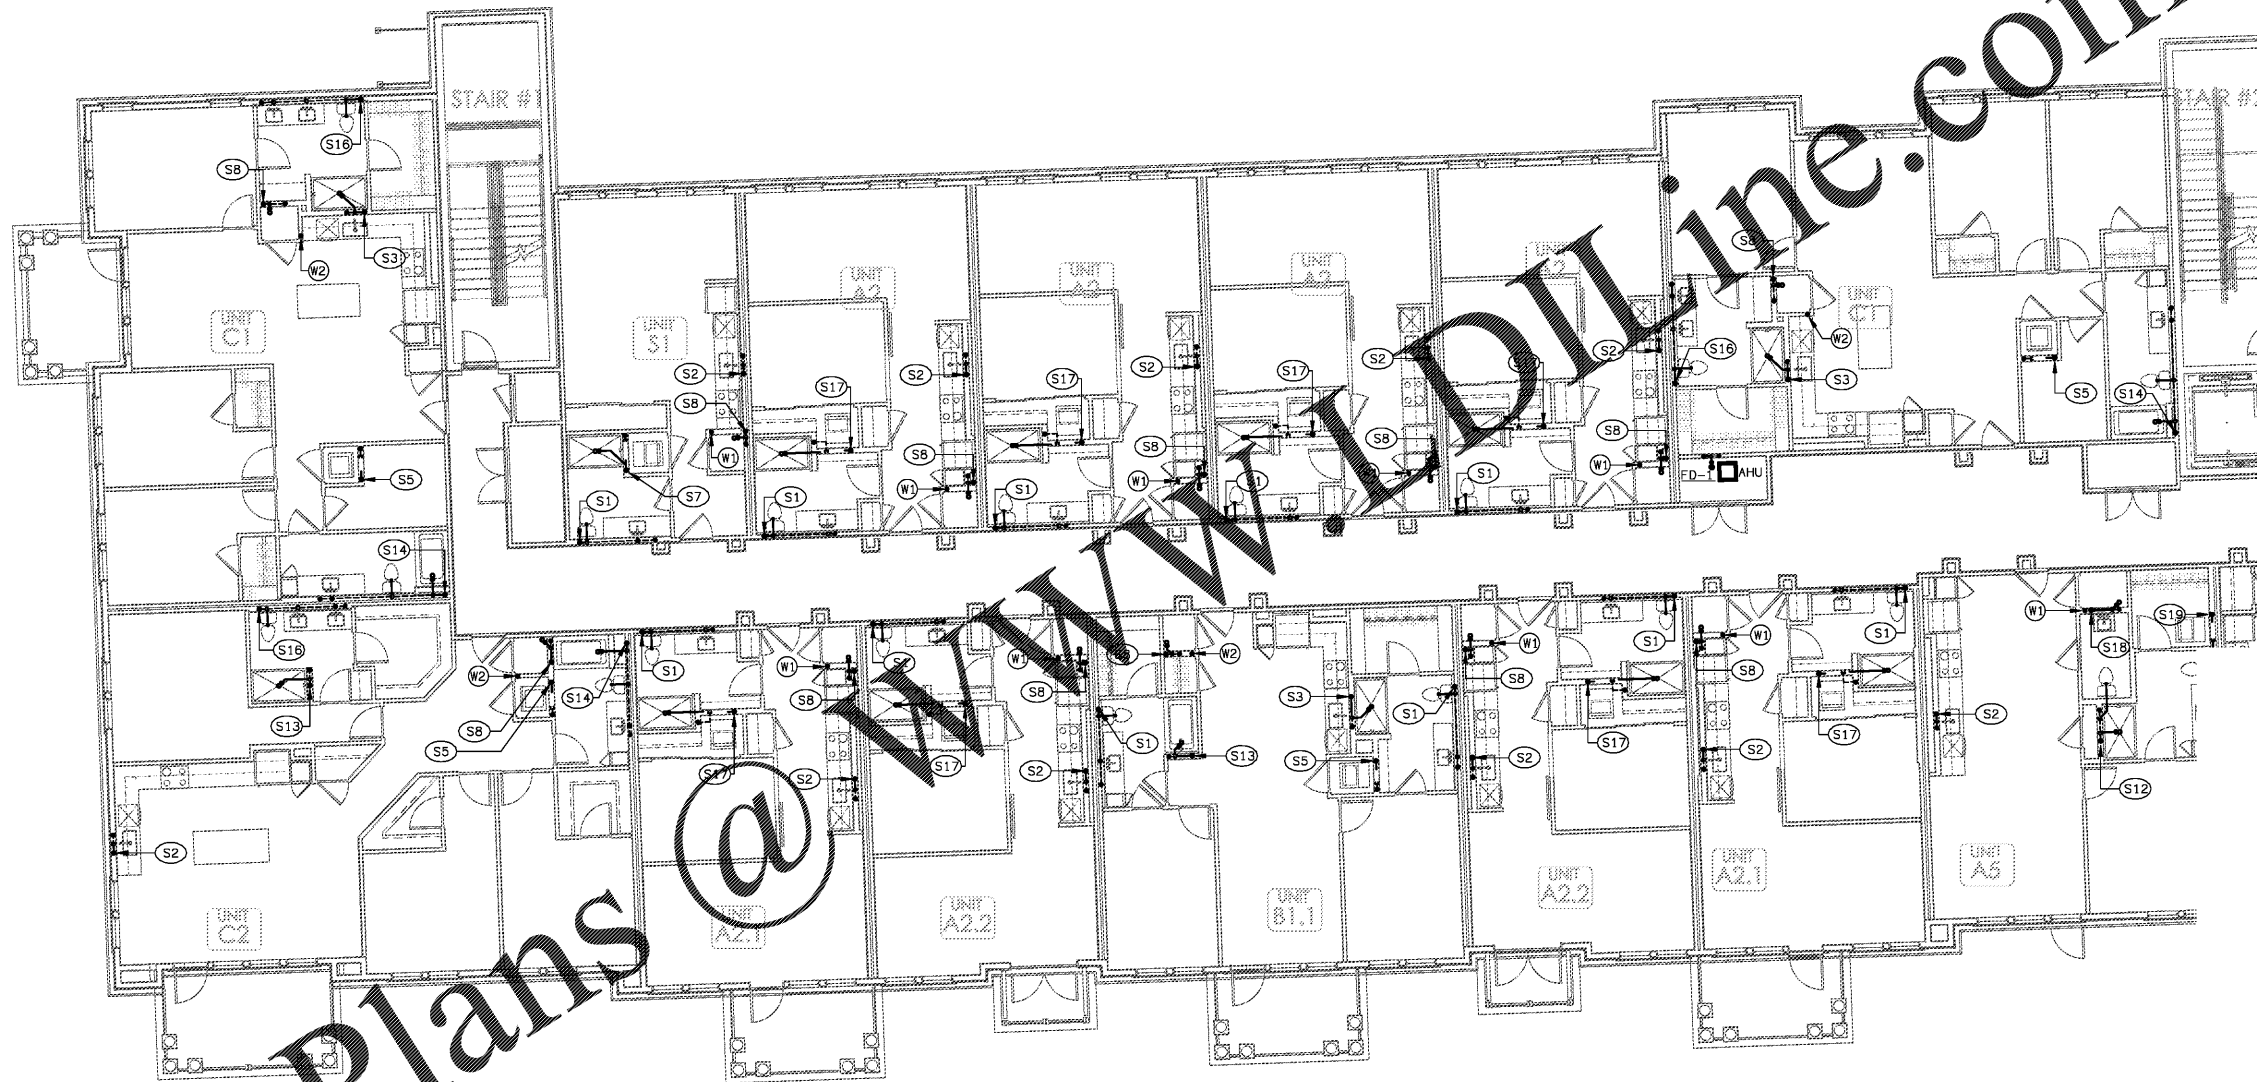


1 PARTIAL BUILDING PLAN A - (01) FIRST FLOOR - PLUMBING PLAN
SCALE: 1/8" = 1'-0"

0026-01-BLDG.CXD

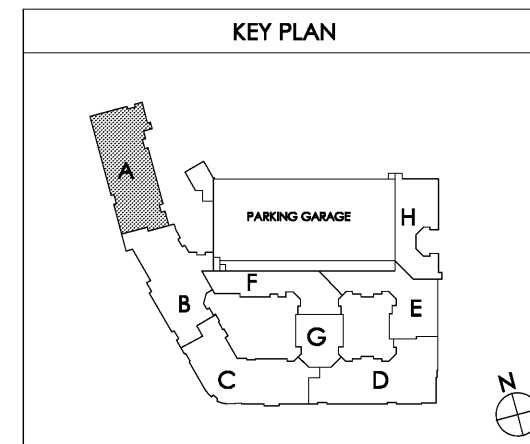

Common North, Prospect, KY
MiGre
 Engineers LLC
 780 FLORIDA CENTRAL PARKWAY
 SUITE 224
 LONGWOOD, FL 32750
 PH: 407.336.7999
 PROJECT #: 18025

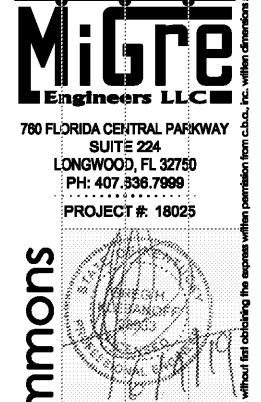

Lyric at Norton Commons
 Prospect, Kentucky

Bristol Development Group
 381 Mallory Station Rd, Suite 204
 Franklin, TN 37067

charlan • brock
 associates

architects • planners
 1770 fennell street
 maitland florida 32751-7208
 407.660.8900 • 407.875.5948
 www.cbarchitects.com

PARTIAL BUILDING
 PLAN A - 1ST FLOOR
 PLUMBING
 PLAN

date: 06-04-2019
 job no: 3789.16
 drawn by: GNIK
 reviewed by: GNIK
 file: 18025-P-BLDG
 issue history:

P1.11A

charlan • brock associates, Inc. hereby reserves all copyright, trademark, and other rights in these drawings, ideas, and designs. These drawings, ideas, and designs are not to be reproduced, changed or copied in any form or manner whatsoever, nor are they to be assigned to any third party, without first obtaining the express written permission from C.B.A., Inc. All dimensions and notes precedence over scale dimensions.

MiGre Engineers, LLC - 18025-P-BLDG-01-PLUMBING - 06-19-19 - Plotwide: 11/20/19, Issue No: 06/19/19 by Ryan Cooper