



Order Plans @

 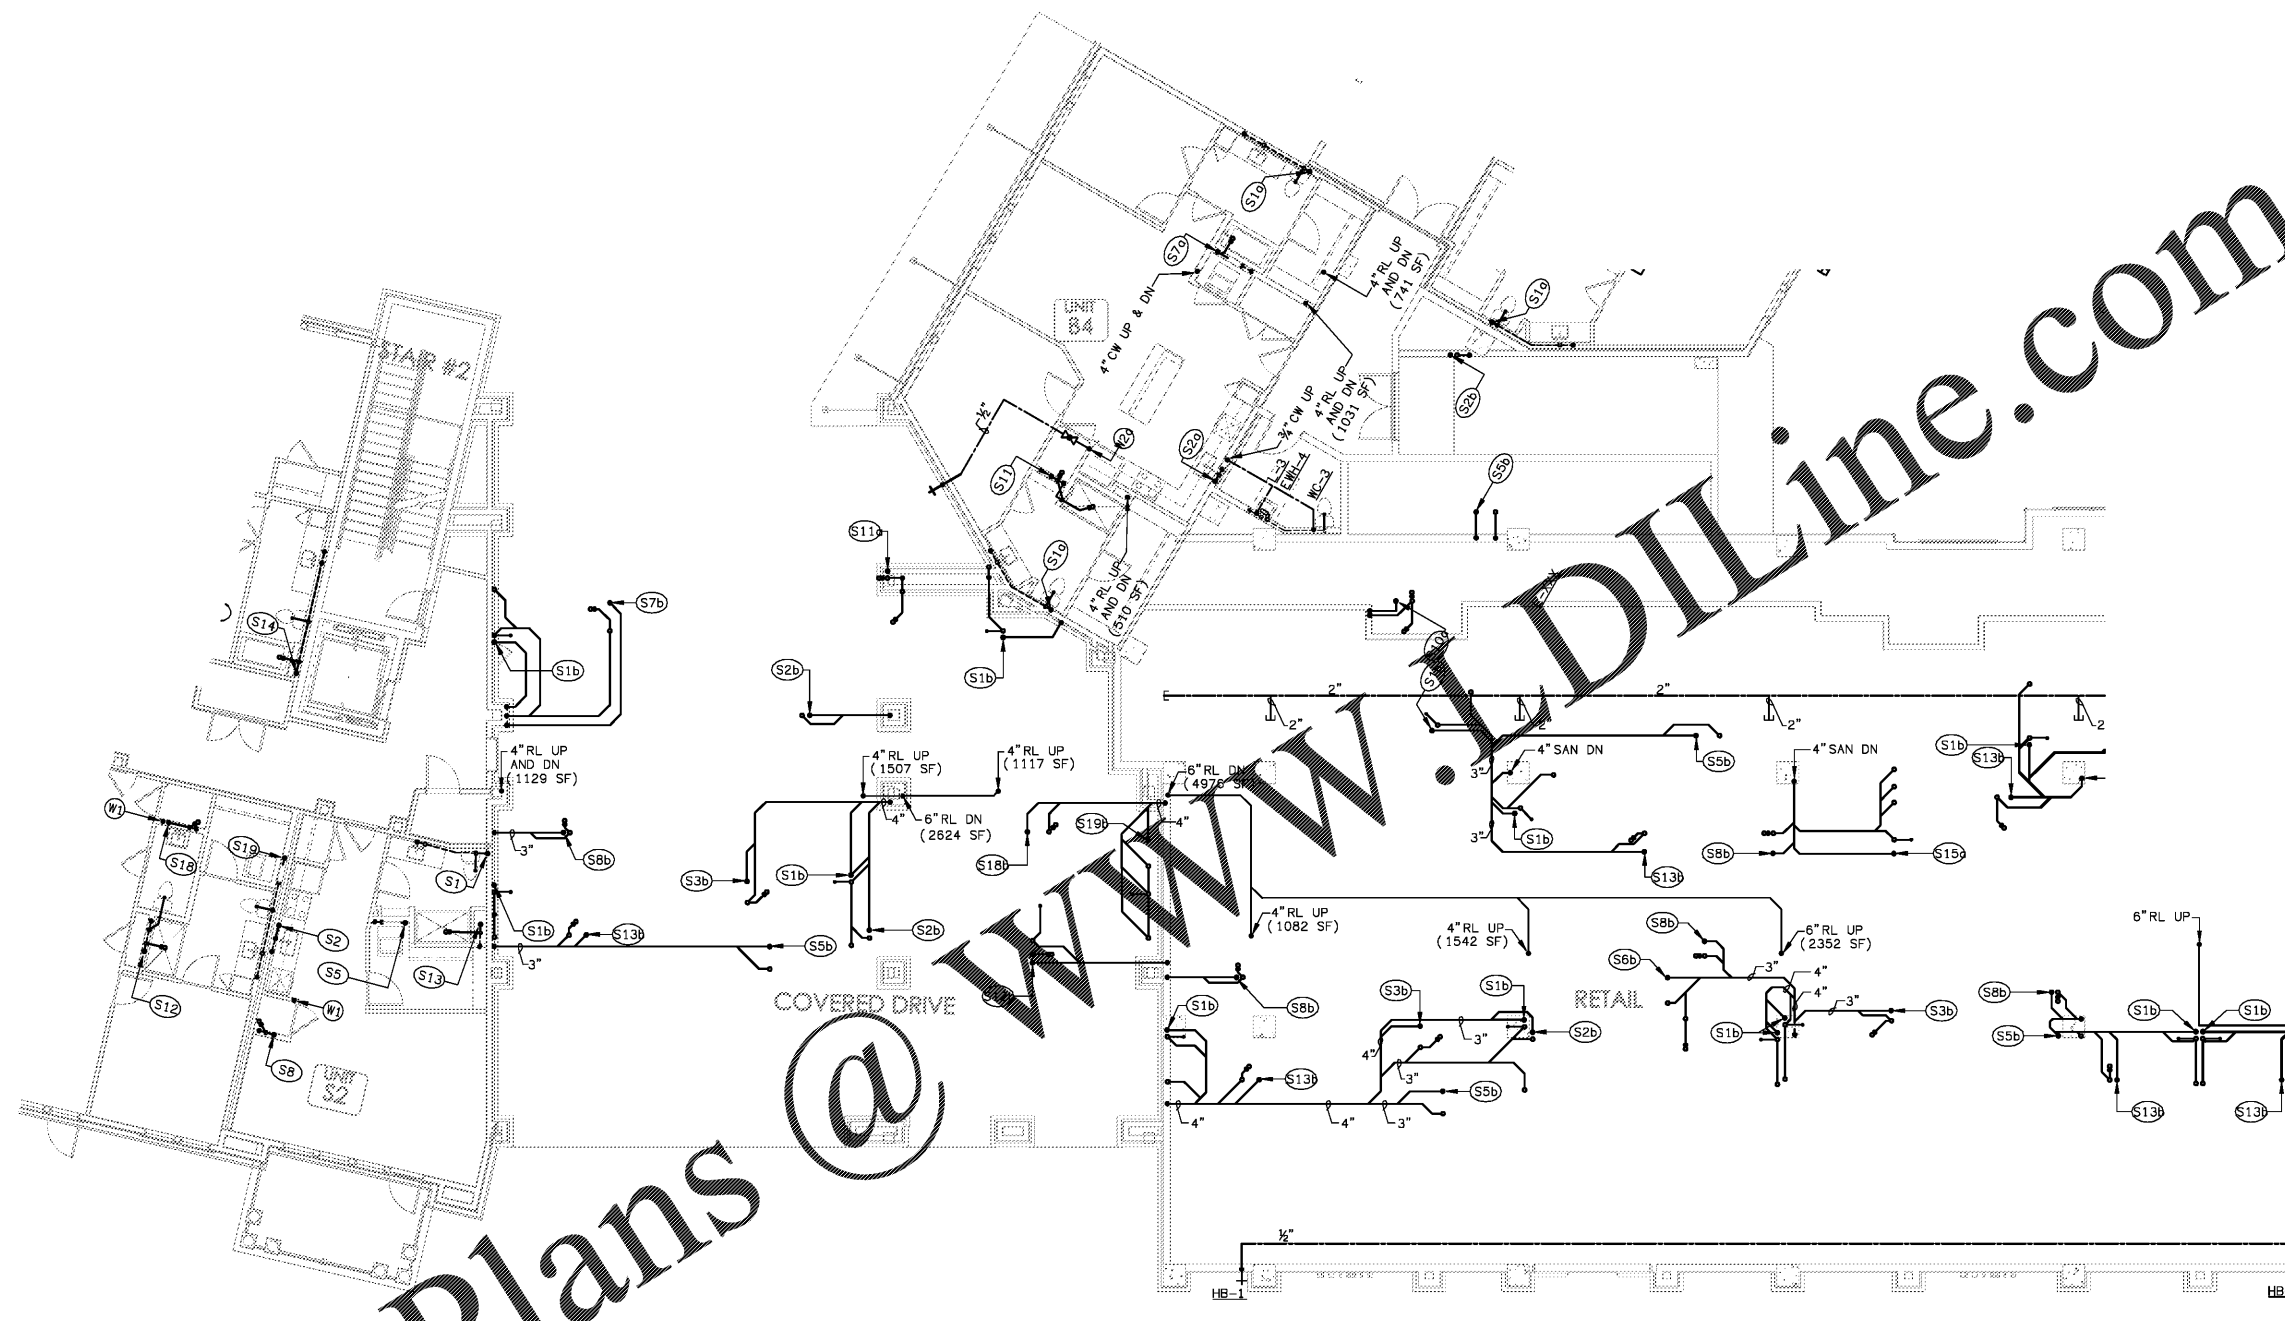


WHOLE SHEET CLASSED


1 PARTIAL BUILDING PLAN B - (01) FIRST FLOOR - PLUMBING PLAN
SCALE: 1/8" = 1'-0"
18025-P-BLDG

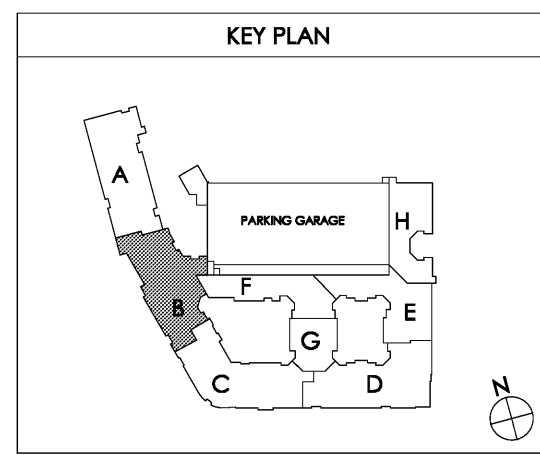

Common North, Prospect, KY
Architect Name
Charlan Brock & Associates, AAC000796



780 FLORIDA CENTRAL PARKWAY
SUITE 224
LONGWOOD, FL 32750
PH: 407.336.7999
PROJECT #: 18025

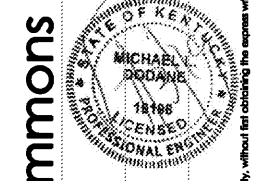

Lyric at Norton Commons
Prospect, Kentucky
Bristol Development Group
381 Mallory Station Rd, Suite 204
Franklin, TN 37067



architects • planners
1770 fennell street
maitland florida 32751-7208
407.660.8900 • 407.875.5948
www.cbarchitects.com

PARTIAL BUILDING
PLAN B - 1ST FLOOR
PLUMBING
PLAN

date: 06-04-2019
job no: 3789.16
drawn by: GNIK
reviewed by: GNIK
file: 18025-P-BLDG
issue history:
07-03-2019

P1.11B

Charlan Brock & Associates, Inc. hereby reserves all copyright, trademark, patent, and other rights in these plans, ideas, and designs. These plans, ideas, and designs are the property of Charlan Brock & Associates, Inc. and shall remain the property of Charlan Brock & Associates, Inc. No part of these plans, ideas, and designs may be reproduced, stored in a retrieval system, or transmitted in any form or by any means, electronic, mechanical, photocopying, recording, or by any information storage and retrieval system, without the prior written permission of Charlan Brock & Associates, Inc. All dimensions and notes are in feet and inches unless otherwise specified.