



Miller Engineers, LLC - 18025-P-BLDG - P-111H - Partial Plumbing Plan, June 04, 2019 by William Douglas

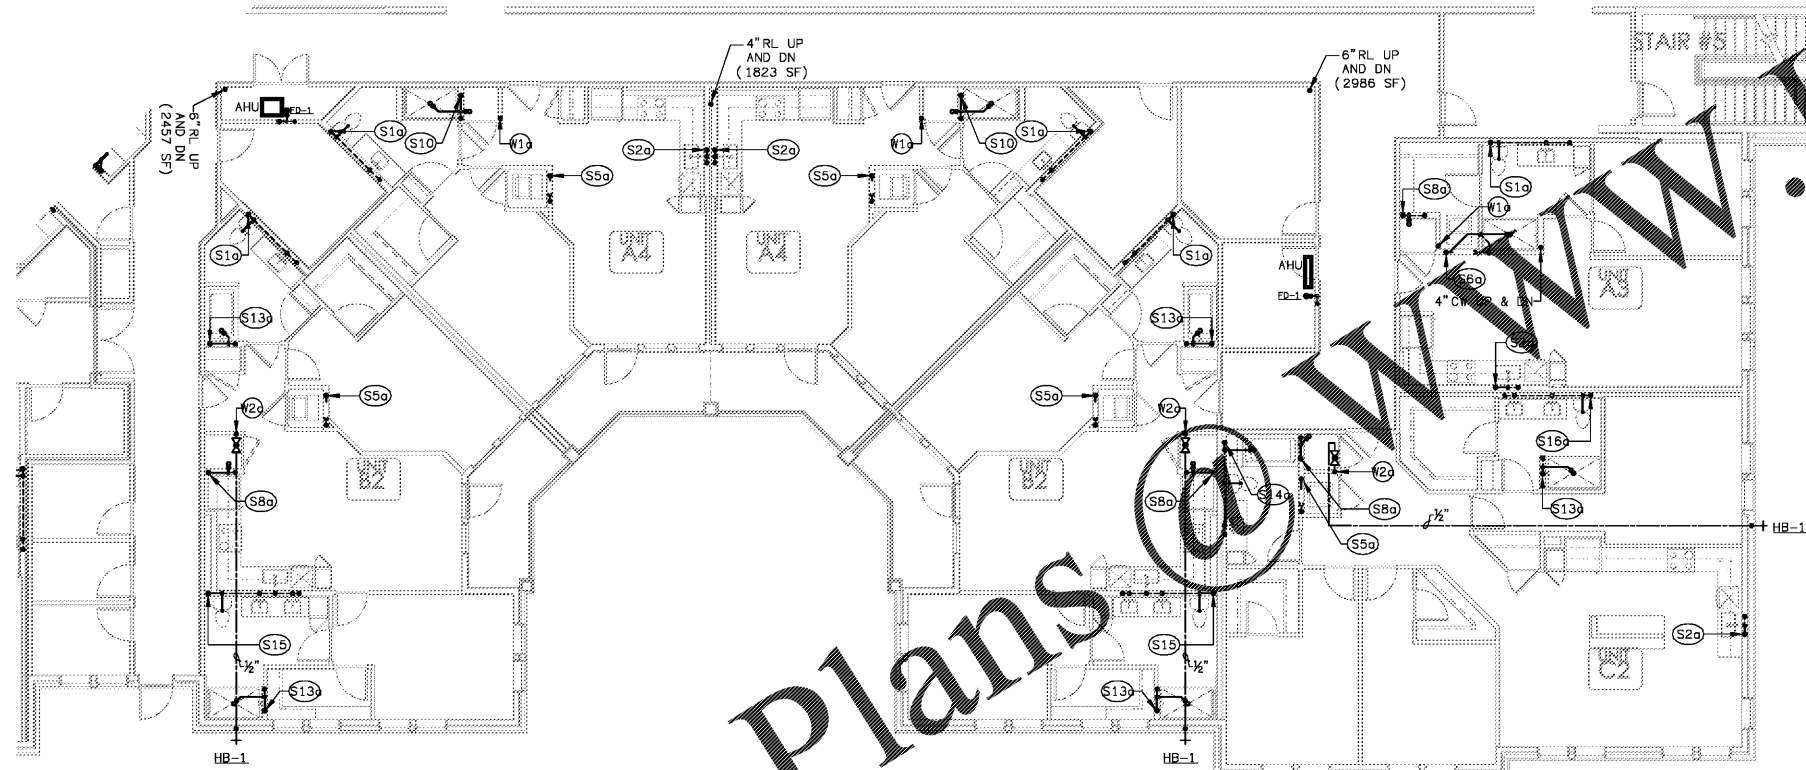


WHILE SHEET IS OPEN

Order Plans @ [www.LDILine.com](http://www.LDILine.com)


**1** PARTIAL BUILDING PLAN H - (01) FIRST FLOOR - PLUMBING PLAN  
SCALE 1/8" = 1'-0" 18025-P-BLDG

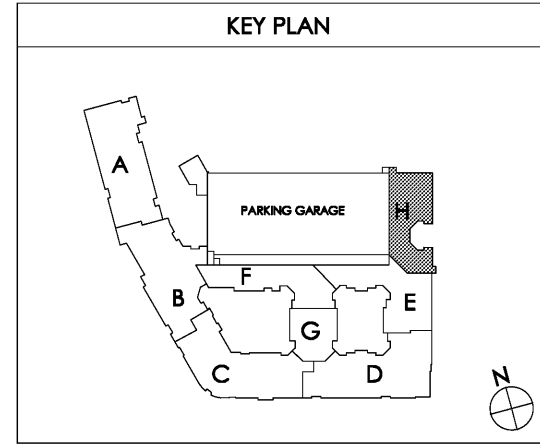

 Common North, Prospect, KY  
Architect Name  
Charlan Brock Associates, AAC000796



780 FLORIDA CENTRAL PARKWAY  
SUITE 224  
LONGWOOD, FL 32750  
PH: 407.336.7999  
PROJECT #: 18025

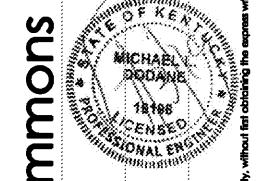

Lyric at Norton Commons  
Prospect, Kentucky  
Bristol Development Group  
381 Malloy Station Rd, Suite 204  
Franklin, TN 37067



architects • planners  
1770 fennell street  
maitland florida 32751-7208  
407.660.8900 • 407.875.5948  
www.cbaarchitects.com

PARTIAL BUILDING  
PLAN H - 1ST FLOOR  
PLUMBING  
PLAN

date: 06-04-2019  
job no: 3789.16  
drawn by: GNIK  
reviewed by: GNIK  
file: 18025-P-BLDG  
issue history:  
07-03-2019

P1.11H

Order Plans @ www.LDILine.com. This drawing is the property of the engineer and shall not be reproduced, changed or copied in any form or manner whatsoever, nor are they to be employed in any filed party, without first obtaining the express written permission from C.B.A., Inc. All dimensions and notes precedence over scale dimensions.