


Order Plans

WWW.LDMLINE.COM

1 PLUMBING - 2000 ACCESS TO UNIT BATHROOM

2 PLUMBING - 2000 ACCESS TO UNIT BATHROOM

3 PLUMBING - 2000 ACCESS TO UNIT BATHROOM

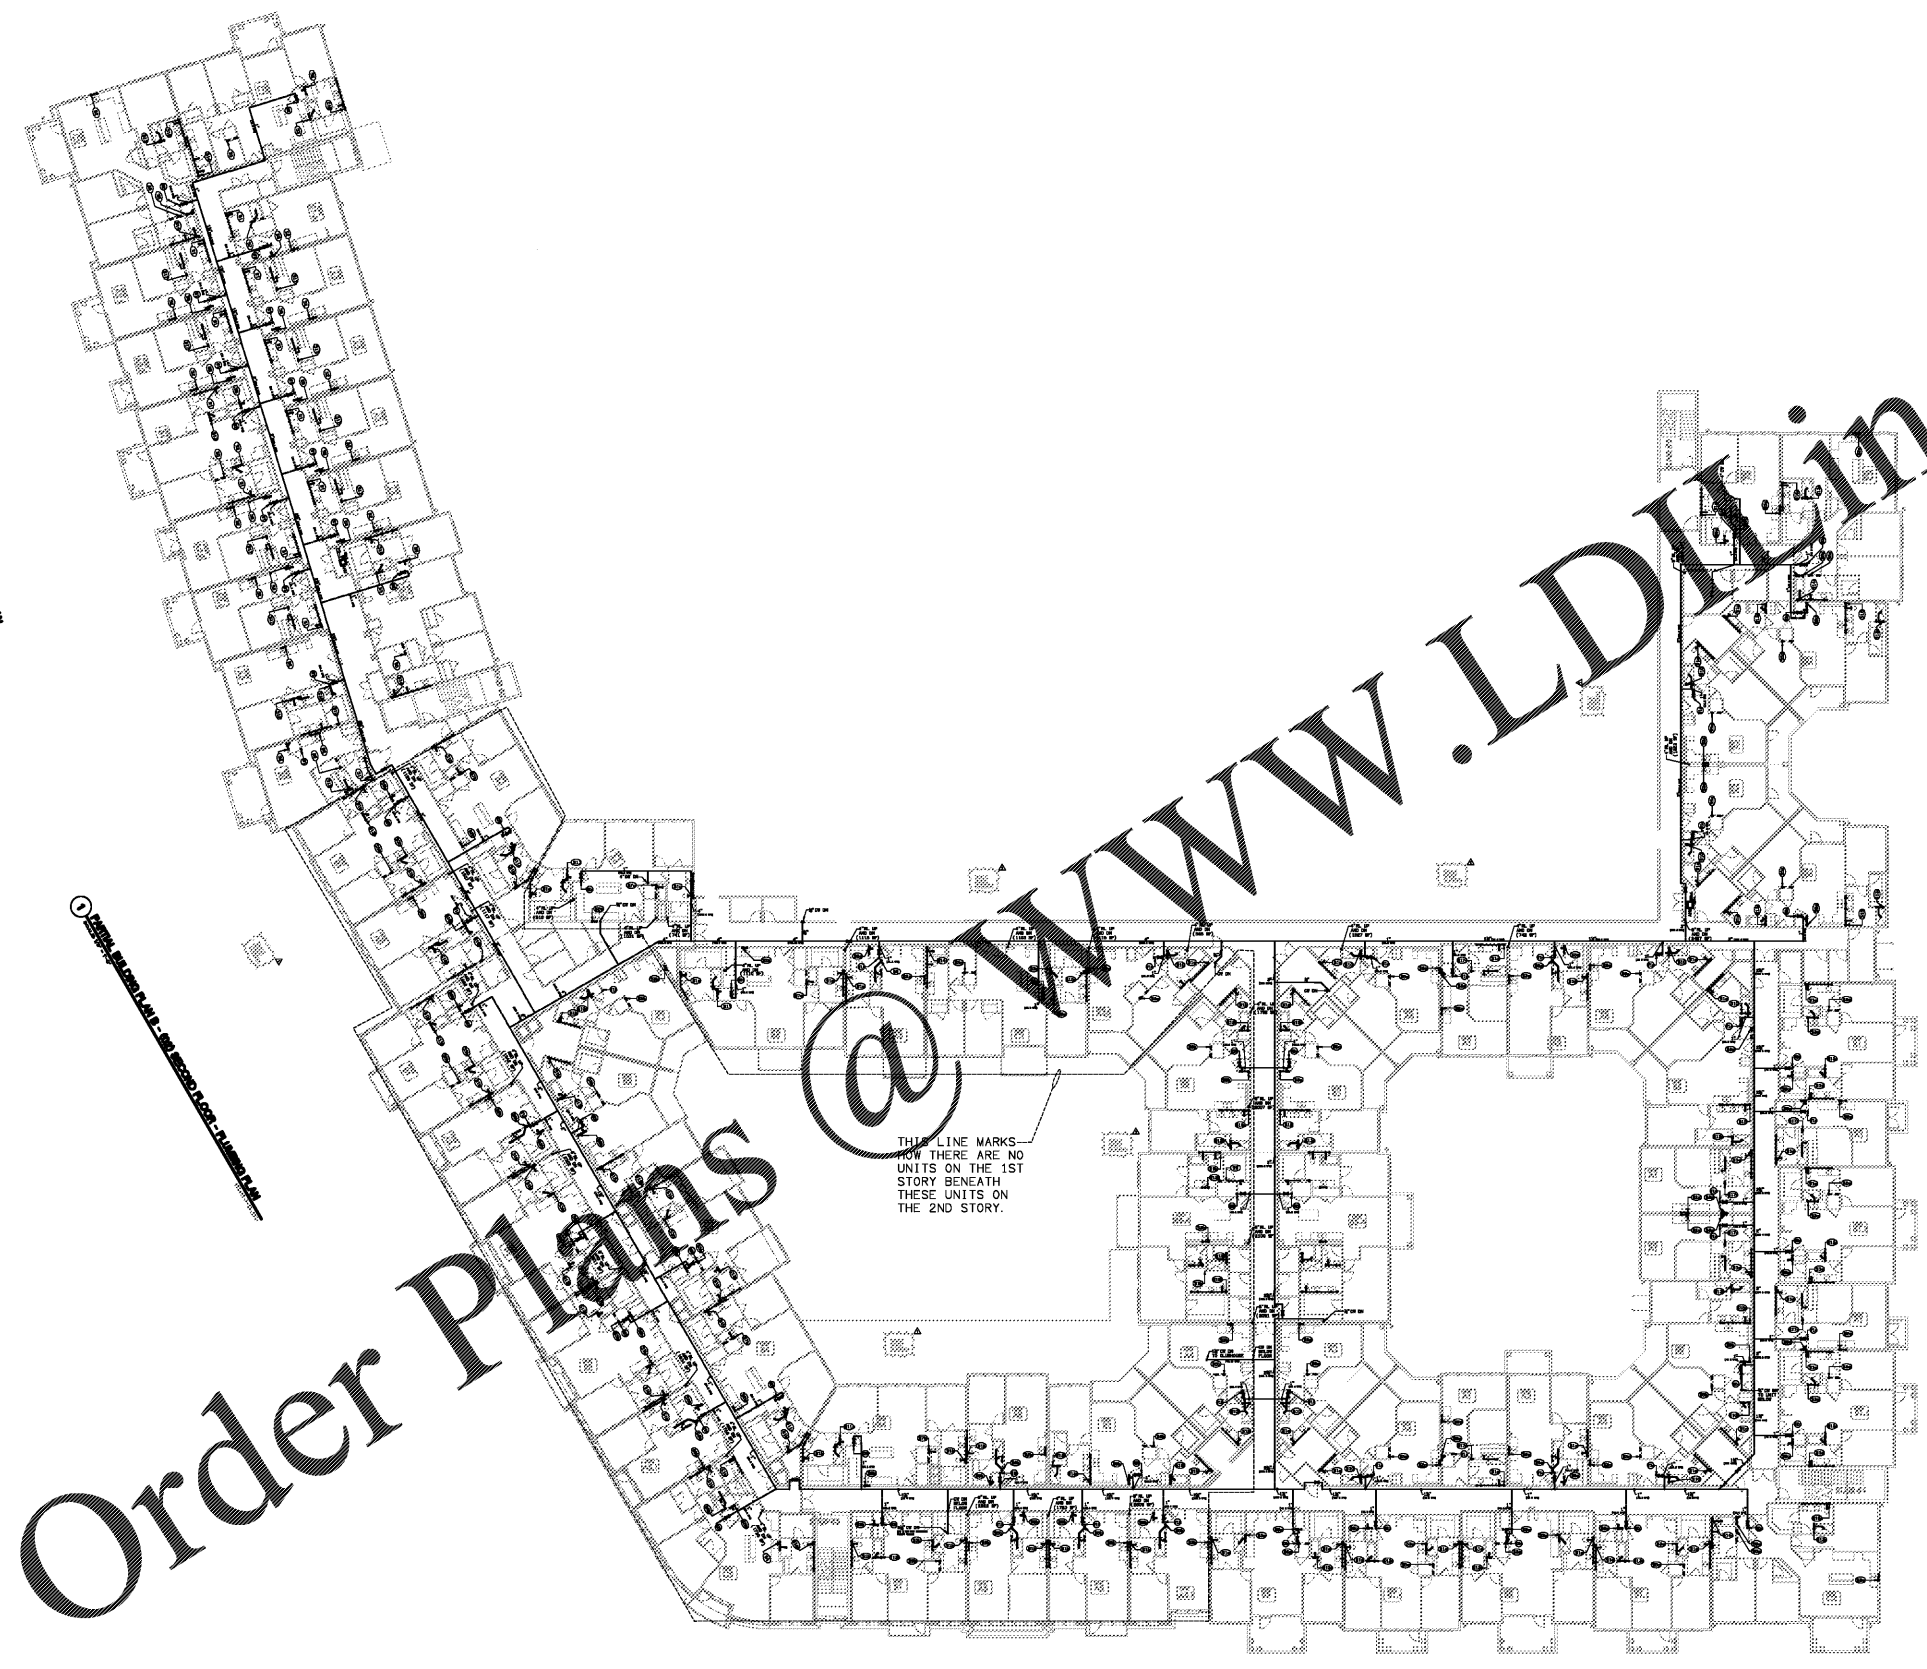

1 PARTIAL BUILDING PLAN C - 2ND SECOND FLOOR - PLUMBING PLAN

1 PARTIAL BUILDING PLAN D - 2ND SECOND FLOOR - PLUMBING PLAN

1 BUILDING TYPE ONE SECOND FLOOR - PLUMBING PLAN

SCALE: 1" = 25'-0"


180225-P-02-03.DWG

Common North, Prospect, KY



**MiGre**  
Engineers LLC

780 FLORIDA CENTRAL PARKWAY  
SUITE 224  
LONGWOOD, FL 32750  
PH: 407.336.7999  
PROJECT #: 18025

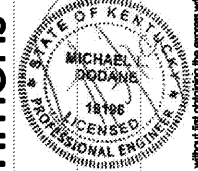

Lyric at Norton Commons  
Prospect, Kentucky

Bristol Development Group  
381 Malley Station Rd, Suite 204  
Franklin, TN 37067

**charlan • brock**  
associates

architects • planners  
1770 fennell street  
maitland florida 32751-7208  
407.660.8900 • 407.875.9948  
www.cbaarchitects.com

BUILDING TYPE ONE  
SECOND FLOOR  
PLUMBING  
PLAN

date: 06-04-2019  
job no: 3789.15  
drawn by: GNIK  
reviewed by: GNIK  
file: 180225-P-BLDG  
issue history: 07-03-2019

P1.12

Charlan Brock Associates, Inc. hereby reserves its copyright in these plans, ideas, and designs. These plans, ideas, and designs are not to be reproduced, changed or copied in any form or manner whatsoever, nor are they to be assigned to any third party, without first obtaining the express written permission from C.B.A., Inc. All dimensions and floor plan dimensions are shown in feet and inches. To the best of the engineer's knowledge, the plan and specification comply with the applicable minimum building codes and the applicable industry standards.

MiGre Engineers, LLC - 780 Florida Central Parkway - P.O. Box 224 - Longwood, Florida 32750