



Order Plans @ WWW.DIline.com

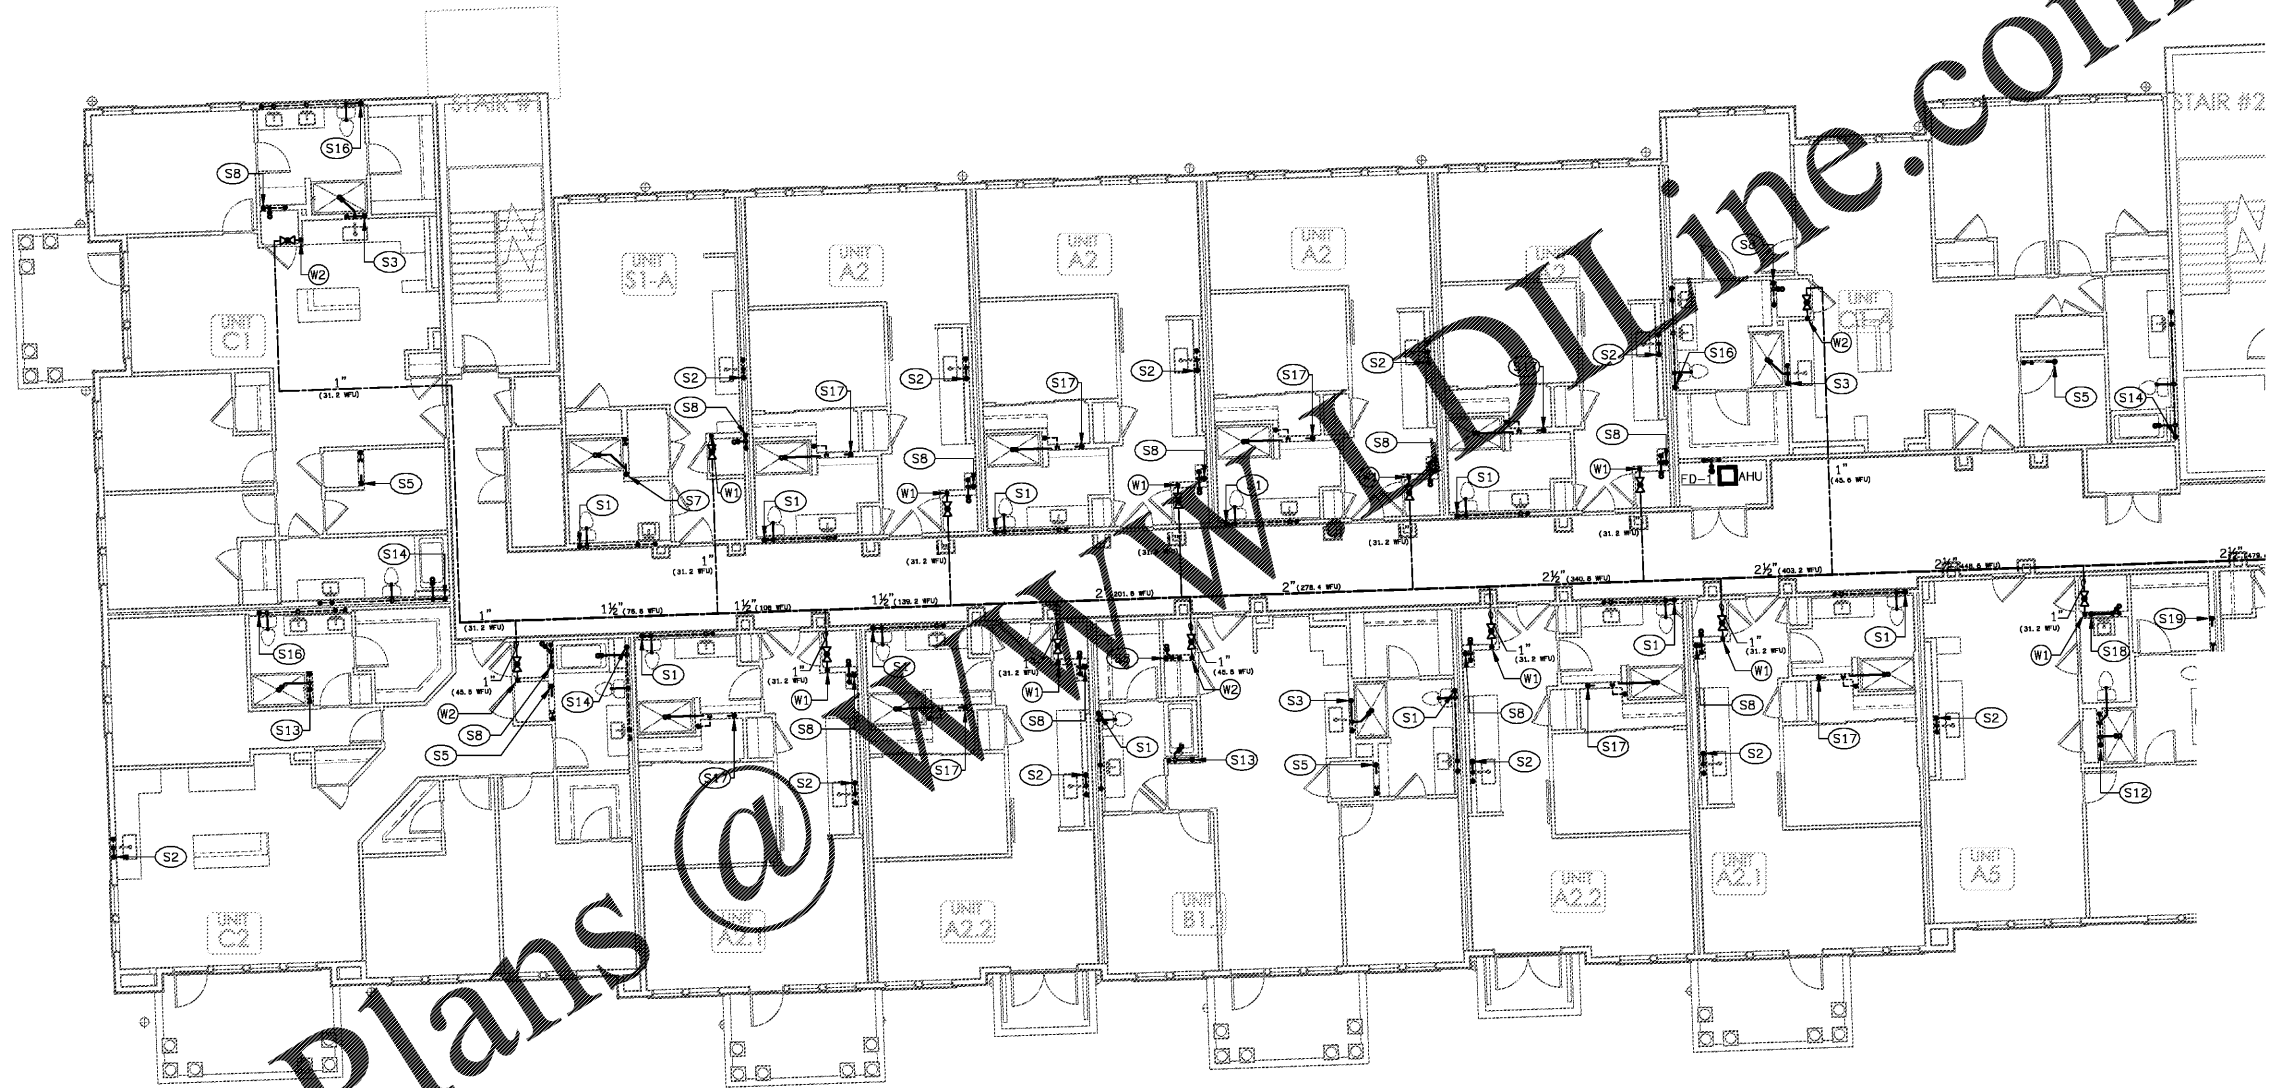

1 PARTIAL BUILDING PLAN A - (02) SECOND FLOOR - PLUMBING PLAN
SCALE: 1/8" = 1'-0"
8025-P-BLDG

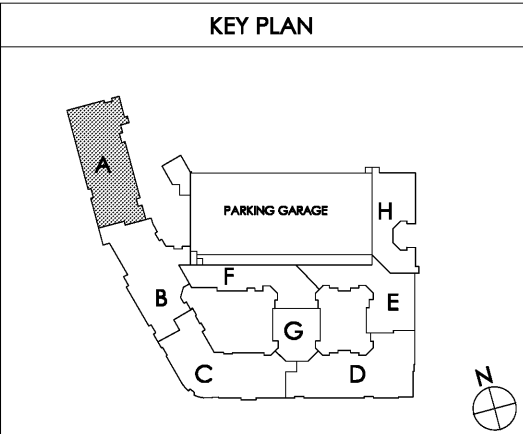

Common North, Prospect, KY
Architect: **Migre Engineers LLC**
8500 N. KY 100
Franklin, KY 40525

780 FLORIDA CENTRAL PARKWAY
SUITE 224
LONGWOOD, FL 32750
PH: 407.336.7999
PROJECT #: 18025

Lyric at Norton Commons
Prospect, Kentucky
Bristol Development Group
381 Military Station Rd, Suite 204
Franklin, TN 37067

charlan • brock associates
architects • planners
1770 fennell street
maitland florida 32751-7208
407.660.8900 • 407.875.5948
www.cbaarchitects.com

PARTIAL BUILDING
PLAN A - 2ND FLOOR
PLUMBING
PLAN

date: 06-04-2019
job no: 3789.16
drawn by: GNIK
reviewed by: GNIK
file: 18025-P-BLDG
issue history:

P1.12A

© 2019 by Migre Engineers, LLC. All rights reserved. This document is the property of Migre Engineers, LLC. It is to be used only for the project and location specified on the title block. No part of this document may be reproduced, stored in a retrieval system, or transmitted, in any form or by any means, without the prior written permission of Migre Engineers, LLC.