



Order Plans

STORY BENEATH
THESE UNITS ON
THE 2ND STORY.


WWW.LDILine.com

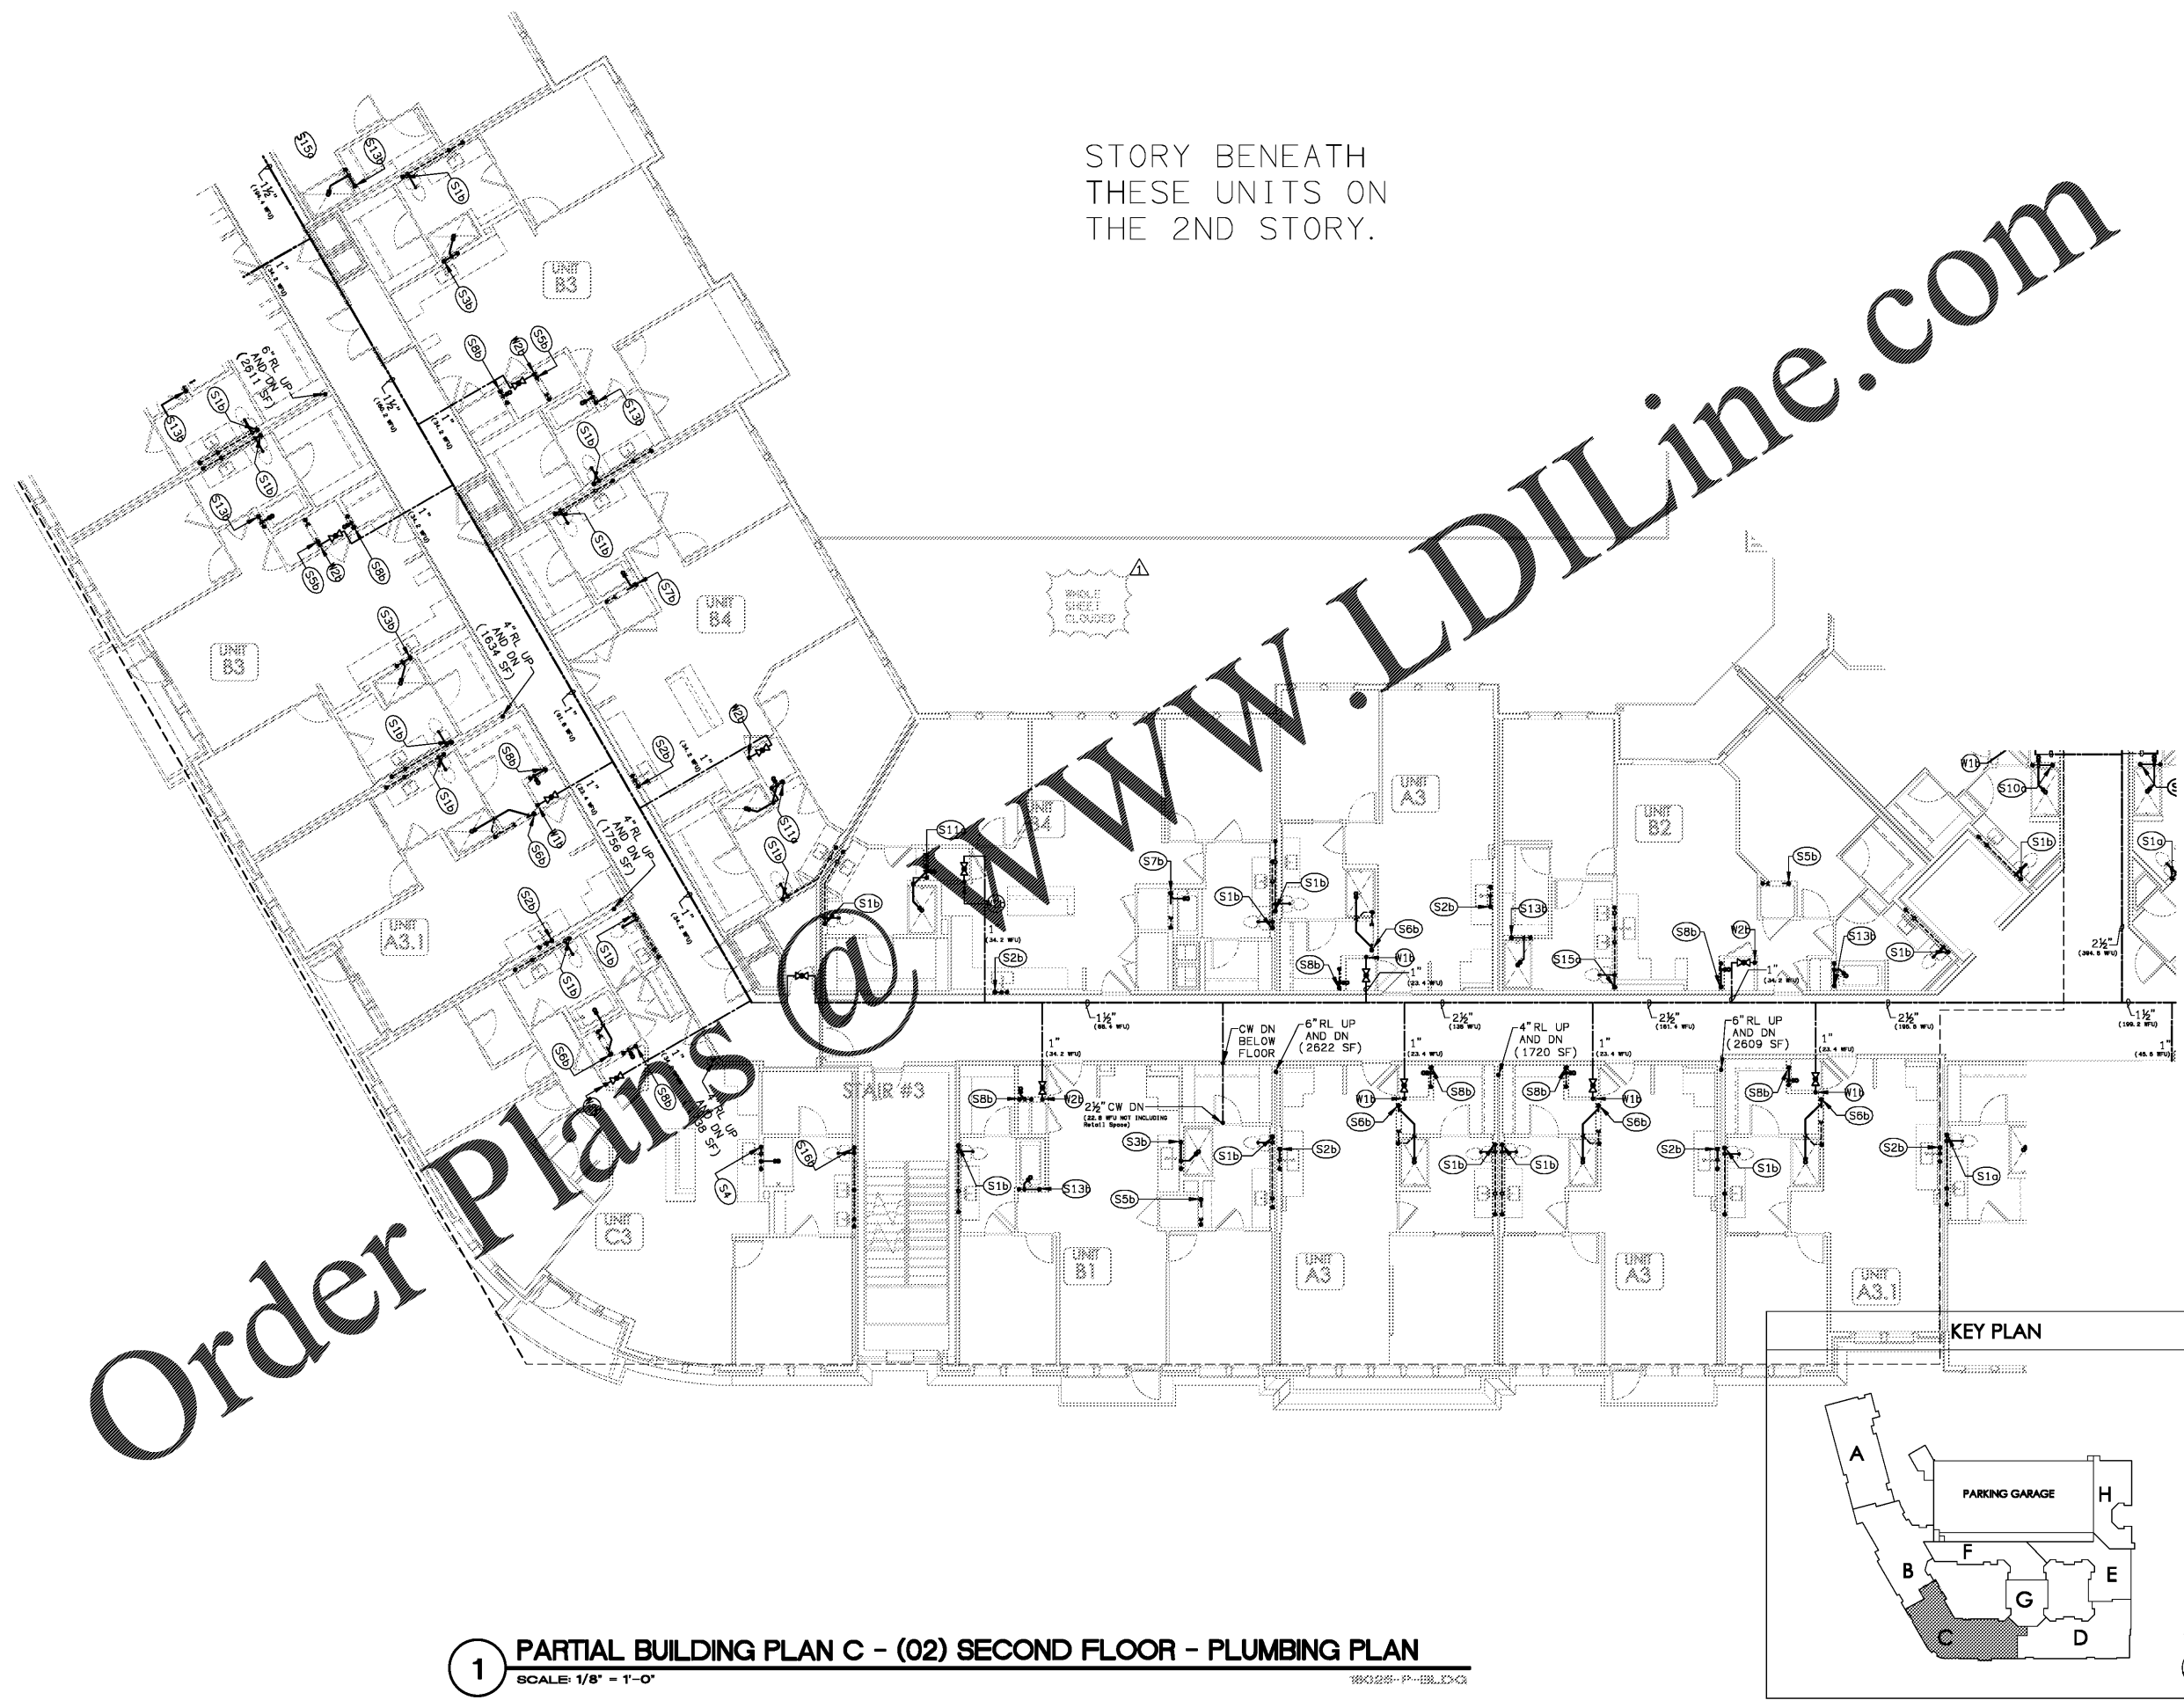

1 PARTIAL BUILDING PLAN C - (02) SECOND FLOOR - PLUMBING PLAN
SCALE: 1/8" = 1'-0"

Common North, Prospect, KY

MiGre
 Engineers LLC
 780 FLORIDA CENTRAL PARKWAY
 SUITE 224
 LONGWOOD, FL 32750
 PH: 407.336.7999
 PROJECT #: 18025

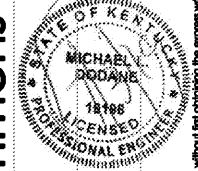Lyric at Norton Commons
 Prospect, Kentucky
 Bristol Development Group
 381 Mallory Station Rd, Suite 204
 Franklin, TN 37067


 charlan • brock
 associates
 architects • planners
 1770 fennell street
 maitland florida 32751-7208
 407.660.8900 • 407.875.5948
 www.cbaarchitects.com

PARTIAL BUILDING
 PLAN C - 2ND FLOOR
 PLUMBING
 PLAN
 date: 06-04-2019
 job no: 3789.16
 drawn by: GNIK
 reviewed by: GNIK
 file: 18025-P-BLDG
 issue history:
 07-03-2019
 P1.12C

LDI Engineers, LLC - 18025-P-BLDG-PL-100 - Partial Building Plan C - (02) Second Floor - Plumbing Plan

Order, check, or modify this drawing in accordance with the contract documents. The drawings are not to be reproduced, changed or copied in any form or manner whatsoever, nor are they to be enlarged to any other party, without first obtaining the express written permission from C.D.L., Inc. All dimensions and notes are in feet and inches unless otherwise specified.