



Order Plans @ WWW.DILine.com

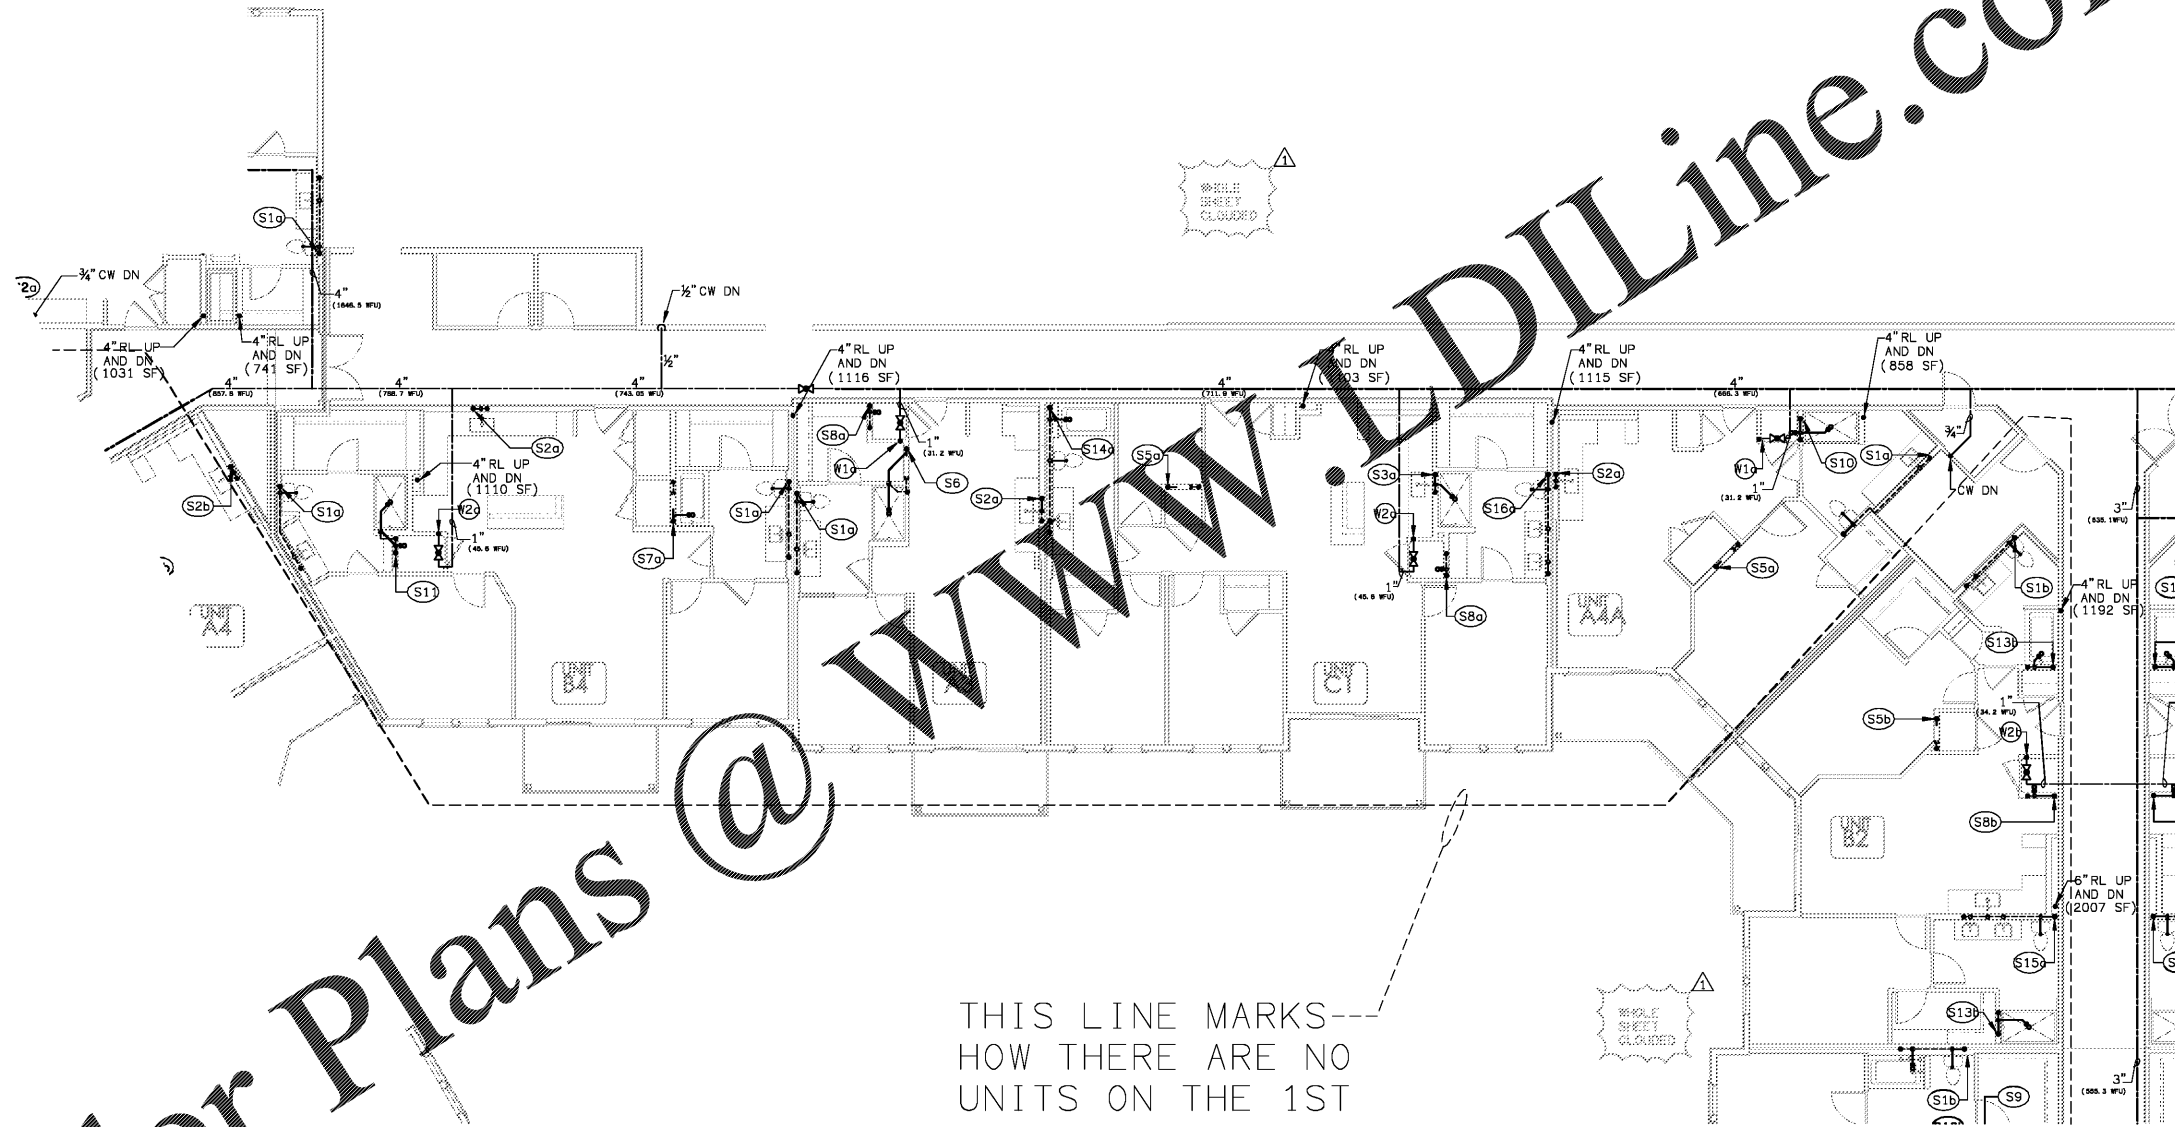

THIS LINE MARKS HOW THERE ARE NO UNITS ON THE 1ST

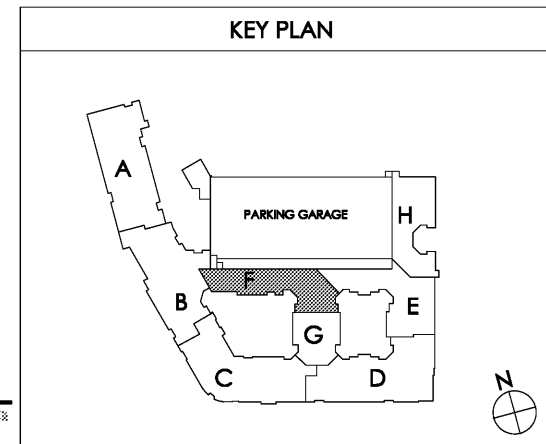

1 PARTIAL BUILDING PLAN F - (02) SECOND FLOOR - PLUMBING PLAN
SCALE: 1/8" = 1'-0" 18025-P-BLDG

This drawing is the property of MiGre Engineers LLC. It is to be used only for the project and location specified. No part of this drawing may be reproduced, stored in a retrieval system, or transmitted in any form or by any means, electronic, mechanical, photocopying, recording, or by any information storage and retrieval system, without the prior written permission of MiGre Engineers LLC.