



Miller Engineers, LLC - 18025-P-BLDG - P-12H - Partial Building Plan H - (02) Second Floor - Plumbing Plan

 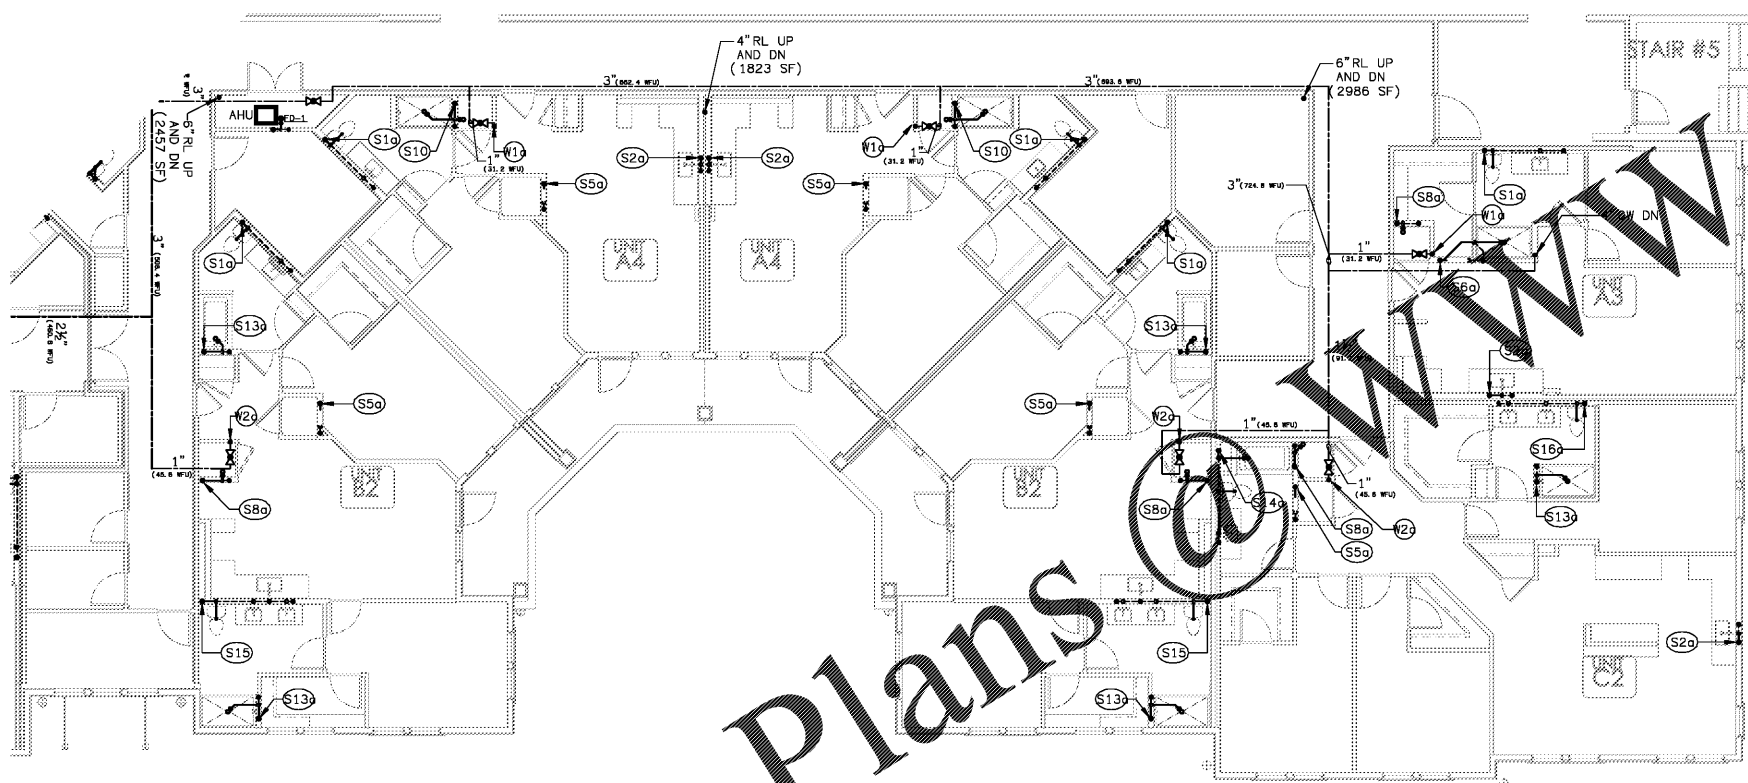


Order Plans @ WWW.LDILine.com


1 PARTIAL BUILDING PLAN H - (02) SECOND FLOOR - PLUMBING PLAN  
SCALE 1/8" = 1'-0" 18025-P-BLDG

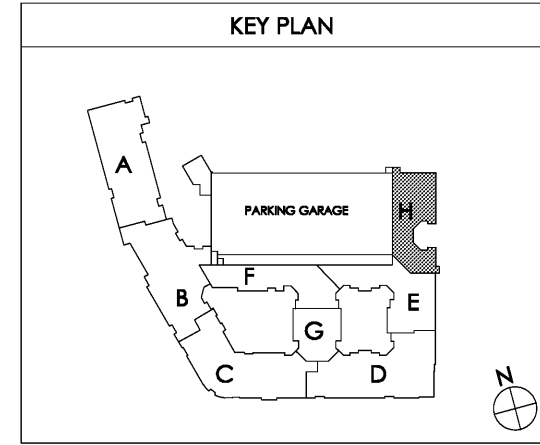

Common North, Prospect, KY  
Architect Name  
Charlan Brock & Associates, A4000796



780 FLORIDA CENTRAL PARKWAY  
SUITE 224  
LONGWOOD, FL 32750  
PH: 407.336.7999  
PROJECT #: 18025

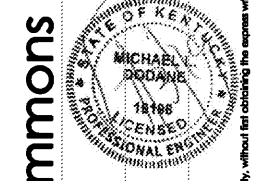

Lyric at Norton Commons  
Prospect, Kentucky  
Bristol Development Group  
381 Malloy Station Rd, Suite 204  
Franklin, TN 37067



architects • planners  
1770 fennell street  
maitland florida 32751-7208  
407.660.8900 • 407.875.5948  
www.cbaarchitects.com

PARTIAL BUILDING  
PLAN H - 2ND FLOOR  
PLUMBING  
PLAN

date: 06-04-2019  
job no: 3789.16  
drawn by: GNIK  
reviewed by: GNIK  
file: 18025-P-BLDG  
issue history:  
07-03-2019

P1.12H

Charlan Brock & Associates, A4000796, is hereby releasing its copyright in these plans, ideas, and designs. These plans, ideas, and designs are not to be reproduced, changed or copied in any form or manner whatsoever, nor are they to be assigned to any third party, without first obtaining the express written permission from C.B.A., Inc. All dimensions and floor plan dimensions are shown in feet and inches unless otherwise specified.