



Order Plans @

WWW.LDILine.com

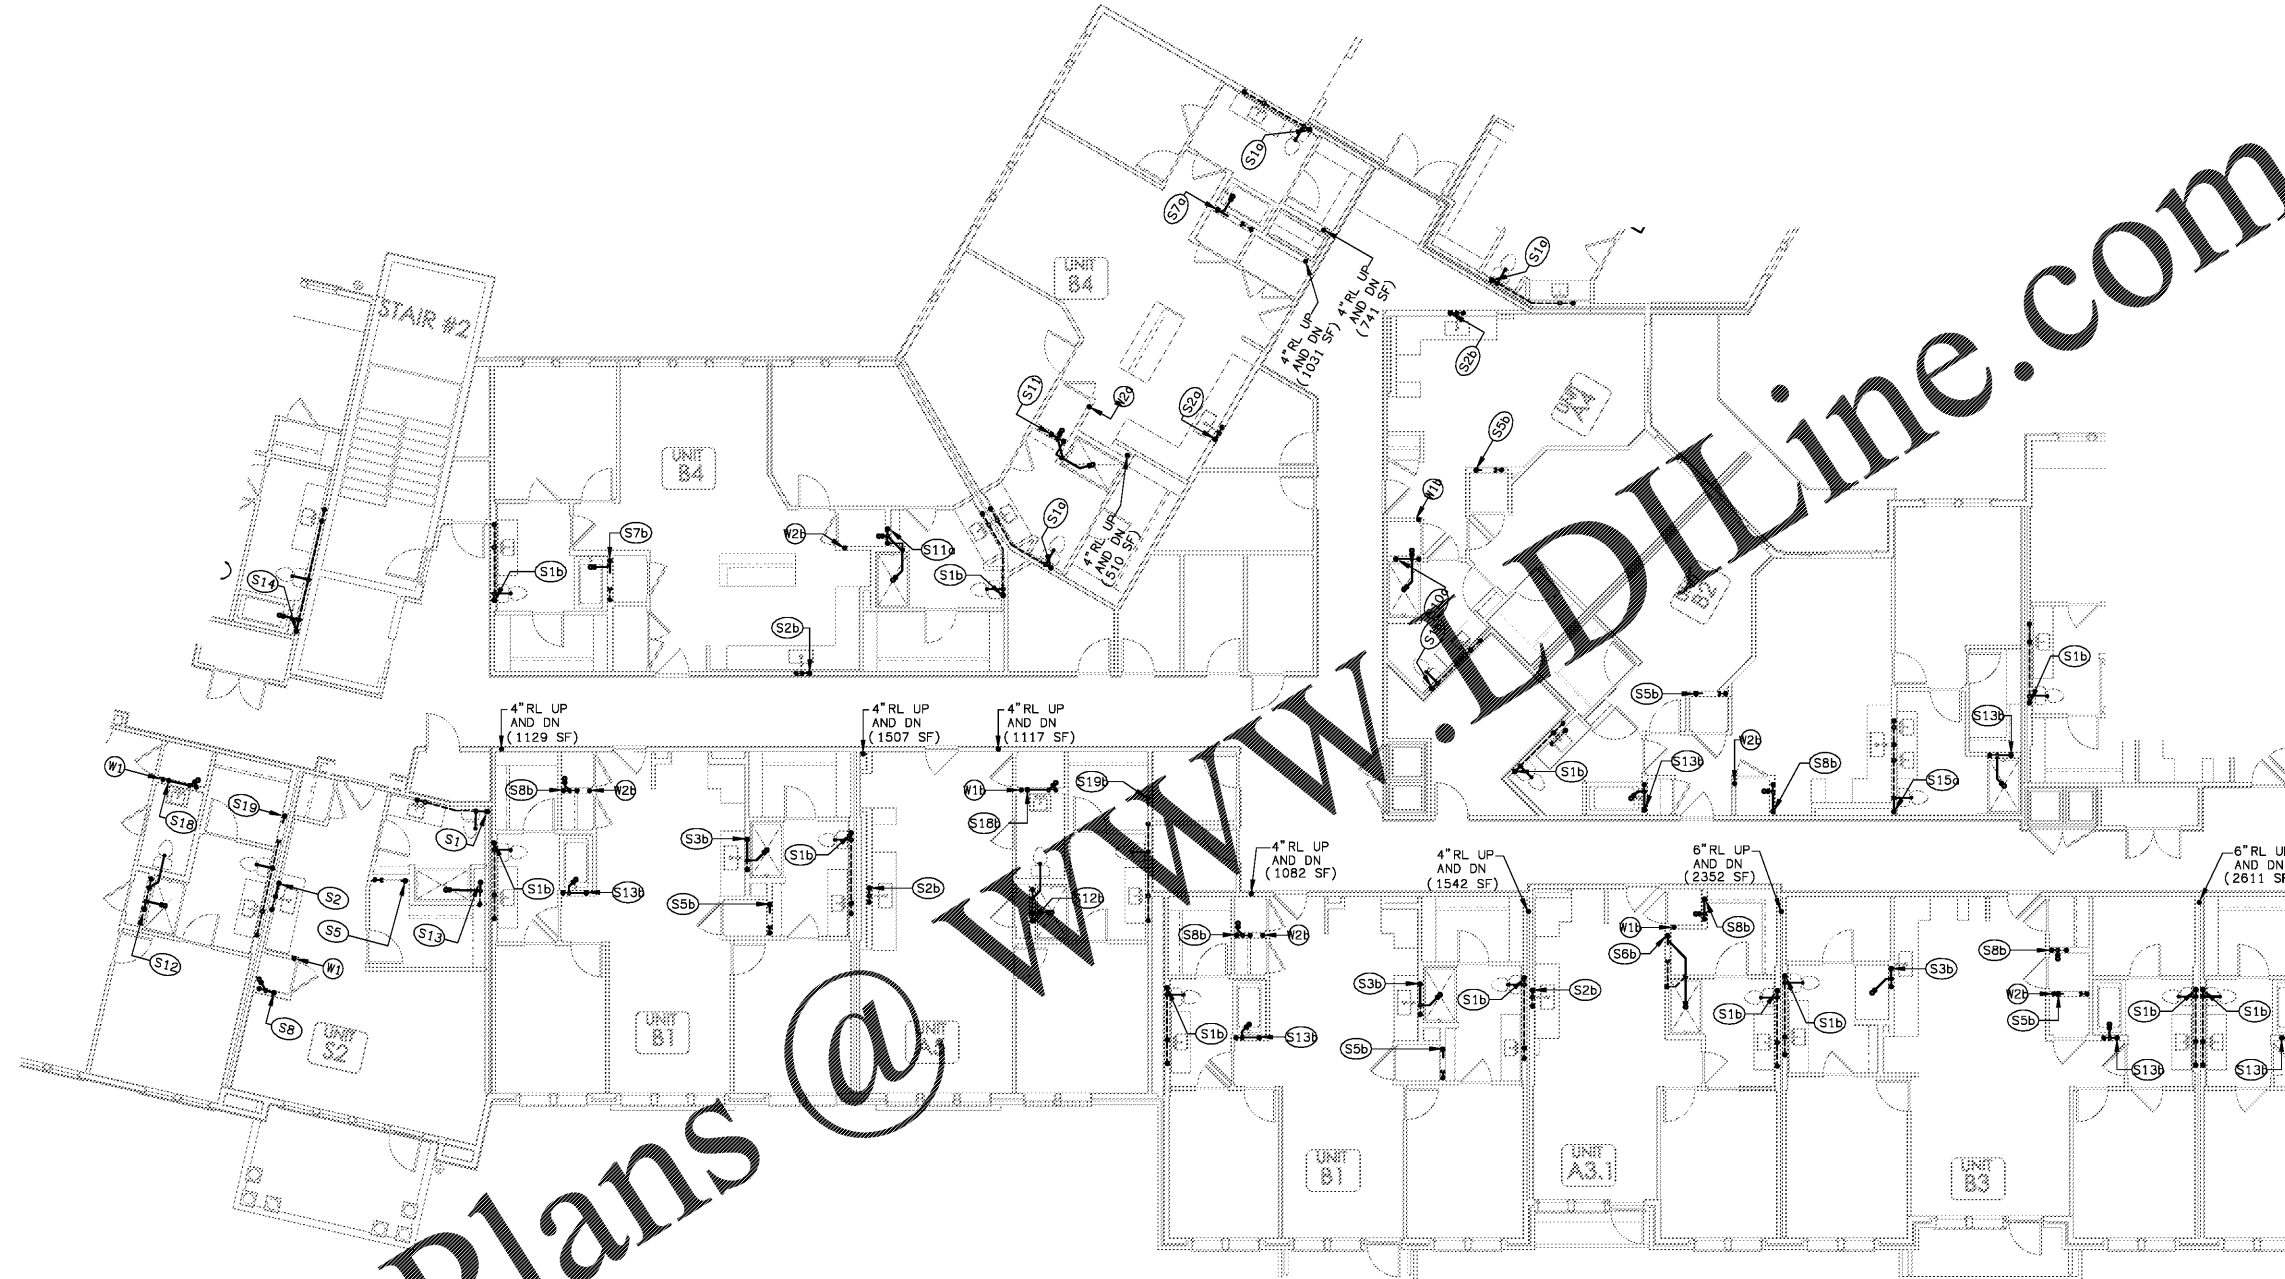

WHOLE SHEET
CLASSIFIED

1 PARTIAL BUILDING PLAN B - (03) THIRD FLOOR - PLUMBING PLAN
SCALE: 1/8" = 1'-0" 18025-P-BLDG

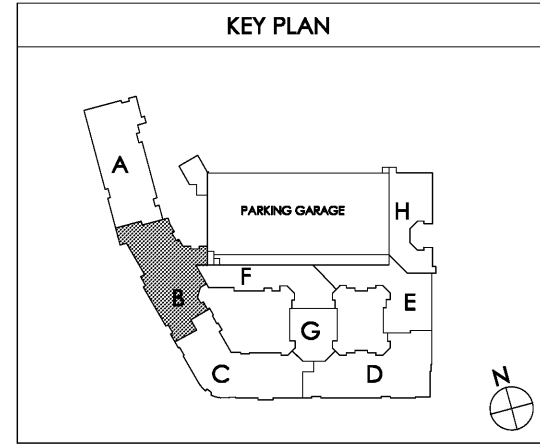

Common North, Prospect, KY
 KY
 MICHAEL SODANE
 18198
 LICENSED
 PROFESSIONAL ENGINEER

MiGre
 Engineers LLC
 780 FLORIDA CENTRAL PARKWAY
 SUITE 224
 LONGWOOD, FL 32750
 PH: 407.336.7999
 PROJECT #: 18025

Lyric at Norton Commons
 Prospect, Kentucky
 Bristol Development Group
 381 Mallory Station Rd, Suite 204
 Franklin, TN, 37067

charlan • brock
 associates
 architects • planners
 1770 fennell street
 maitland florida 32751-7208
 407.660.8900 • 407.875.5948
 www.cbarchitects.com

PARTIAL BUILDING
 PLAN B - 3RD FLOOR
 PLUMBING
 PLAN

date: 06-04-2019
 job no: 3789.16
 drawn by: GNIK
 reviewed by: GNIK
 file: 18025-P-BLDG
 issue history:
 07-03-2019

P1.13B

LDI Engineers, LLC - 18025-P-BLDG - P1.13B - Partial Building, Unit B, 3rd Floor by William D. I...

Order, back to, complete, has, been, received, in, comment, has, been, added, to, these, plans, ideas, and, details, have, been, added, and, plans, are, not, to, be, reproduced, changed, or, copied, in, any, form, or, manner, without, the, express, written, permission, from, C.D.L., P.C., written, dimensions, and, have, precedence, over, scale, dimensions.