


Order Plans @ WWW.LDILine.com

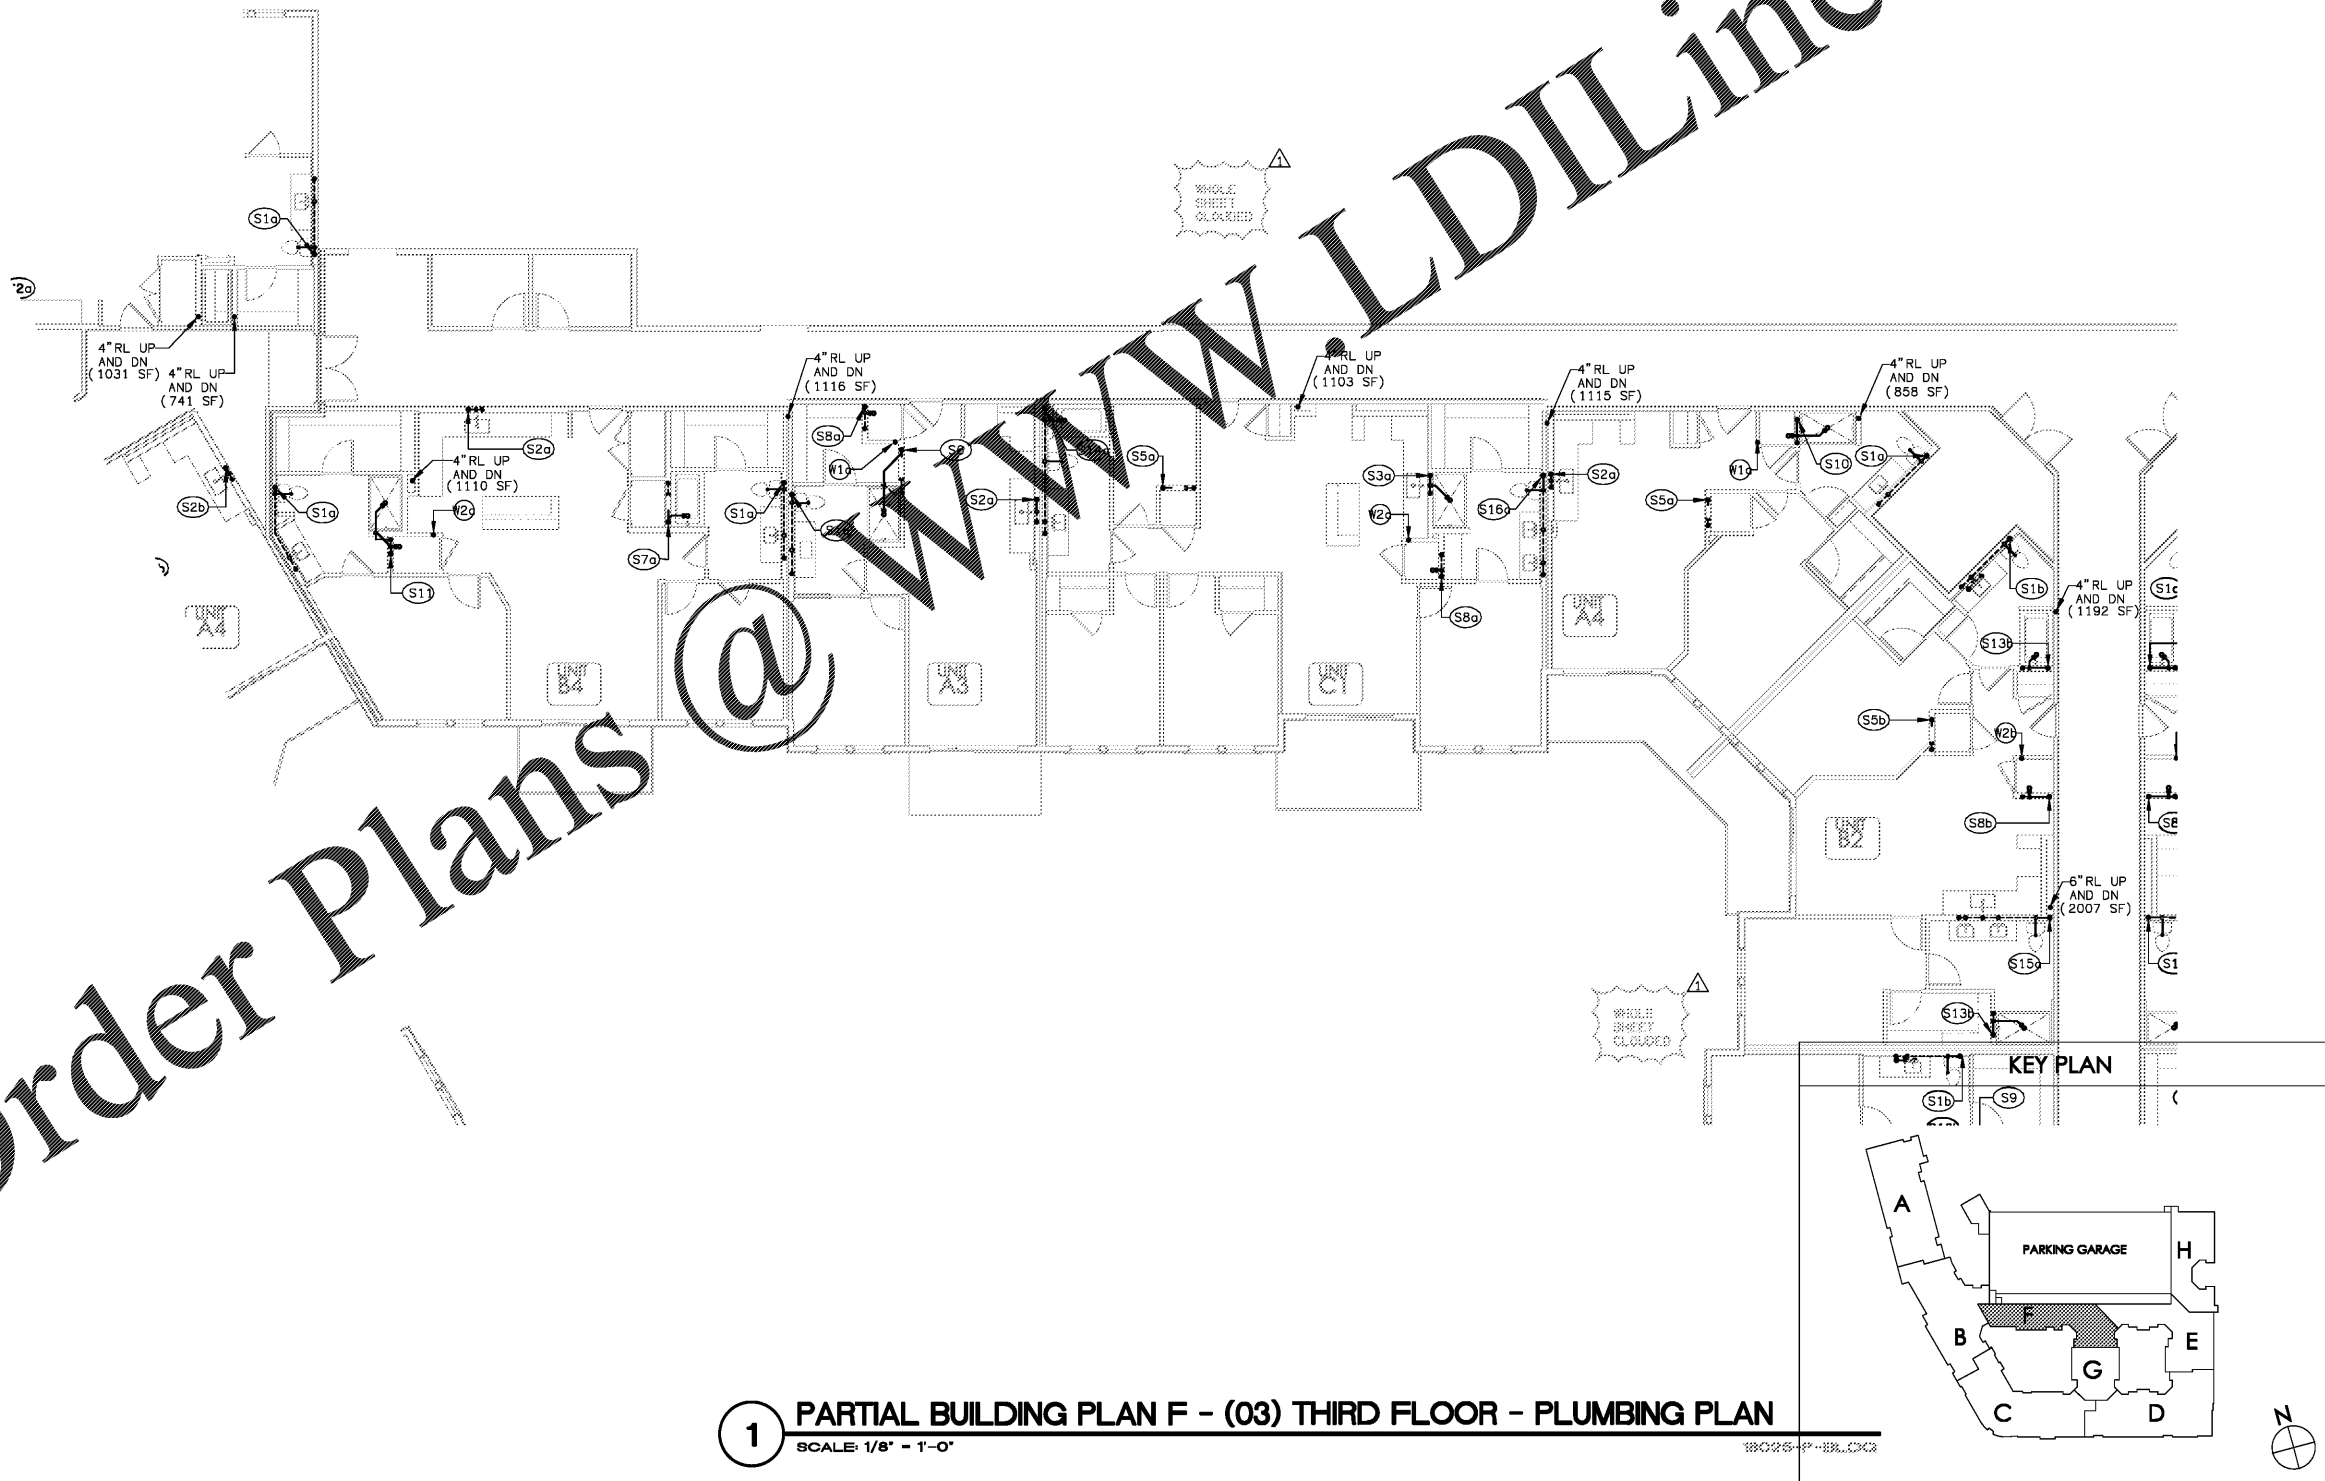

1 PARTIAL BUILDING PLAN F - (03) THIRD FLOOR - PLUMBING PLAN
SCALE: 1/8" = 1'-0"

Common North, Prospect, KY

MiGre
Engineers LLC

780 FLORIDA CENTRAL PARKWAY
SUITE 224
LONGWOOD, FL 32750
PH: 407.336.7999
PROJECT #: 18025

Lyric at Norton Commons
Prospect, Kentucky

Bristol Development Group
381 Malloy Station Rd, Suite 204
Franklin, TN 37067

charlan • brock
associates

architects • planners

1770 fennell street
maitland florida 32751-7208
407.660.8900 • 407.875.5948
www.cbaarchitects.com

PARTIAL BUILDING
PLAN F - 3RD FLOOR
PLUMBING
PLAN

date: 06-04-2019
job no: 3789.16
drawn by: GNIK
reviewed by: GNIK
file: 18025-P-BLDG
issue history:
07-03-2019

P1.13F

Professional Engineer Seal: MICHAEL SODANE, 18198, LICENSED PROFESSIONAL ENGINEER, STATE OF KENTUCKY

Architect Seal: CHARLAN BROCK, 18198, LICENSED ARCHITECT, STATE OF KENTUCKY

Small map of Kentucky

LDI Engineers, LLC - 18025-P-BLDG - P1.13F - Partial Building, June 04, 2019 by William D. LDI

Order, back to, and/or other information, including but not limited to, drawings, specifications, and/or other documents, shall be the responsibility of the user. The user shall be responsible for obtaining the necessary permissions for the use of these documents. The user shall be responsible for obtaining the necessary permissions for the use of these documents. The user shall be responsible for obtaining the necessary permissions for the use of these documents.