



www.migre.com

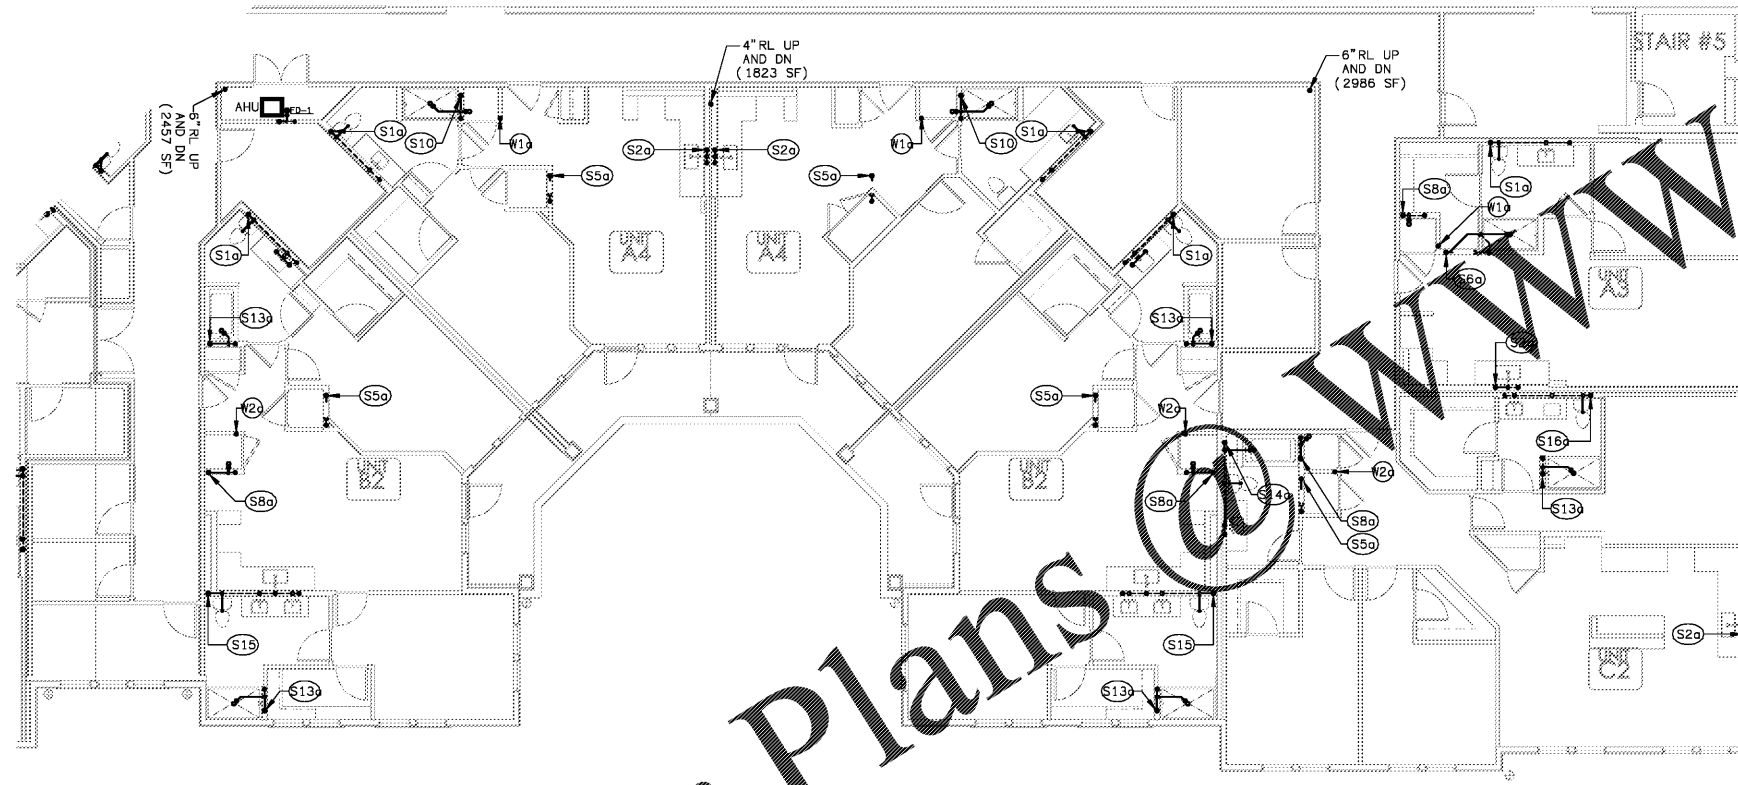

Order Plans @ WWW.LDILine.com

1 PARTIAL BUILDING PLAN H - (03) THIRD FLOOR - PLUMBING PLAN
SCALE 1/8" = 1'-0" 18025-P-BLDG

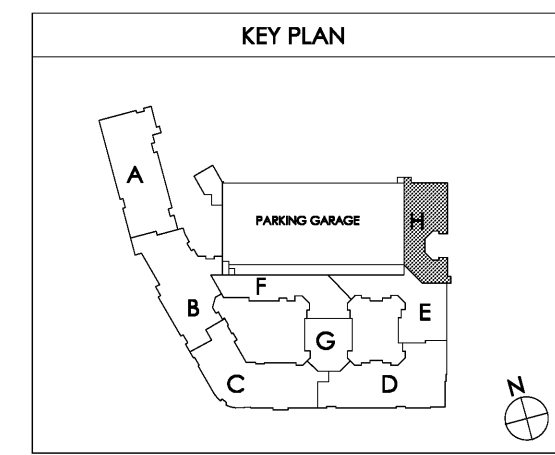

Common North, Prospect, KY
MIGRE
Engineers LLC
780 FLORIDA CENTRAL PARKWAY
SUITE 224
LONGWOOD, FL 32750
PH: 407.336.7999
PROJECT #: 18025



Lyric at Norton Commons
Prospect, Kentucky
Bristol Development Group
381 Malloy Station Rd, Suite 204
Franklin, TN 37067

charlan • brock
associates
architects • planners
1770 fennell street
maitland florida 32751-7208
407.660.8900 • 407.875.5948
www.cbaarchitects.com

PARTIAL BUILDING
PLAN H - 3RD FLOOR
PLUMBING
PLAN

date: 06-04-2019
job no: 3789.16
drawn by: GNIK
reviewed by: GNIK
file: 18025-P-BLDG
issue history:
07-03-2019

P1.13H

Order Plans @ WWW.LDILine.com