




Order Plans @ www.LDILine.com

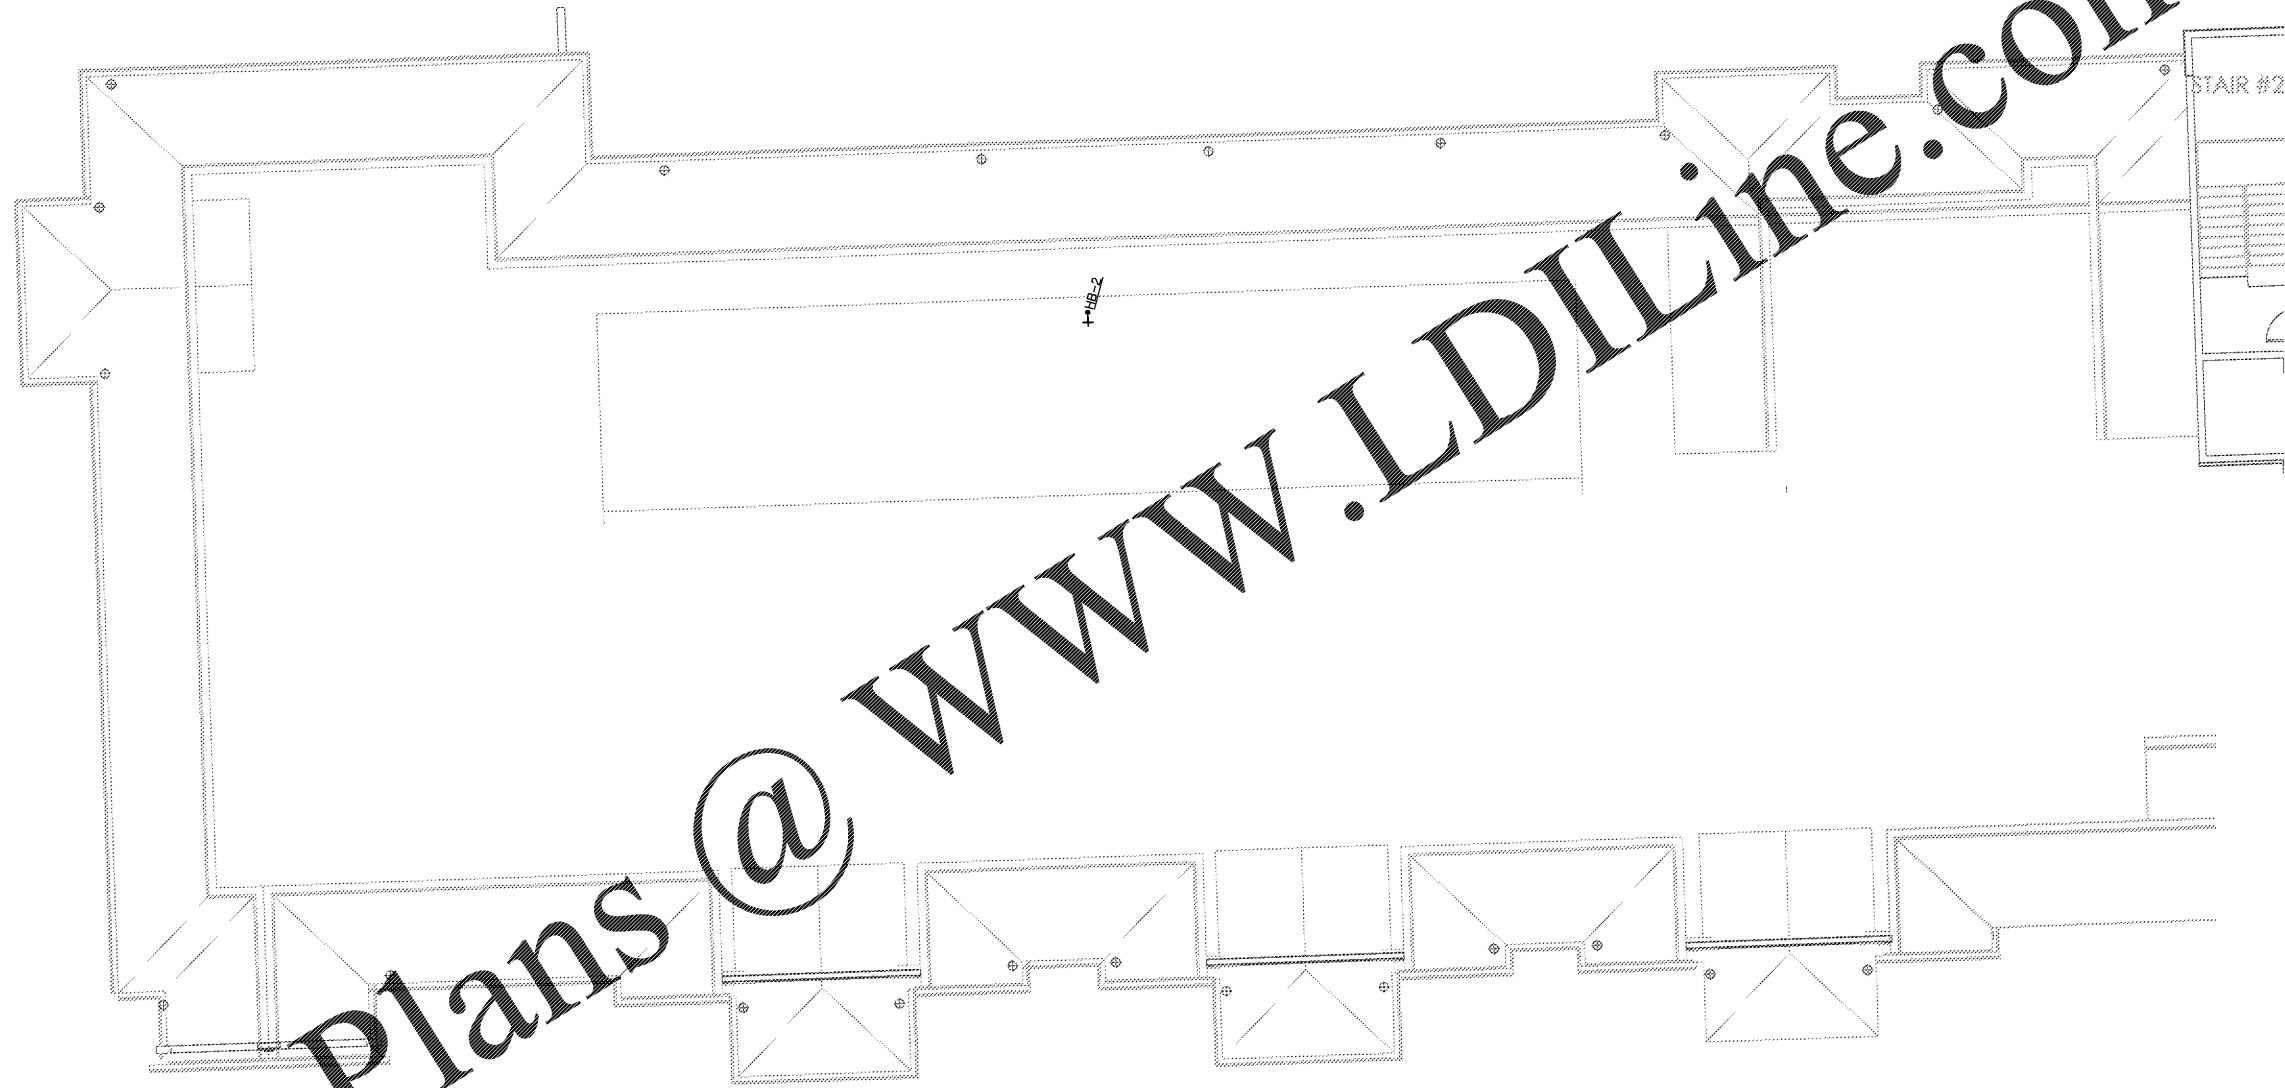

1 PARTIAL BUILDING PLAN A - (04) FOURTH FLOOR - PLUMBING PLAN
 SCALE: 1/8" = 1'-0" 18025-P-BLDG

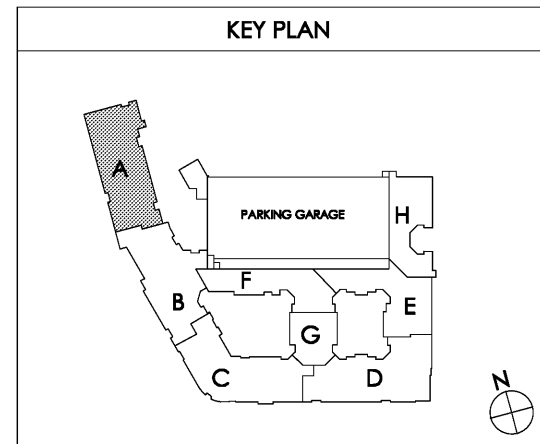


Common North, Prospect, KY



MiGre Engineers LLC
 780 FLORIDA CENTRAL PARKWAY
 SUITE 224
 LONGWOOD, FL 32750
 PH: 407.336.7999
 PROJECT #: 18025

Lyric at Norton Commons
 Prospect, Kentucky
 Bristol Development Group
 381 Mallory Station Rd, Suite 204
 Franklin, TN 37067


charlan • brock
 associates
 architects • planners
 1770 fennell street
 maitland florida 32751-7208
 407.660.8900 • 407.875.5948
 www.cbaarchitects.com

PARTIAL BUILDING
 PLAN A - 4TH FLOOR
 PLUMBING
 PLAN

date: 06-04-2019
 job no: 3789.16
 drawn by: GNIK
 reviewed by: GNIK
 file: 18025-P-BLDG
 issue history:

P1.14A

Charlan Brock Associates, Inc. hereby reserves all copyright, trademark, trade name, design, and other rights in these plans, specifications, and details. These plans, specifications, and details are not to be reproduced, changed or copied in any form or manner whatsoever, nor are they to be assigned to any third party, without first obtaining the express written permission from C.B.A., Inc. All dimensions and notes are in feet and inches unless otherwise specified. The plans and specifications comply with the applicable minimum building codes and the applicable regulatory jurisdiction.