



Order Plans @

WWW.LDILine.com

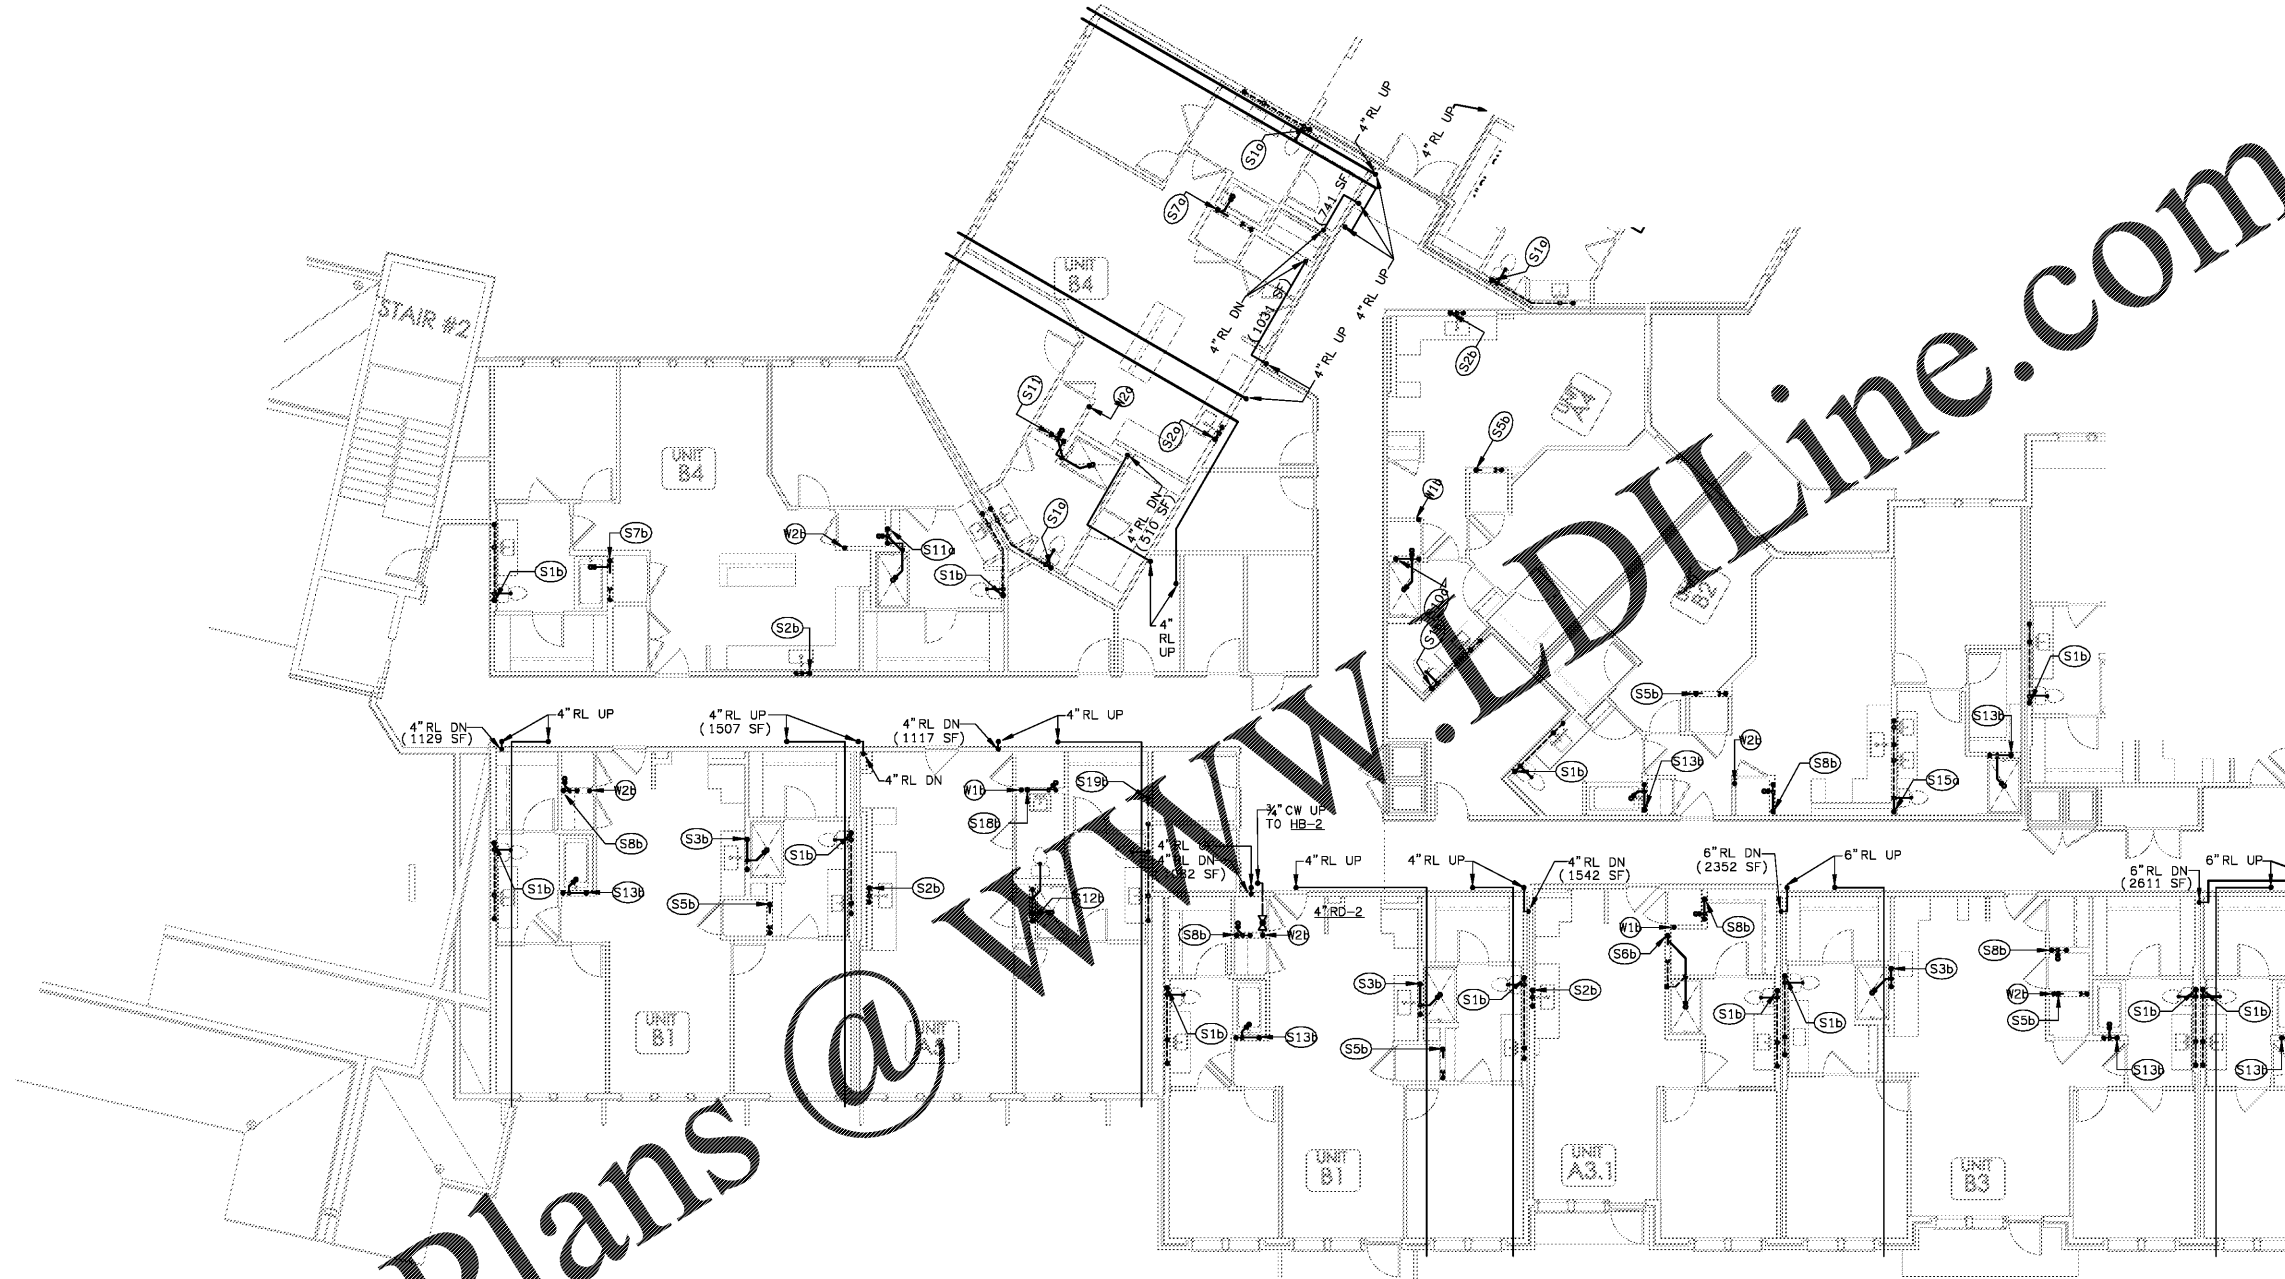

WHOLE SHEET CLOASSED

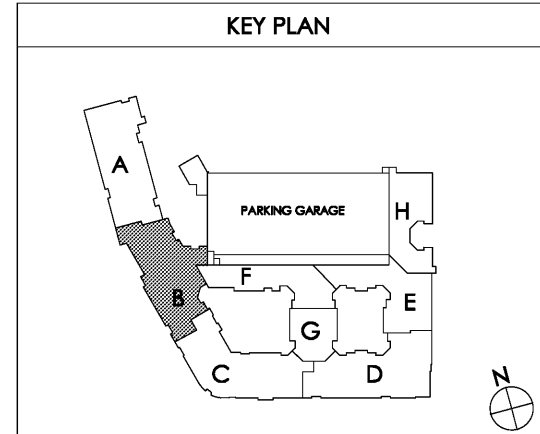

1 PARTIAL BUILDING PLAN B - (04) FOURTH FLOOR - PLUMBING PLAN  
SCALE: 1/8" = 1'-0" 18025-P-BLDG

Common North, Prospect, KY  
**MiGre**  
 Engineers LLC  
 780 FLORIDA CENTRAL PARKWAY  
 SUITE 224  
 LONGWOOD, FL 32750  
 PH: 407.336.7999  
 PROJECT #: 18025

Lyric at Norton Commons  
 Prospect, Kentucky  
 Bristol Development Group  
 381 Mallory Station Rd, Suite 204  
 Franklin, TN 37067

charlan • brock  
 associates  
 architects • planners  
 1770 fennell street  
 maitland florida 32751-7208  
 407.660.8900 ; 407.875.5948  
 www.cbarchitects.com

PARTIAL BUILDING  
 PLAN B - 4TH FLOOR  
 PLUMBING  
 PLAN  
 date: 06-04-2019  
 job no: 3789.16  
 drawn by: GNIK  
 reviewed by: GNIK  
 file: 18025-P-BLDG  
 issue history:  
 07-03-2019  
**P1.14B**

charlan • brock associates, Inc. hereby reserves all copyright, trademark, trade name, and other rights in these plans, ideas, and designs. These plans, ideas, and designs are not to be reproduced, changed or copied in any form or manner whatsoever, nor are they to be assigned to any third party, without first obtaining the express written permission from charlan • brock associates, Inc. All dimensions and notes precedence over scale dimensions.