



www.migre.com

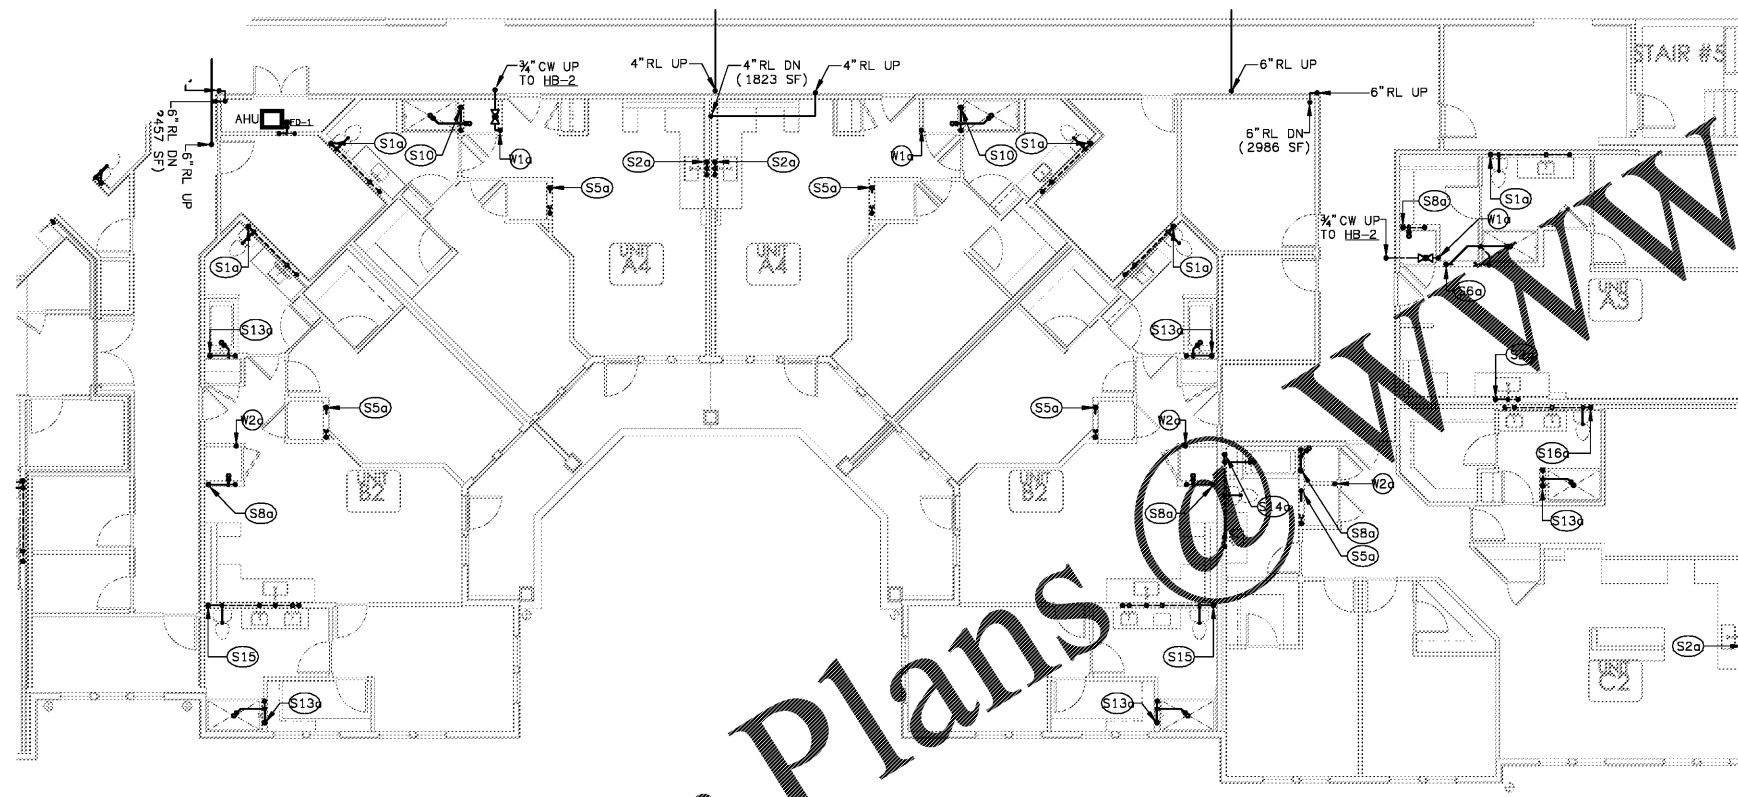

WHILE SHEET IS OPENED

Order Plans @ WWW.LDILine.com

1 PARTIAL BUILDING PLAN H - (04) FOURTH FLOOR - PLUMBING PLAN SCALE 1/8" = 1'-0" 18025-P-BLDG

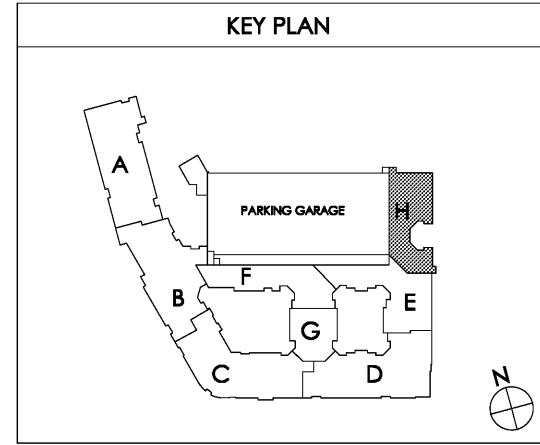

Common North, Prospect, KY  
MIGRE Engineers LLC  
780 FLORIDA CENTRAL PARKWAY SUITE 224 LONGWOOD, FL 32750  
PH: 407.336.7999  
PROJECT #: 18025

Lyric at Norton Commons Prospect, Kentucky  
Bristol Development Group  
381 Malloy Station Rd, Suite 204  
Franklin, TN 37067

charlan • brock associates  
architects • planners  
1770 fennell street  
maitland florida 32751-7208  
407.660.8900 • 407.875.5948  
www.cbaarchitects.com

PARTIAL BUILDING  
PLAN H - 4TH FLOOR  
PLUMBING  
PLAN

date: 06-04-2019  
job no: 3789.16  
drawn by: GNIK  
reviewed by: GNIK  
file: 18025-P-BLDG  
issue history: 07-03-2019

P1.14H

Vertical text on the right edge of the page, likely a project or drawing identifier.