



www.migre.com

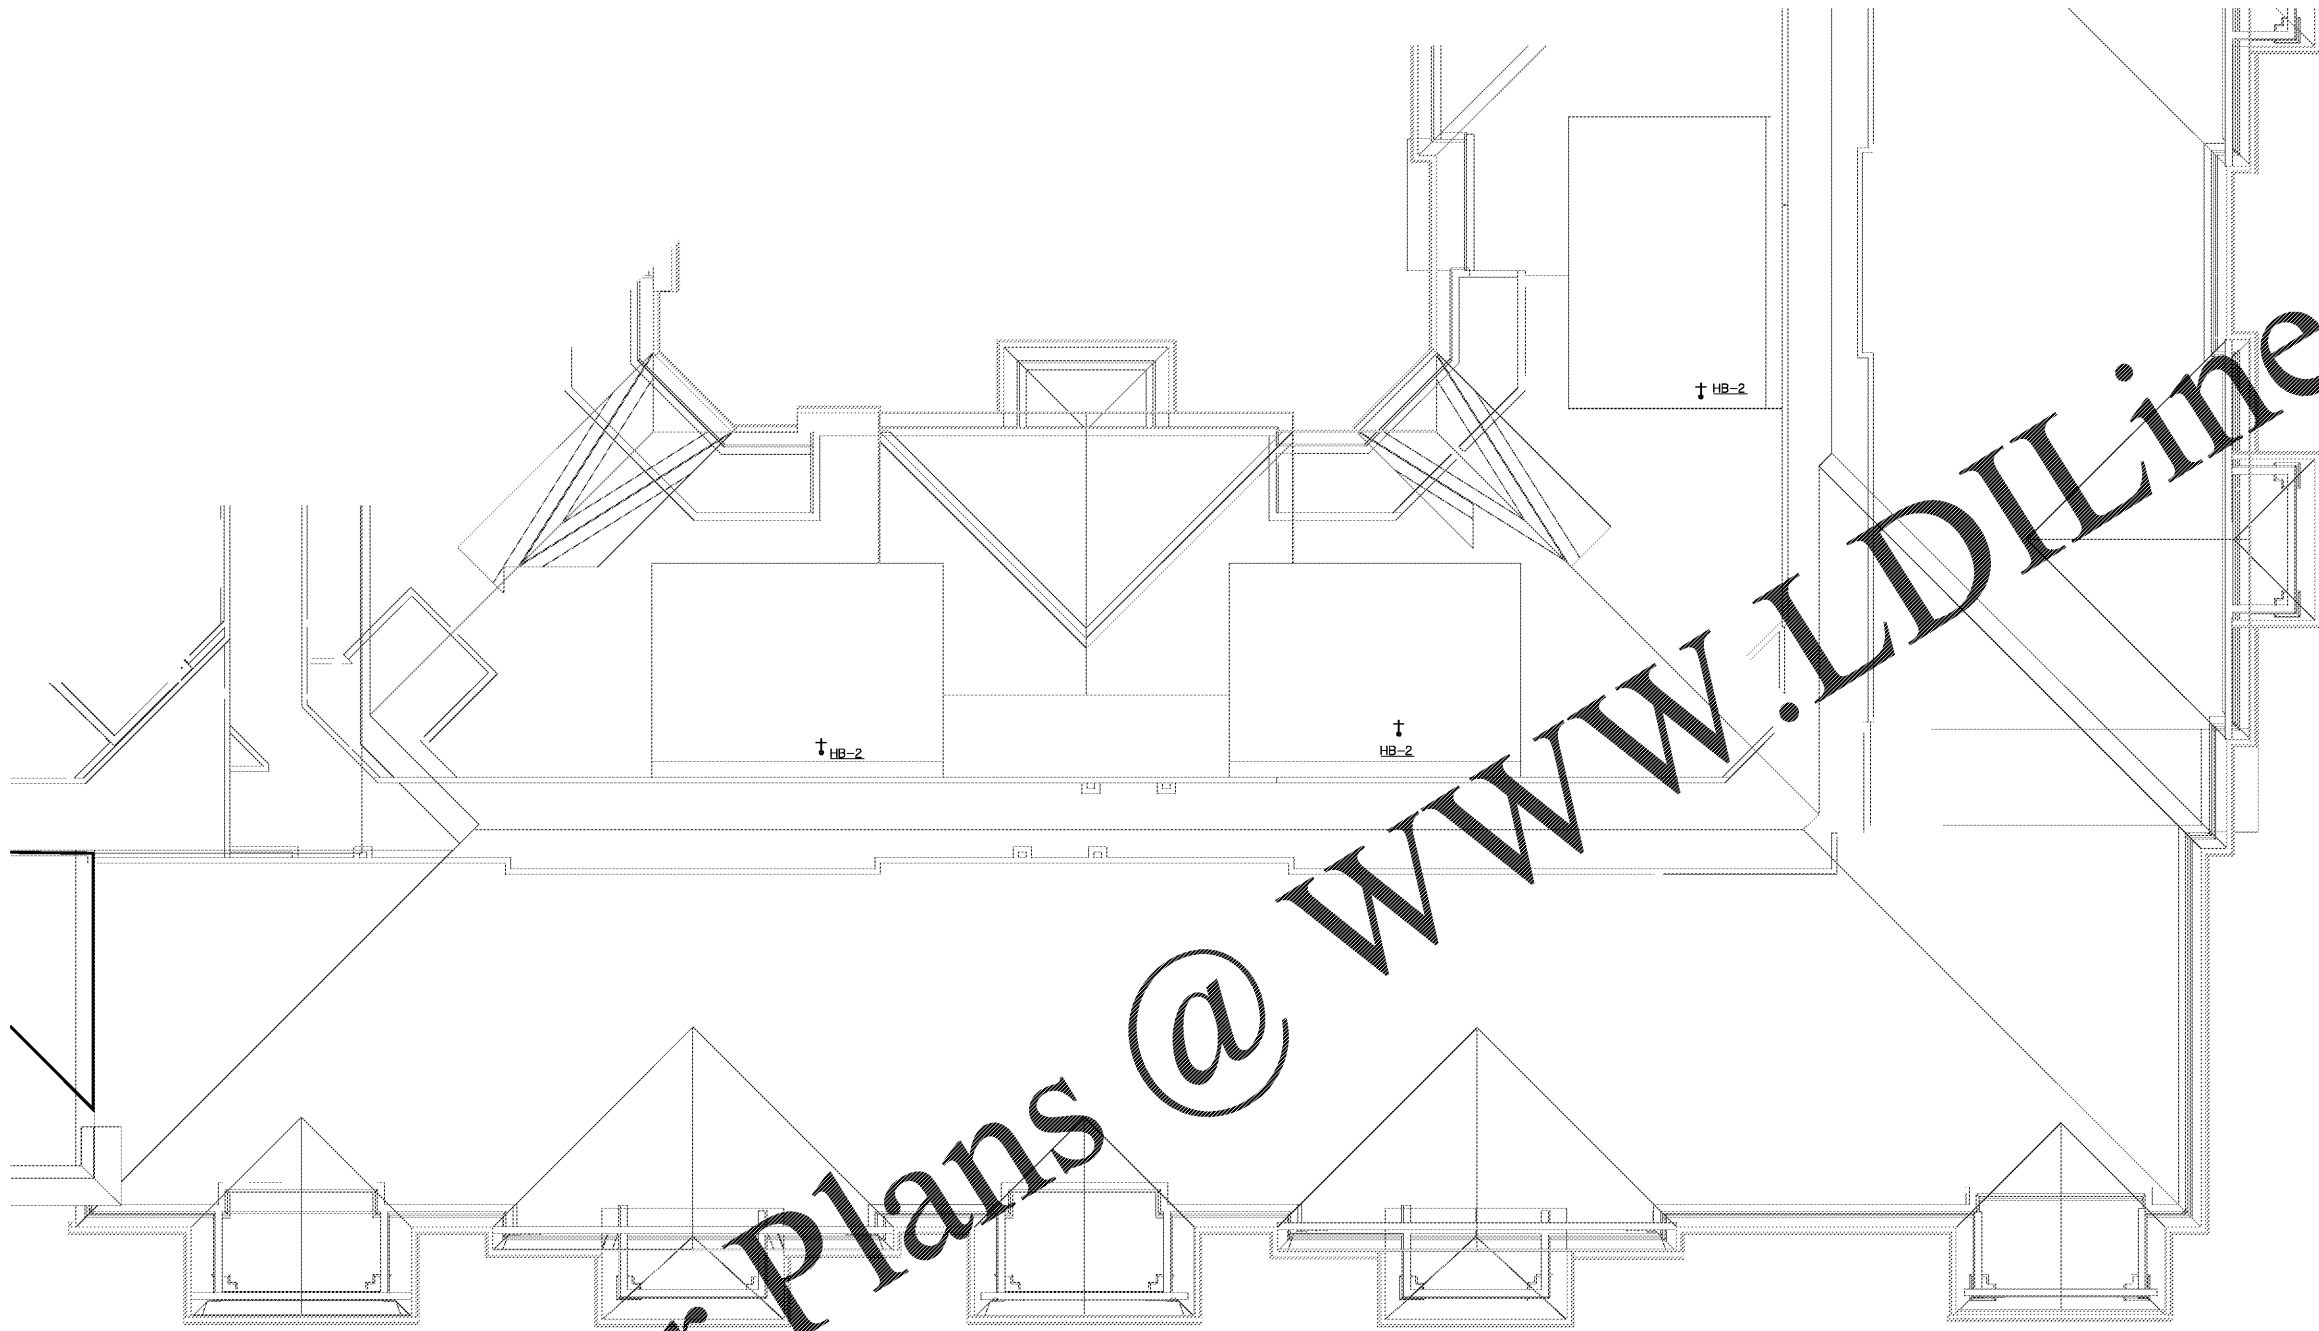

Order Plans @ [www.LDILine.com](http://www.LDILine.com)

1 PARTIAL BUILDING PLAN D - (05) ROOF - PLUMBING PLAN  
SCALE: 1/8" = 1'-0" 18025-P-BLDG

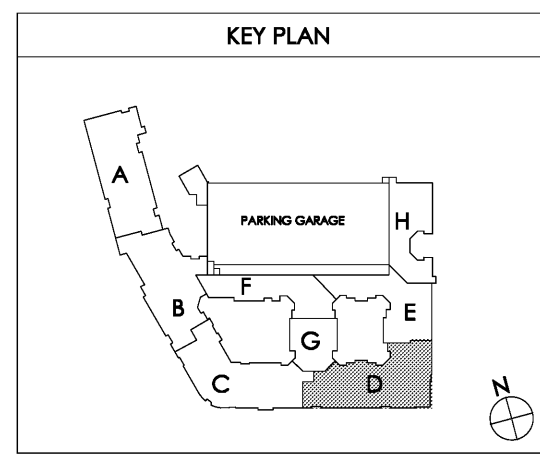

Common North, Prospect, KY  
MIGRE  
Engineers LLC

780 FLORIDA CENTRAL PARKWAY  
SUITE 224  
LONGWOOD, FL 32750  
PH: 407.336.7999  
PROJECT #: 18025

Lyric at Norton Commons  
Prospect, Kentucky  
Bristol Development Group  
381 Malley Station Rd, Suite 204  
Franklin, TN 37067

charlan • brock  
associates  
architects • planners  
1770 fennell street  
maitland florida 32751-7208  
407.660.8900 ; 407.875.5948  
www.cbaarchitects.com

PARTIAL BUILDING  
PLAN D - ROOF  
PLUMBING  
PLAN

date: 06-04-2019  
job no: 3789.16  
drawn by: GNIK  
reviewed by: GNIK  
file: 18025-P-BLDG  
issue history:

P1.15D

Charlan Brock Associates, Inc. hereby reserves all copyright, trademark, and other rights in these plans, ideas, and designs. These plans, ideas, and designs are not to be reproduced, changed or copied in any form or manner whatsoever, nor are they to be assigned to any third party, without first obtaining the express written permission from C.B.A., Inc. All dimensions and notes precedence over scale dimensions.