



Order Plans @ WWW.DILine.com

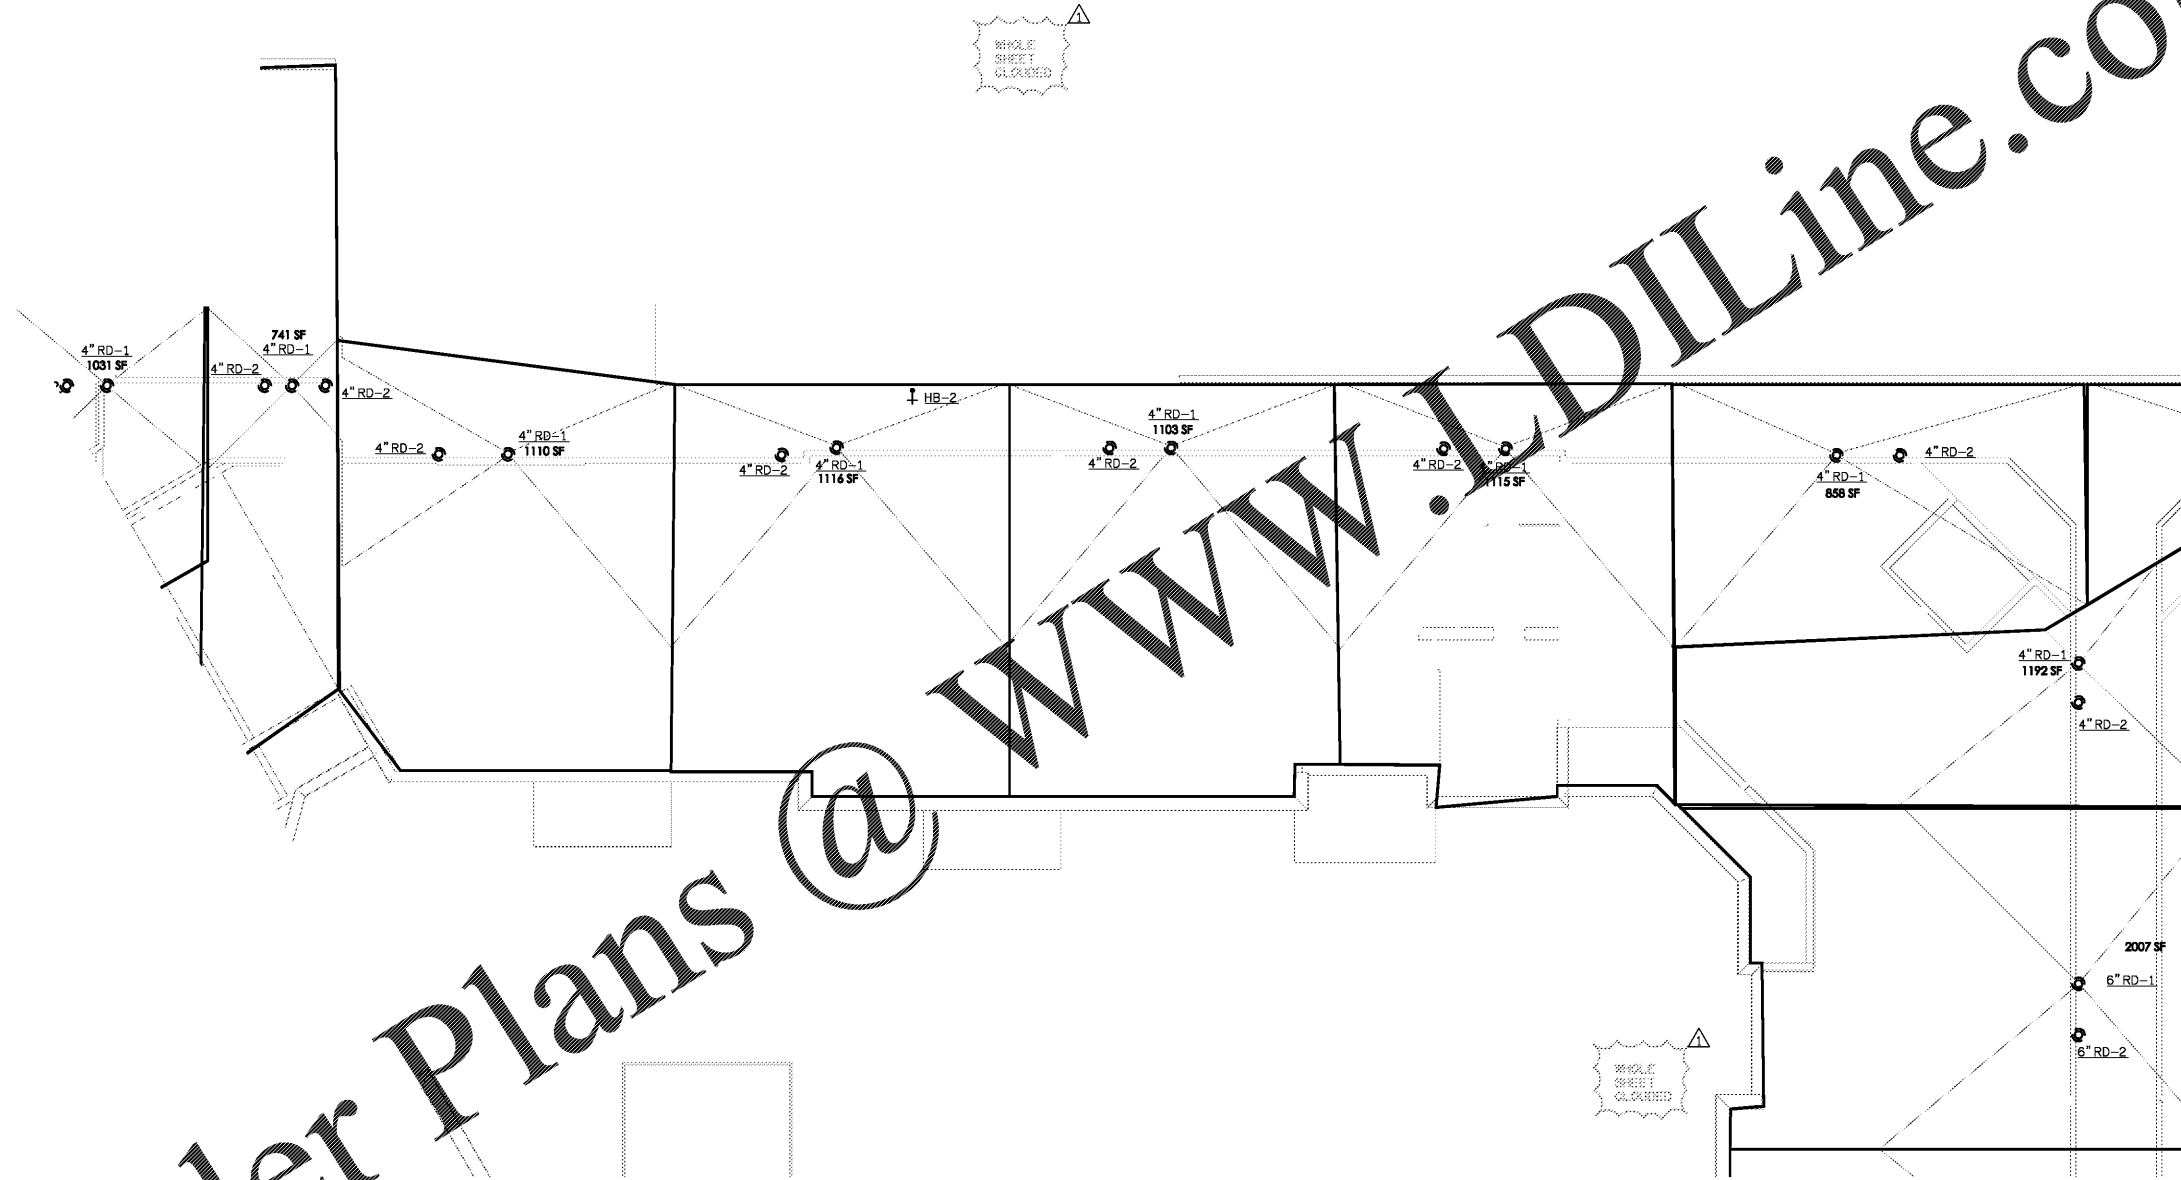

1 PARTIAL BUILDING PLAN F - (05) ROOF - PLUMBING PLAN
 SCALE: 1/8" = 1'-0" 18025-P-BLDG

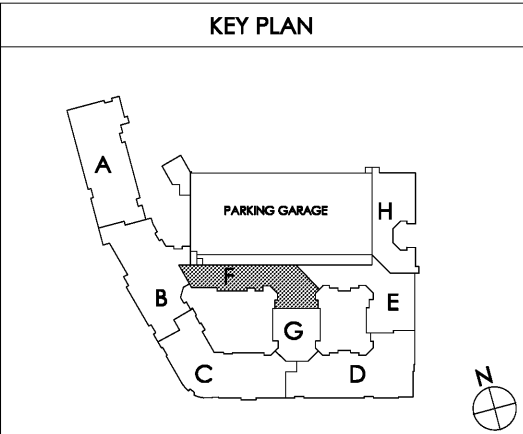

Common North, Prospect, KY

MiGre
 Engineers LLC

780 FLORIDA CENTRAL PARKWAY
 SUITE 224
 LONGWOOD, FL 32750
 PH: 407.336.7999
 PROJECT #: 18025

STATE OF KENTUCKY
 MICHAEL SODANE
 18198
 LICENSED PROFESSIONAL ENGINEER

Lyric at Norton Commons
 Prospect, Kentucky

Bristol Development Group
 381 Mallory Station Rd, Suite 204
 Franklin, TN 37067

charlan • brock
 associates

architects • planners

1770 fennell street
 maitland florida 32751-7208
 407.660.8900 • 407.875.5948
 www.cbaarchitects.com

PARTIAL BUILDING
PLAN F - ROOF
PLUMBING
PLAN

date: 06-04-2019
 job no: 3789.16
 drawn by: GNIK
 reviewed by: GNIK
 file: 18025-P-BLDG
 issue history:
 07-03-2019

P1.15F

Charlan Brock Associates, Inc. hereby reserves its copyright in these plans, ideas, and designs. These plans, ideas, and designs are not to be reproduced, changed or copied in any form or manner whatsoever, nor are they to be assigned to any third party, without first obtaining the express written permission from C.B.A., Inc. All dimensions and floor plan dimensions are in feet unless otherwise noted.