



2 UNIT B2 - PLUMBING PLAN
SCALE: 1/4"=1'-0" 880225-P-UNIT

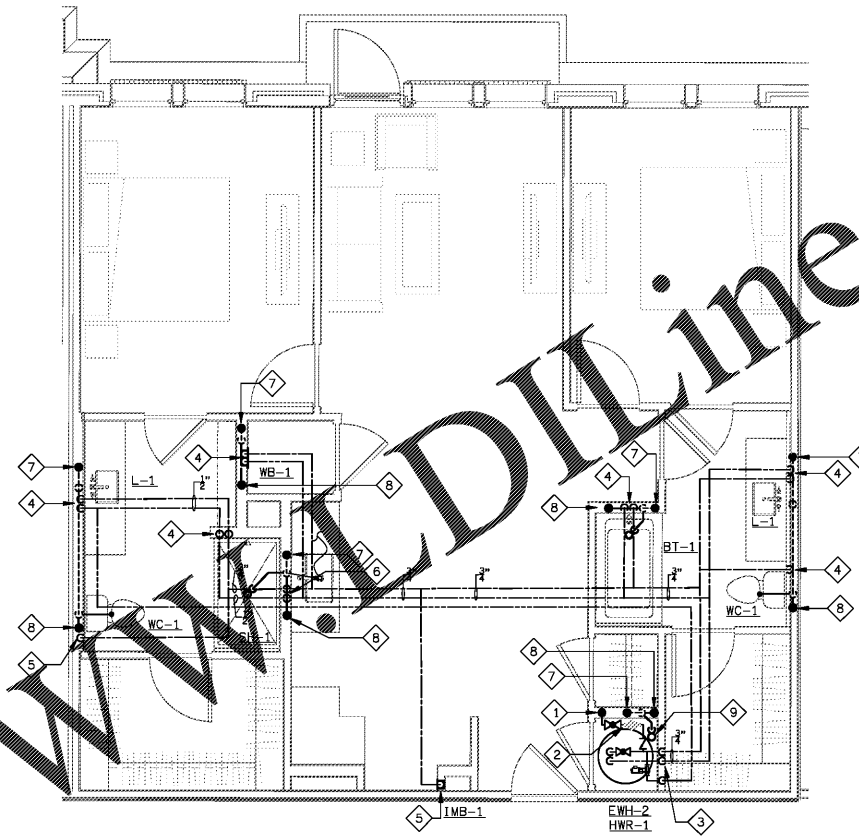

1 UNIT B1 - PLUMBING PLAN
SCALE: 1/4"=1'-0" 880225-P-UNIT

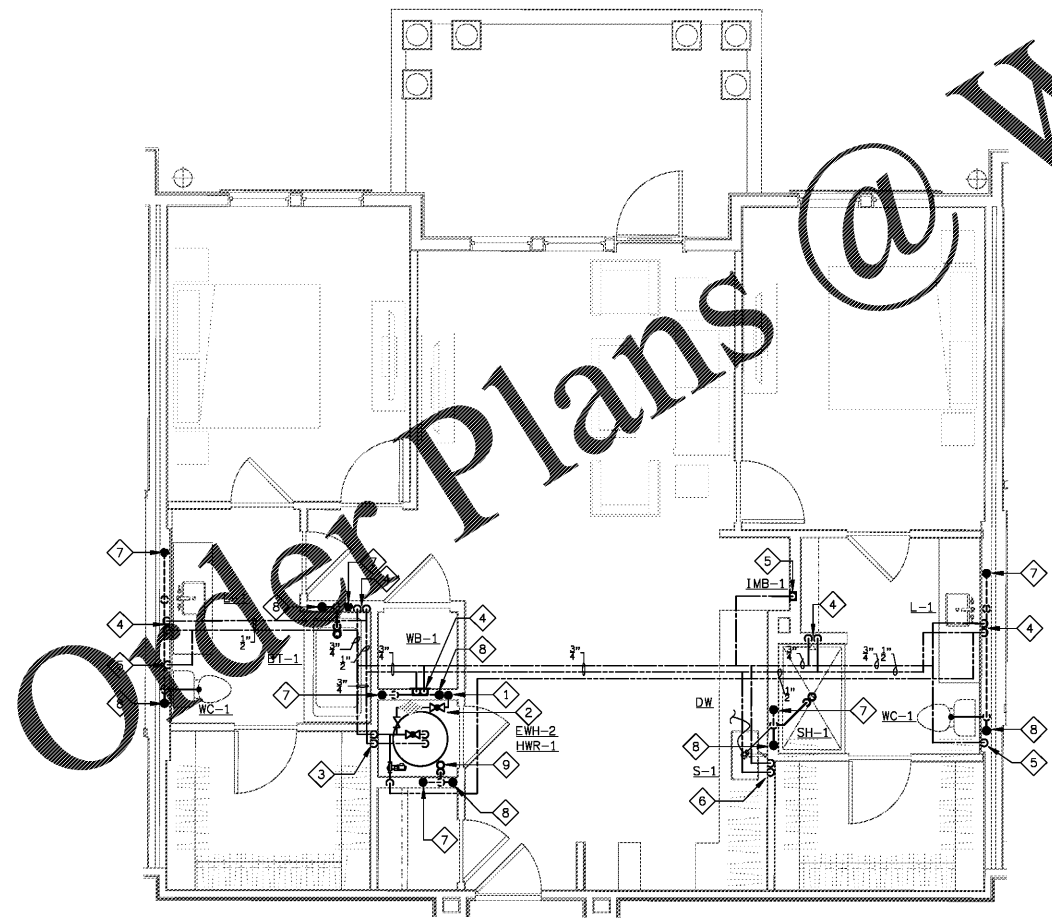


3 UNIT B3 - PLUMBING PLAN
SCALE: 1/4"=1'-0" 880225-P-UNIT

PLAN NOTES

- 1 UNIT'S WATER SERVICE.
- 2 UNITS DOMESTIC WATER SHUT-OFF VALVE, REMOTE READ METER, AND CHECK-VALVE.
- 3 3/4" CW & HW DOWN TO AND UP FROM WATER HEATER.
- 4 1/2" HW & CW PIPING DOWN IN WALL CONNECT TO PLUMBING FIXTURE(S).
- 5 1/2" CW DOWN IN WALL CONNECT TO PLUMBING FIXTURE(S).
- 6 1/2" HW & CW PIPING DOWN IN WALL TO SINK AND DISHWASHER.
- 7 VENT RISER.
- 8 SANITARY RISER.
- 9 2" HUB DRAIN FOR SLOPE PAN AND CONDENSATE. PROVIDE TRAP PRIMING.


WWW.DIline.com

Order Plans @

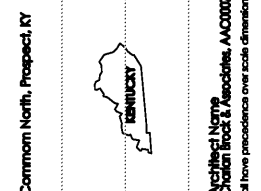

MiGre
Engineers LLC

780 FLORIDA CENTRAL PARKWAY
SUITE 224
LONGWOOD, FL 32750
PH: 407.336.7999
PROJECT #: 18025

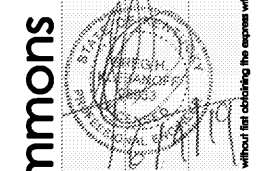

Lyric at Norton Commons
Prospect, Kentucky

Bristol Development Group
381 Mallory Station Rd, Suite 204
Franklin, TN 37067

charlan • brock
associates

architects • planners
1770 fennell street
maitland florida 32751-7208
407.660.8900 • 407.875.9948
www.cbaarchitects.com

UNIT B1, B2, AND B3
PLUMBING
PLAN

date: 06-04-2019
job no: 3789.15
drawn by: GNIK
reviewed by: GNIK
file: 18025-P-UNIT
issue history:

P4.04