


**1 UNIT B5-A PLUMBING PLAN**  
SCALE: 1/4"=1'-0"  
18025-P-UNIT

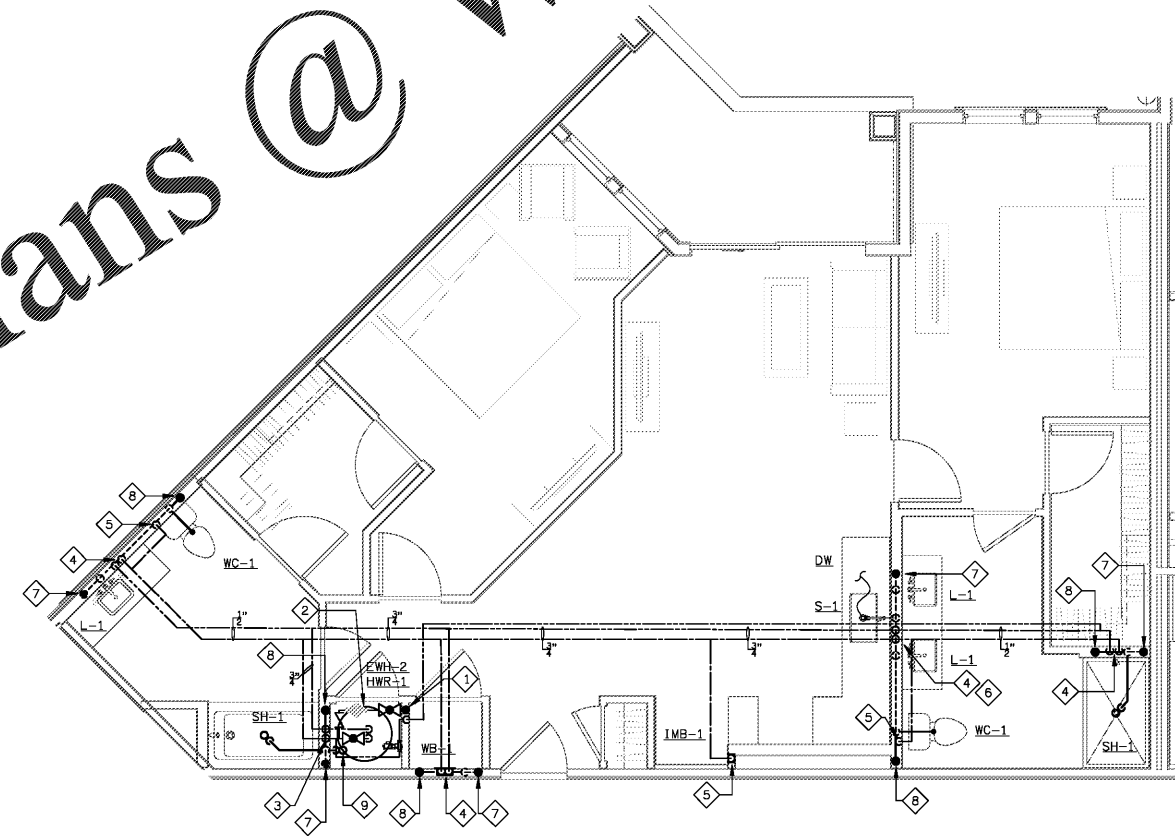

**2 UNIT B6 - PLUMBING PLAN**  
SCALE: 1/4"=1'-0"  
18025-P-UNIT

**PLAN NOTES**

- 1 UNIT'S WATER SERVICE.
- 2 UNITS DOMESTIC WATER SHUT-OFF VALVE, REMOTE READ METER, AND CHECK-VALVE.
- 3 3/4" CW & HW DOWN TO AND UP FROM WATER HEATER.
- 4 1/2" HW & CW PIPING DOWN IN WALL CONNECT TO PLUMBING FIXTURE(S).
- 5 1/2" CW DOWN IN WALL CONNECT TO PLUMBING FIXTURE(S).
- 6 1/2" HW & CW PIPING DOWN IN WALL TO SINK AND DISHWASHER.
- 7 VENT RISER.
- 8 SANITARY RISER.
- 9 2" HUB DRAIN FOR SAFETY PAN AND CONDENSATE. PROVIDE TRAP PRIMER.


Order Plans @ [www.pdfline.com](http://www.pdfline.com)

Common North, Prospect, KY



**MiGre**  
Engineers LLC

780 FLORIDA CENTRAL PARKWAY  
SUITE 224  
LONGWOOD, FL 32750  
PH: 407.336.7999  
PROJECT #: 18025

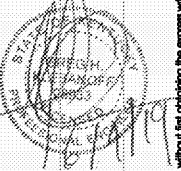

Lyric at Norton Commons  
Prospect, Kentucky

Bristol Development Group  
381 Mallory Station Rd, Suite 204  
Franklin, TN 37067

**charlan • brock**  
associates

architects • planners

1770 fennell street  
maitland florida 32751-7208  
407.660.8900 • 407.875.9948  
www.cbaarchitects.com

**UNIT B5-A AND B6**  
**PLUMBING**  
**PLANS**

date: 06-04-2019  
job no: 3789.15  
drawn by: GNIK  
reviewed by: GNIK  
file: 18025-P-UNIT  
issue history:

**P4.06**