


**SANITARY RISER NOTES**

- 1 SANITARY WASTE PIPING BELOW SLAB. REFER TO PLUMBING BUILDING PLANS FOR CONTINUATION.
- 2 PROVIDE EXPANSION JOINTS EVERY 30 FEET EQUAL TO FERROCEMENT EXPANSION JOINT. PROVIDE ACCESS PANEL WHERE INSTALLED. IN LIEU OF MECHANICAL EXPANSION JOINTS, PROVIDE 45 DEGREE OFFSETS WITHIN 24".
- 3 PROVIDE A MINIMUM OF 10 PIPE DIA. DOWNSTREAM OF STACK BEFORE ANY SOIL OR WASTE CONNECTION.

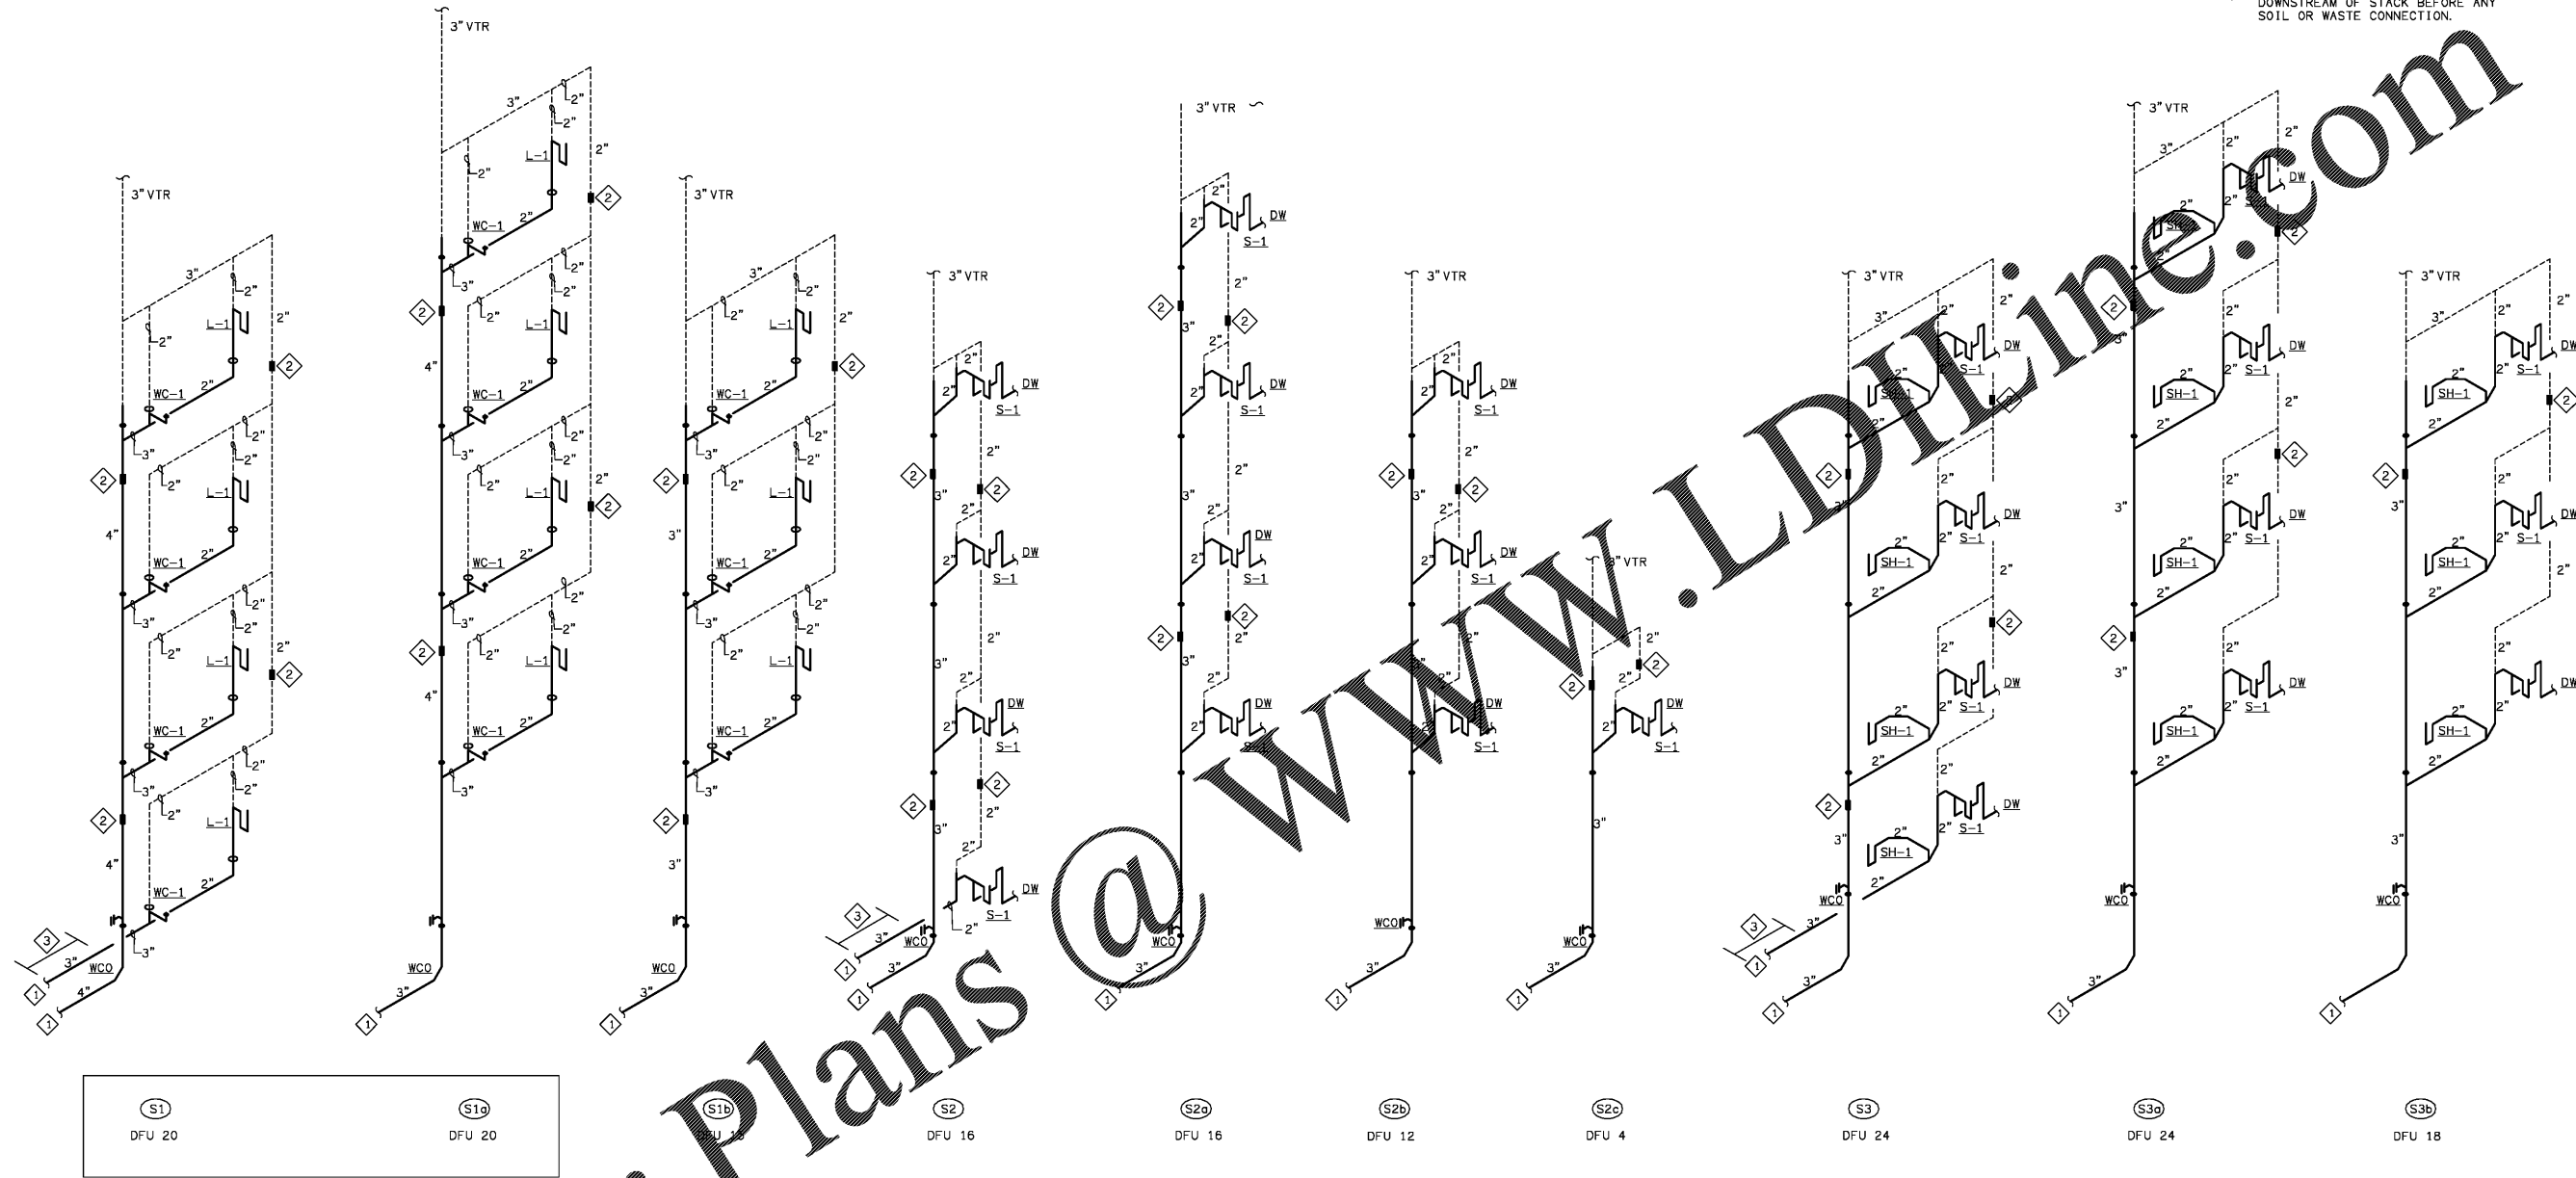


Order Plans @ WWW.LDLINE.COM

Common North, Prospect, KY



780 FLORIDA CENTRAL PARKWAY  
SUITE 224  
LONGWOOD, FL 32750  
PH: 407.336.7999  
PROJECT #: 18025

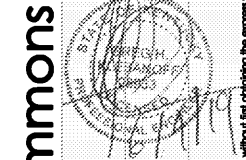

**Lyric at Norton Commons**  
Prospect, Kentucky

Bristol Development Group  
381 Mallory Station Rd, Suite 204  
Franklin, TN 37067



architects • planners  
1770 fennell street  
maitland florida 32751-7208  
407.660.8900 • 407.875.9948  
www.cbaarchitects.com

**PLUMBING**  
**SCHEDULES**  
**AND DETAILS**

date: 06-04-2019  
job no: 3789.15  
drawn by: GNIK  
reviewed by: GNIK  
file: 18025-P-SCHS  
issue history:

charlan brock associates, inc. hereby reserves its copyright in, and grants no license, express or implied, in any drawings, specifications, or other documents prepared by it, or its employees, independent contractors, or other persons, for reproduction, distribution, or use in any form or by any means, without the prior written consent of charlan brock associates, inc. All drawings, specifications, and other documents are the property of charlan brock associates, inc. and shall remain the confidential property of charlan brock associates, inc. until they are otherwise indicated.