



**SANITARY RISER NOTES**

- 1 SANITARY WASTE PIPING BELOW SLAB. REFER TO PLUMBING BUILDING PLANS FOR CONTINUATION.
- 2 PROVIDE EXPANSION JOINTS EVERY 30 FEET EQUAL TO FERROCEMENT EXPANSION JOINT. PROVIDE ACCESS PANEL WHERE INSTALLED. IN LIEU OF MECHANICAL EXPANSION JOINTS, PROVIDE 90 DEGREE OFFSETS WITH 24".
- 3 PROVIDE A MINIMUM OF 12" PIPE RUN DOWNSTREAM OF STACK BEFORE ANY SOIL OR WASTE CONNECTION.

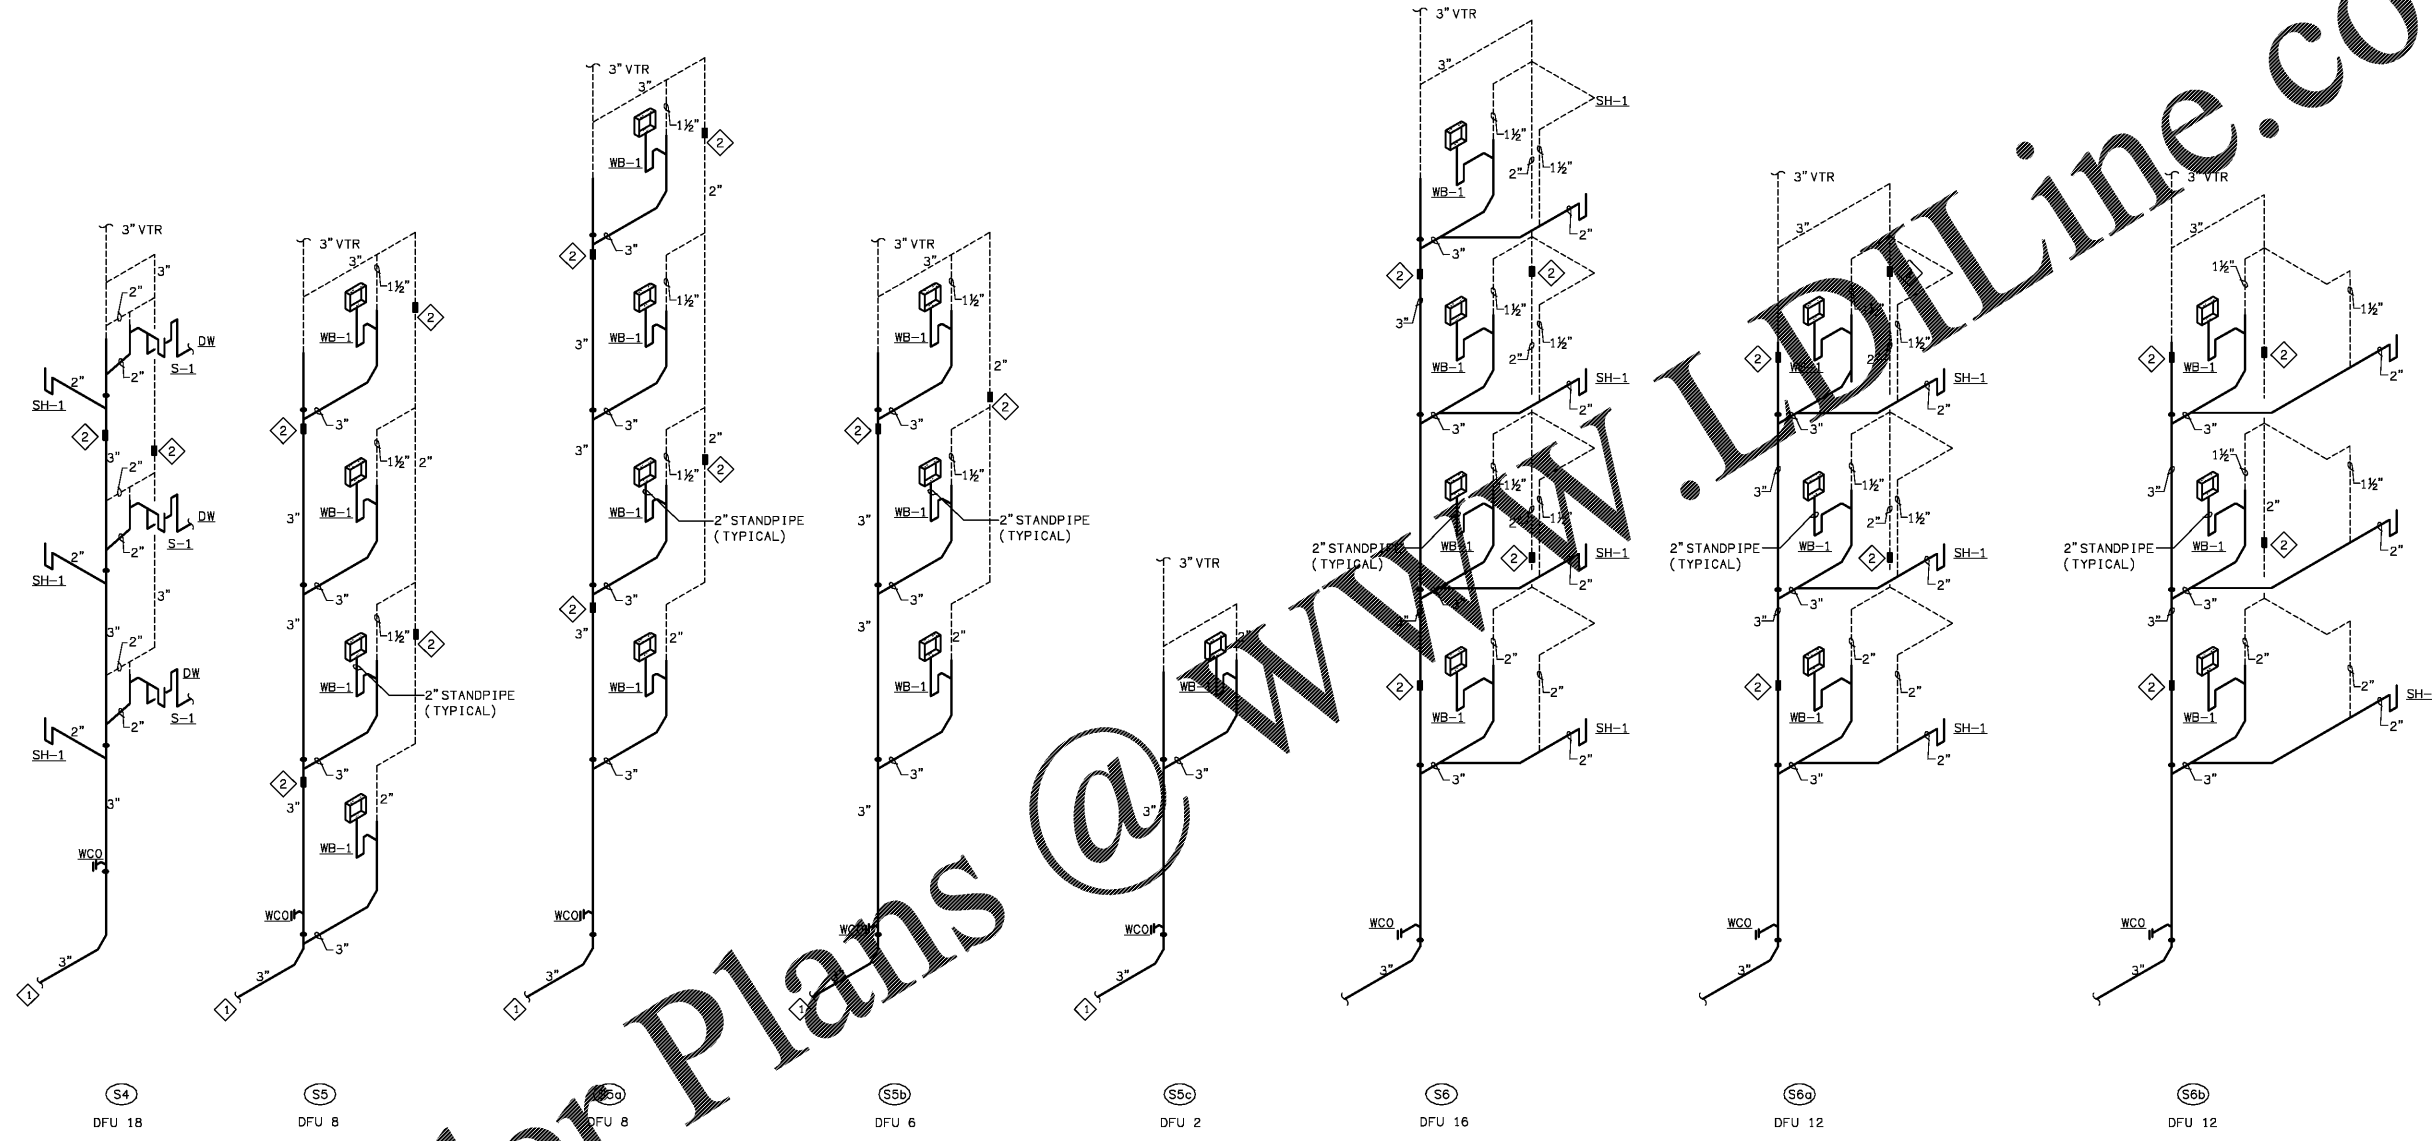

Order Plans

@WWW.IDIOnline.com

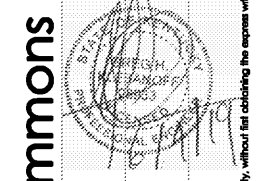

**Lyric at Norton Commons**  
 Prospect, Kentucky  
 Bristol Development Group  
 381 Malley Station Rd, Suite 204  
 Franklin, TN 37067

**charlan • brock**  
 associates  
 architects • planners  
 1770 fennell street  
 maitland florida 32751-7208  
 407.660.8900 • 407.875.9948  
 www.cbaarchitects.com

**PLUMBING**  
**SCHEDULES**  
**AND DETAILS**

date: 06-04-2019  
 job no: 3789.15  
 drawn by: GNIK  
 reviewed by: GNIK  
 file: 18025-P-SCHSDS  
 issue history:

This drawing is the property of MiGre Engineers LLC. It is to be used only for the project and location specified. Any reproduction, copying, or reuse of this drawing without the written permission of MiGre Engineers LLC is strictly prohibited. The user assumes all liability for any errors or omissions in this drawing. MiGre Engineers LLC is not responsible for any damage or injury resulting from the use of this drawing. © 2019 MiGre Engineers LLC. A40000796