

SANITARY RISER NOTES


- ① SANITARY WASTE PIPING BELOW SLAB. REFER TO PLUMBING BUILDING PLANS FOR CONTINUATION.
- ② PROVIDE EXPANSION JOINTS EVERY 30 FEET EQUAL TO FERROCEMENT EXPANSION JOINT. PROVIDE ACCESS PANEL WHERE INSTALLED. IN LIEU OF MECHANICAL EXPANSION JOINTS, PROVIDE 45 DEGREE OFFSETS WITHIN 24".
- ③ PROVIDE A MINIMUM OF 10 PIPE DIA. DOWNSTREAM OF STACK BEFORE ANY SOIL OR WASTE CONNECTION.

Common North, Prospect, KY



MiGre
Engineers LLC

780 FLORIDA CENTRAL PARKWAY
SUITE 224
LONGWOOD, FL 32750
PH: 407.336.7999
PROJECT #: 18025

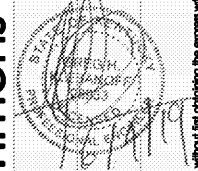

Lyric at Norton Commons
Prospect, Kentucky

Bristol Development Group
381 Mallory Station Rd, Suite 204
Franklin, TN 37067




architects • planners
1770 fennell street
maitland florida 32751-7208
407.660.8900 • 407.875.9948
www.cbaarchitects.com

PLUMBING
SCHEDULES
AND DETAILS

date: 06-04-2019
job no: 3789.15
drawn by: GNIK
reviewed by: GNIK
file: 18025-P-SCHEDS
issue history:

P6.06

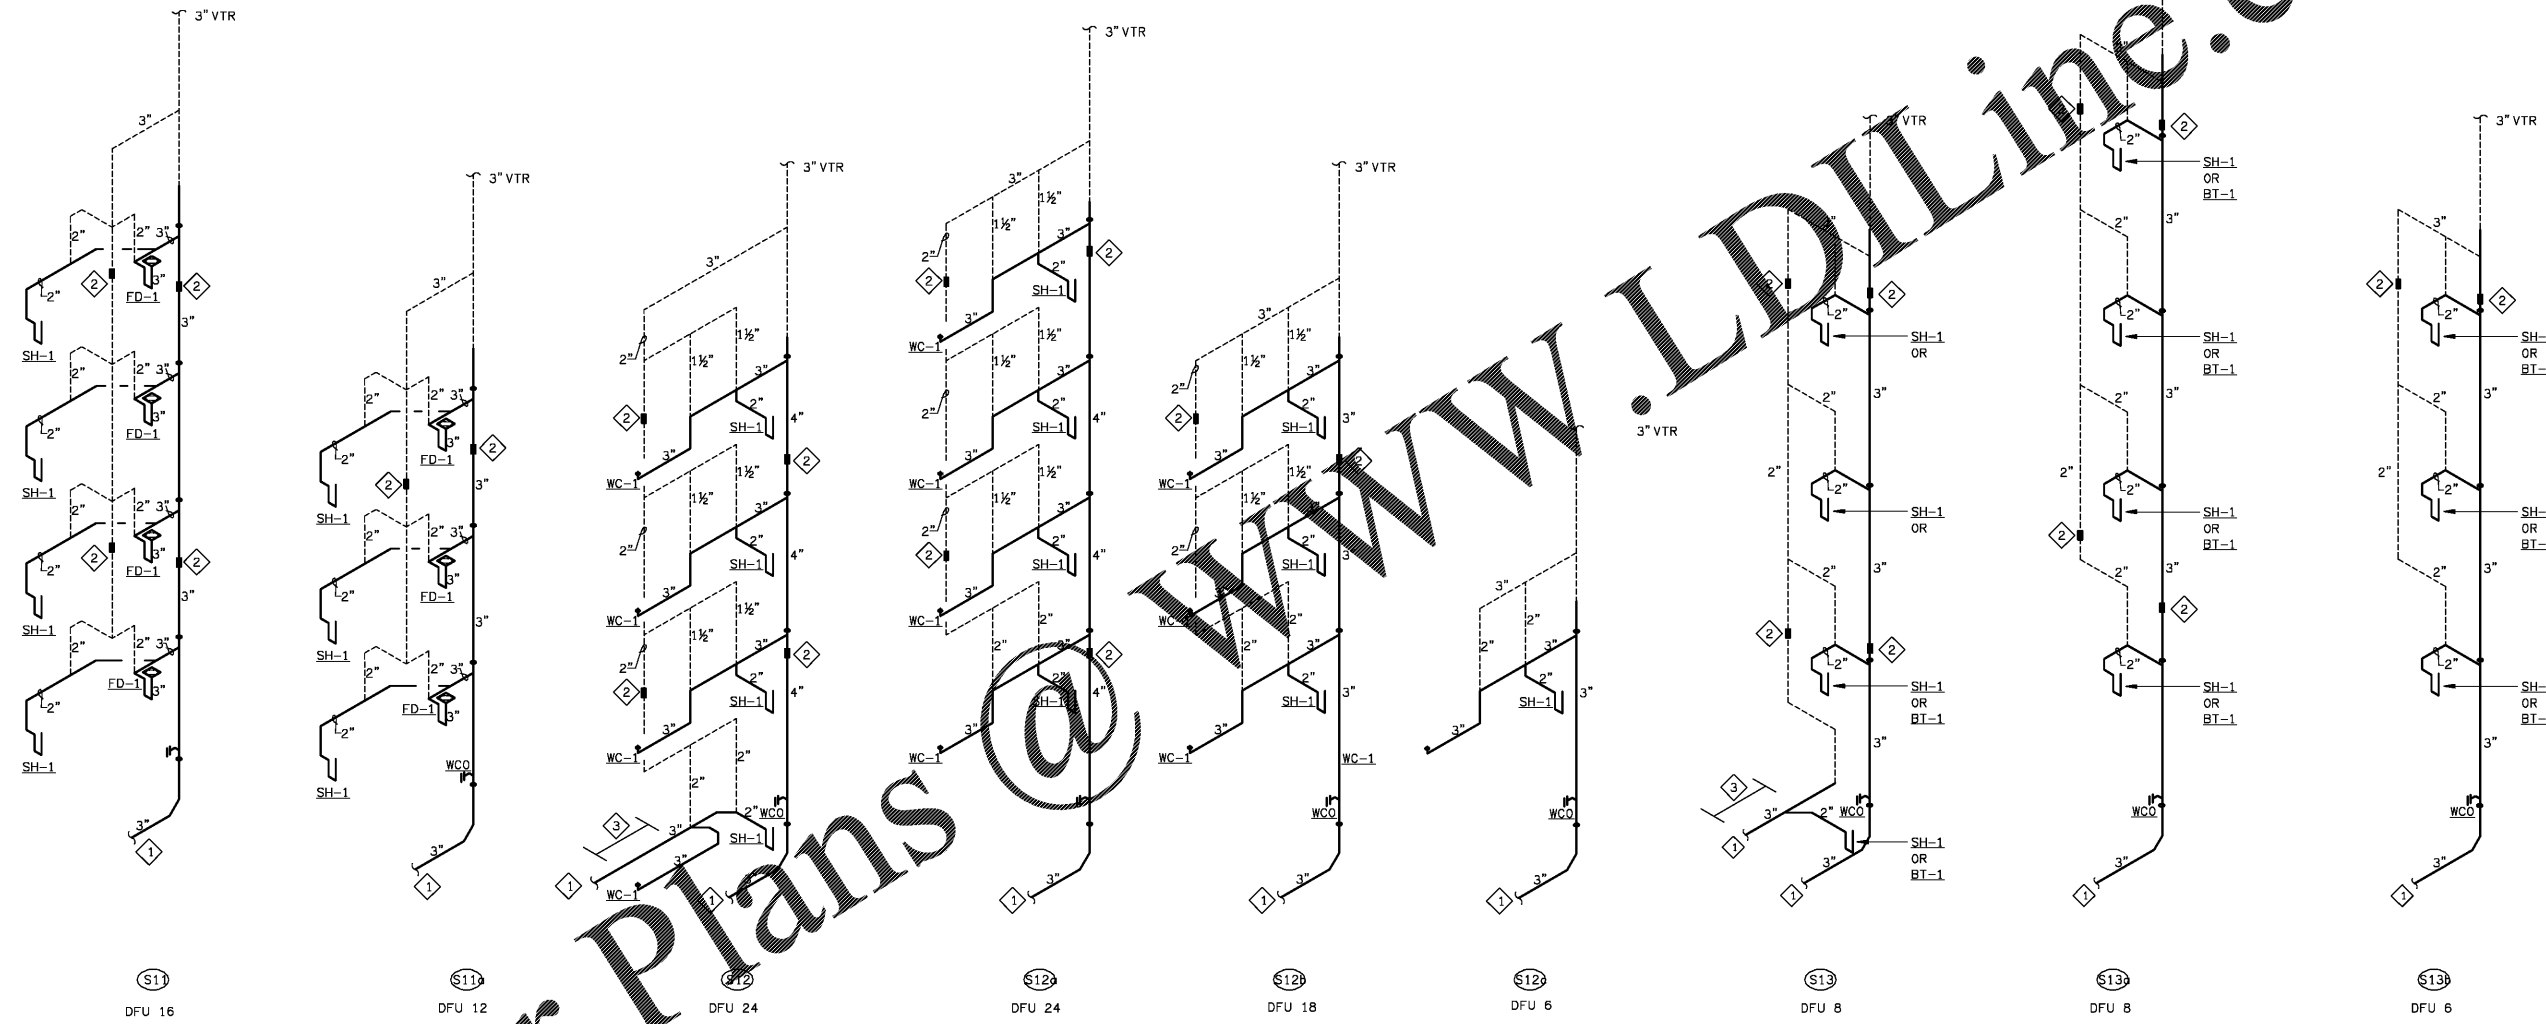

WWW.LDILine.com

Order Plans @