


SANITARY RISER NOTES

- 1 SANITARY WASTE PIPING BELOW SLAB. REFER TO PLUMBING BUILDING PLANS FOR CONTINUATION.
- 2 PROVIDE EXPANSION JOINTS EVERY 30 FEET EQUAL TO FERROCEMENT EXPANSION JOINT. PROVIDE ACCESS PANEL WHERE INSTALLED. IN LIEU OF MECHANICAL EXPANSION JOINTS, PROVIDE 45 DEGREE OFFSETS WITHIN 24".
- 3 PROVIDE A MINIMUM OF 10 PIPE DIA. DOWNSTREAM OF STACK BEFORE ANY SOIL OR WASTE CONNECTION.

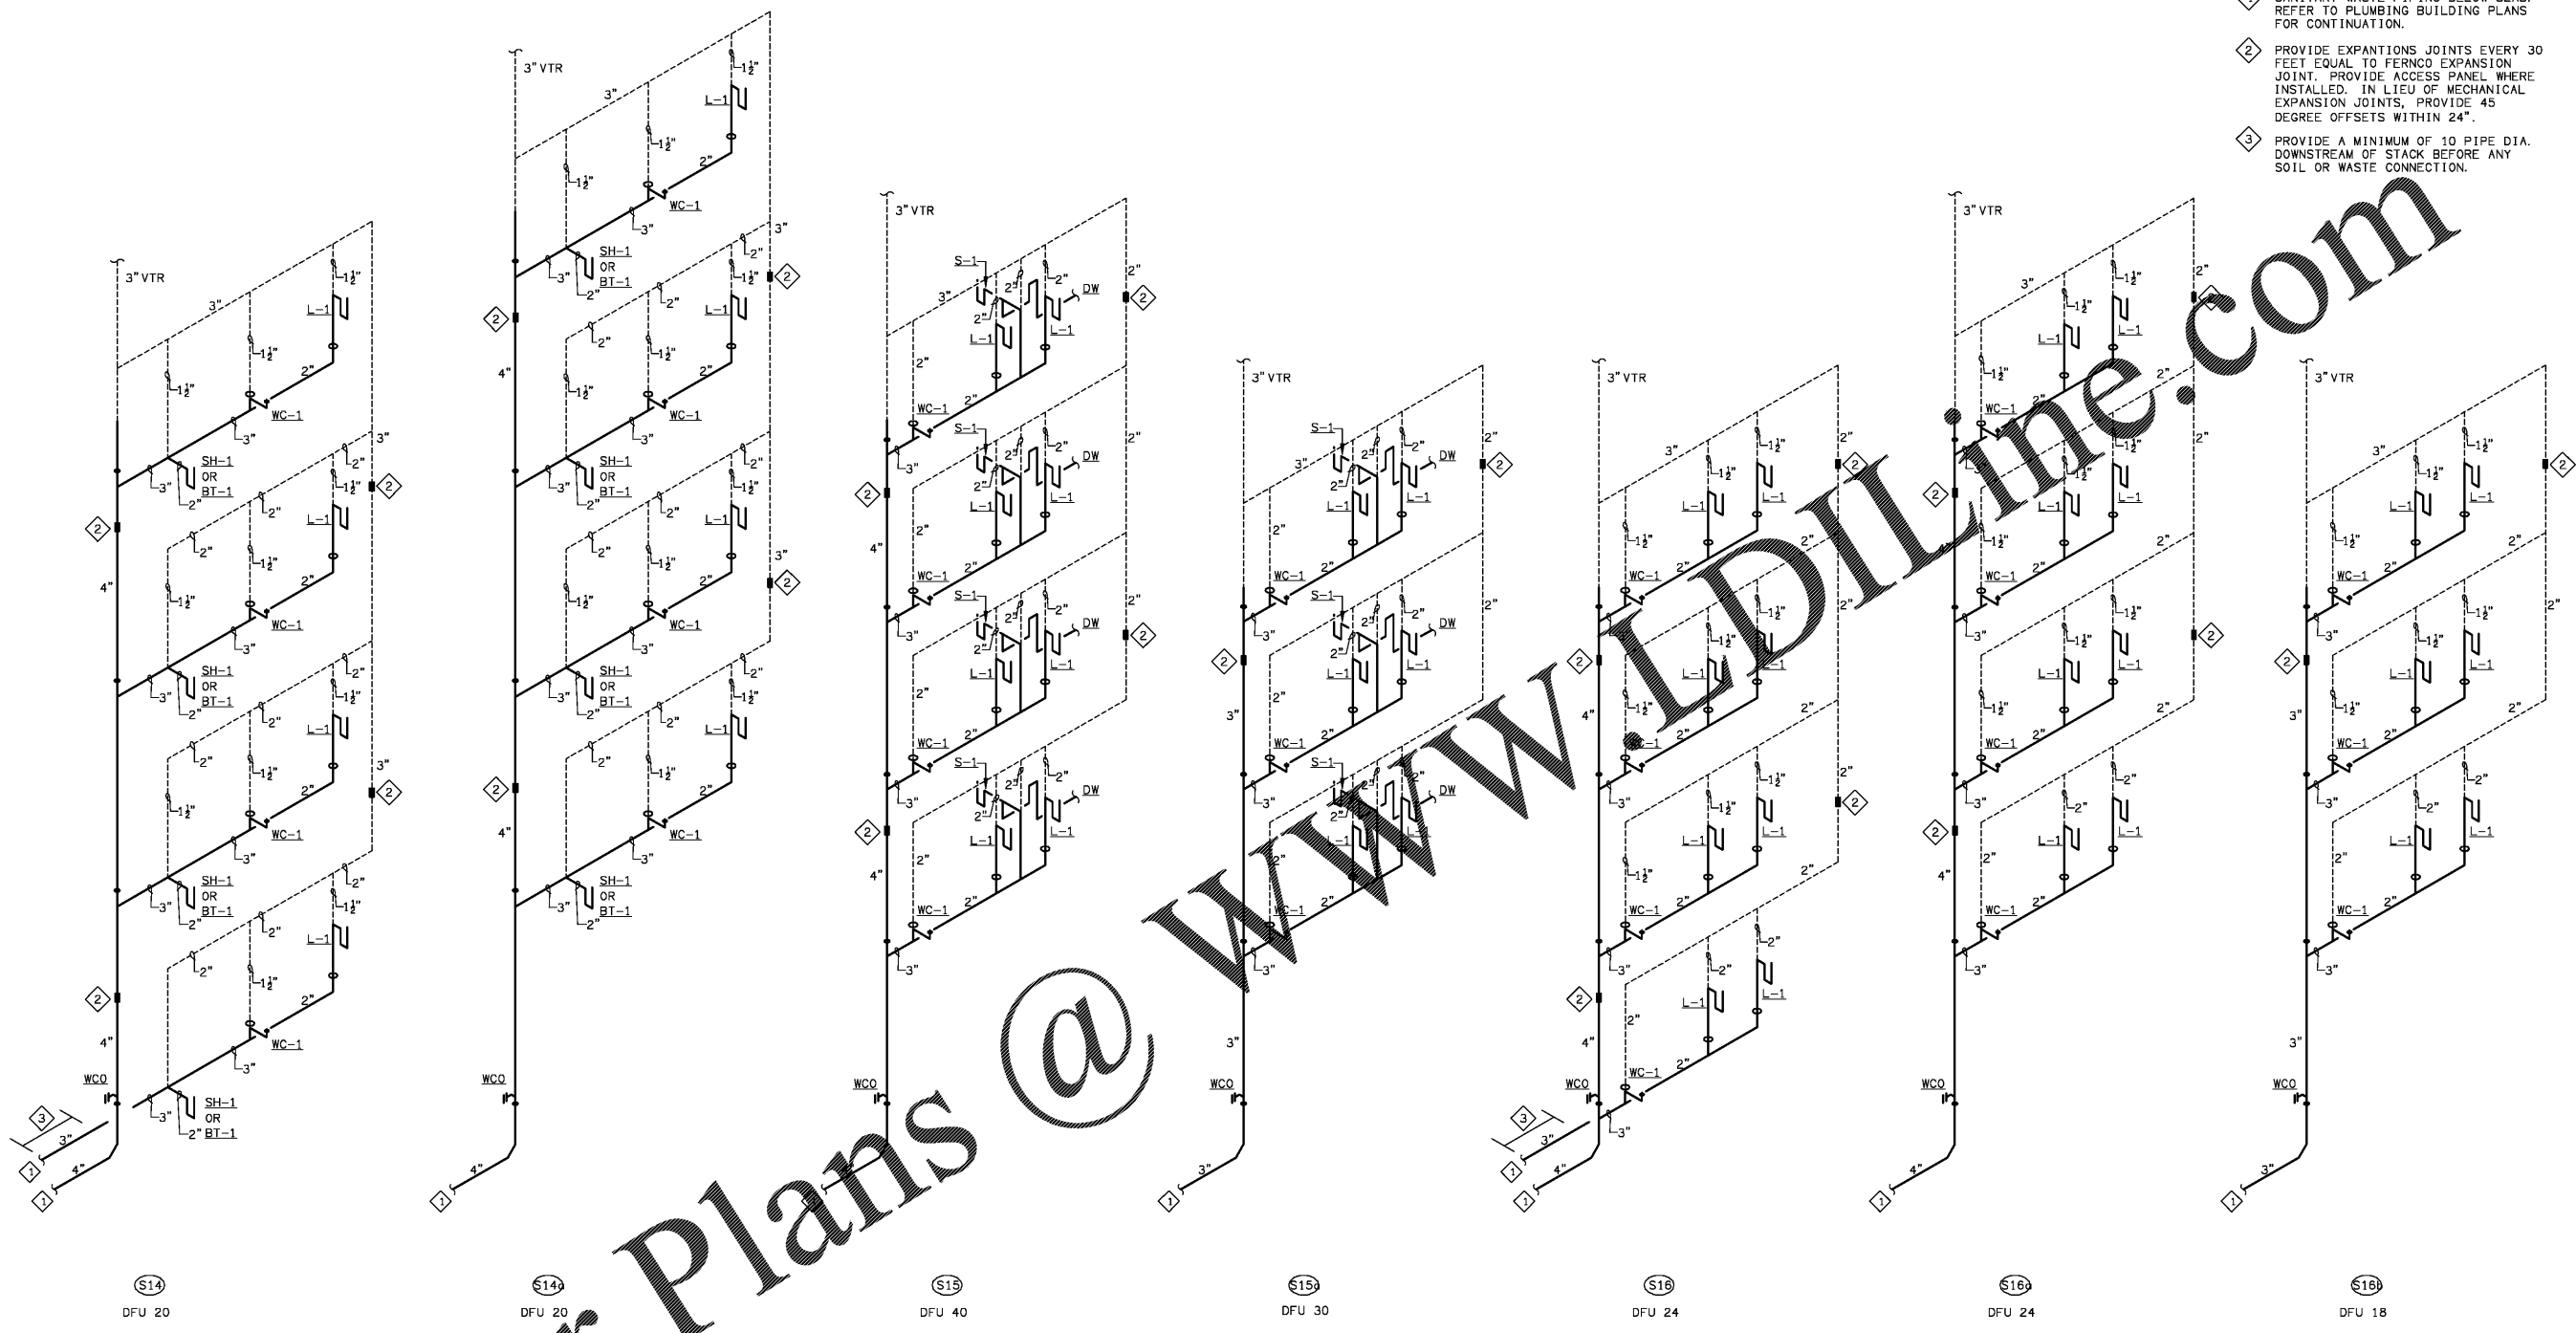

Order Plans @ WWW.DIYLINE.COM



MiGre Engineers LLC
 780 FLORIDA CENTRAL PARKWAY
 SUITE 224
 LONGWOOD, FL 32750
 PH: 407.336.7999
 PROJECT #: 18025



Lyric at Norton Commons
 Prospect, Kentucky

charlan • brock associates
 architects • planners
 1770 fennell street
 maitland florida 32751-7208
 407.660.8900 • 407.875.9948
 www.cbaarchitects.com

PLUMBING SCHEDULES AND DETAILS

date: 06-04-2019
 job no: 3789.15
 drawn by: GNIK
 reviewed by: GNIK
 file: 18025-P-SCH18S
 issue history:

MiGre Engineers, LLC - 18025-P-SCH18S.dwg - P6.07 - Plumber: T. Manning, June 04, 2019 09:19:00 AM

charlan • brock associates, Inc. hereby reserves its copyright in, and other rights in, these plans, designs, and details. These plans, designs, and details are not to be reproduced, changed or copied in any form or manner whatsoever, nor are they to be assigned to any third party, without first obtaining the express written permission from C.B.A., Inc. within dimensions and have precedence over scale dimensions. To the best of the engineer's knowledge, the plans and specifications comply with the applicable minimum building codes and the applicable industry standards.