



SANITARY RISER NOTES

- 1 SANITARY WASTE PIPING BELOW SLAB. REFER TO PLUMBING BUILDING PLANS FOR CONTINUATION.
- 2 PROVIDE EXPANSION JOINTS EVERY 30 FEET EQUAL TO FERROCEMENT EXPANSION JOINT. PROVIDE ACCESS PANEL WHERE INSTALLED. IN LIEU OF MECHANICAL EXPANSION JOINTS, PROVIDE 45 DEGREE OFFSETS WITHIN 24".
- 3 PROVIDE A MINIMUM OF 10 PIPE DIA. DOWNSTREAM OF STACK BEFORE ANY SOIL OR WASTE CONNECTION.

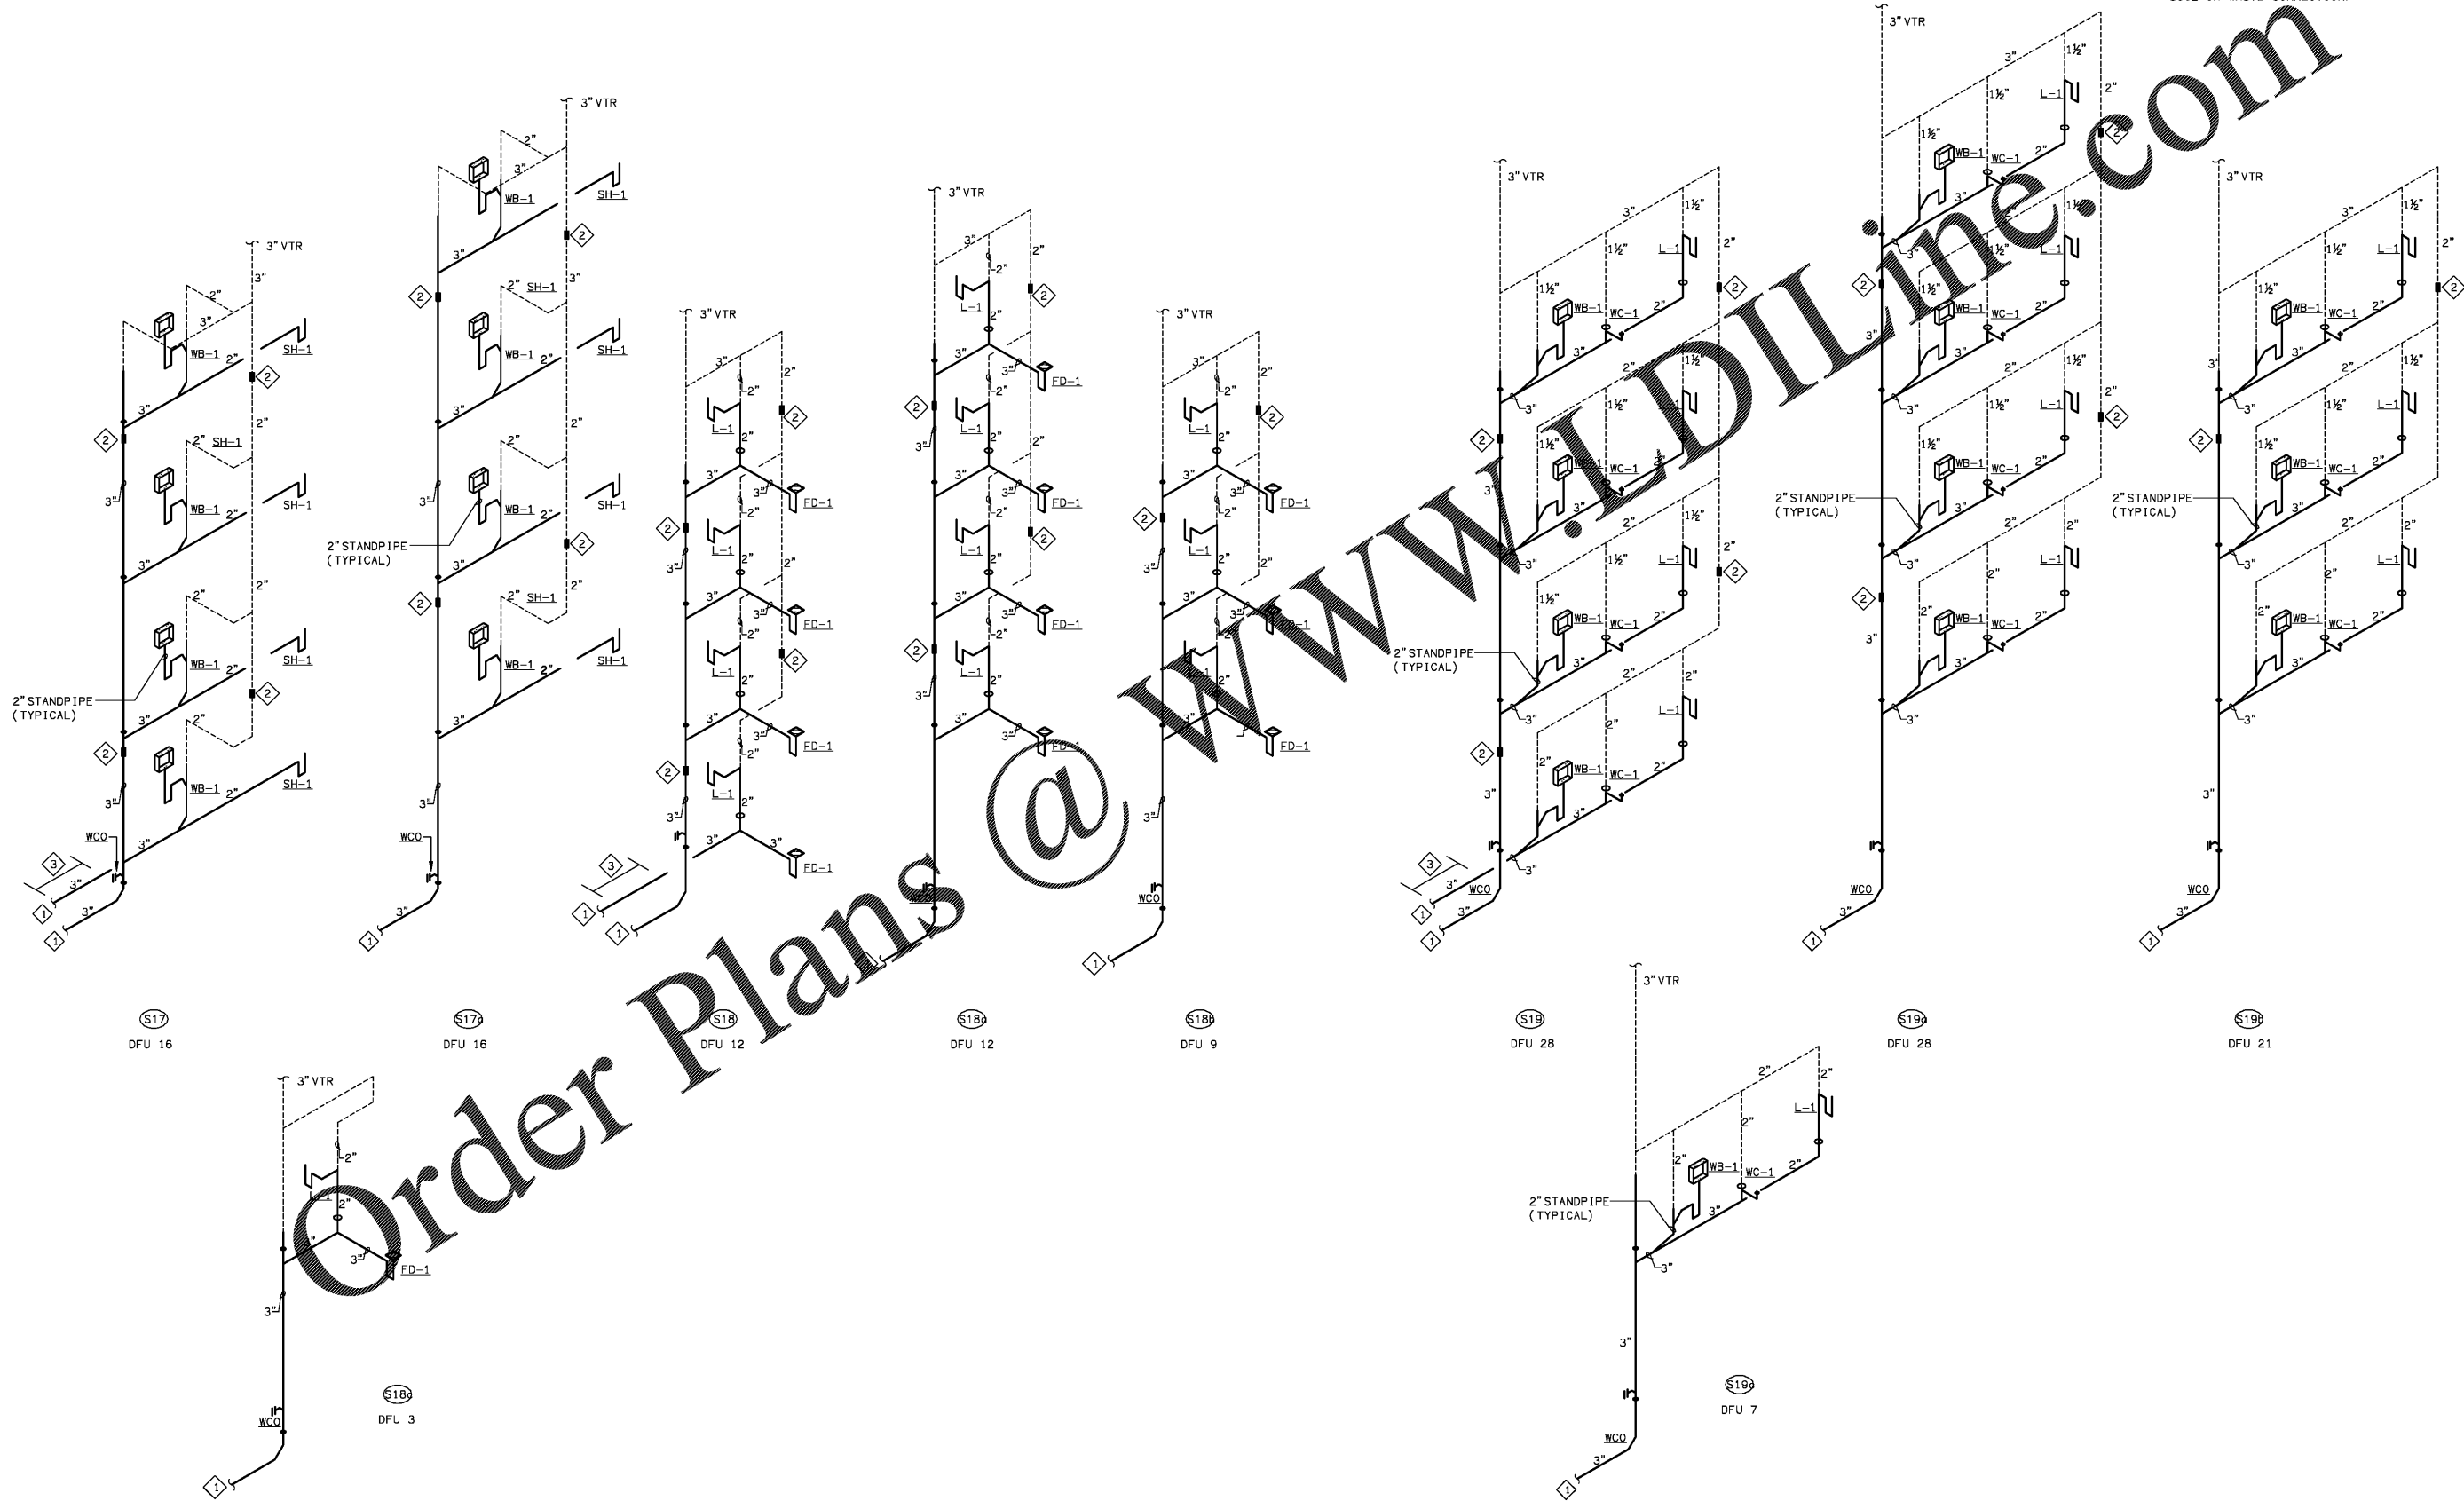

Order Plans @ WWW.DIYLINE.COM

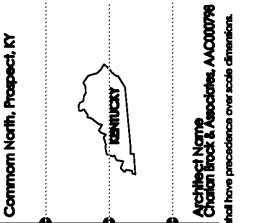

MiGre Engineers LLC
 780 FLORIDA CENTRAL PARKWAY
 SUITE 224
 LONGWOOD, FL 32750
 PH: 407.336.7999
 PROJECT #: 18025

Lyric at Norton Commons Prospect, Kentucky
 Bristol Development Group
 381 Mallory Station Rd, Suite 204
 Franklin, TN 37067

charlan brock associates
 architects • planners
 1770 fennell street
 maitland florida 32751-7208
 407.660.8900 • 407.875.9948
 www.cbaarchitects.com

PLUMBING SCHEDULES AND DETAILS

date: 06-04-2019
 job no: 3789.15
 drawn by: GNIK
 reviewed by: GNIK
 file: 18025-P-SCHEDS
 issue history:

This document is the property of Charlan Brock Associates, Inc. and shall remain the property of Charlan Brock Associates, Inc. No part of this document may be reproduced, stored in a retrieval system, or transmitted in any form or by any means, electronic, mechanical, photocopying, recording, or by any information storage and retrieval system, without the prior written permission of Charlan Brock Associates, Inc.