
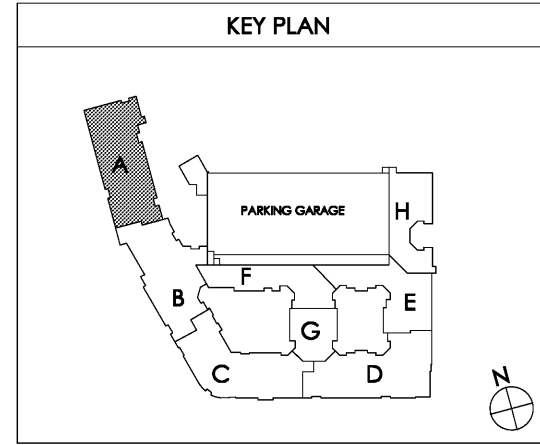


Order Plans @

WWW.LDILINE.COM

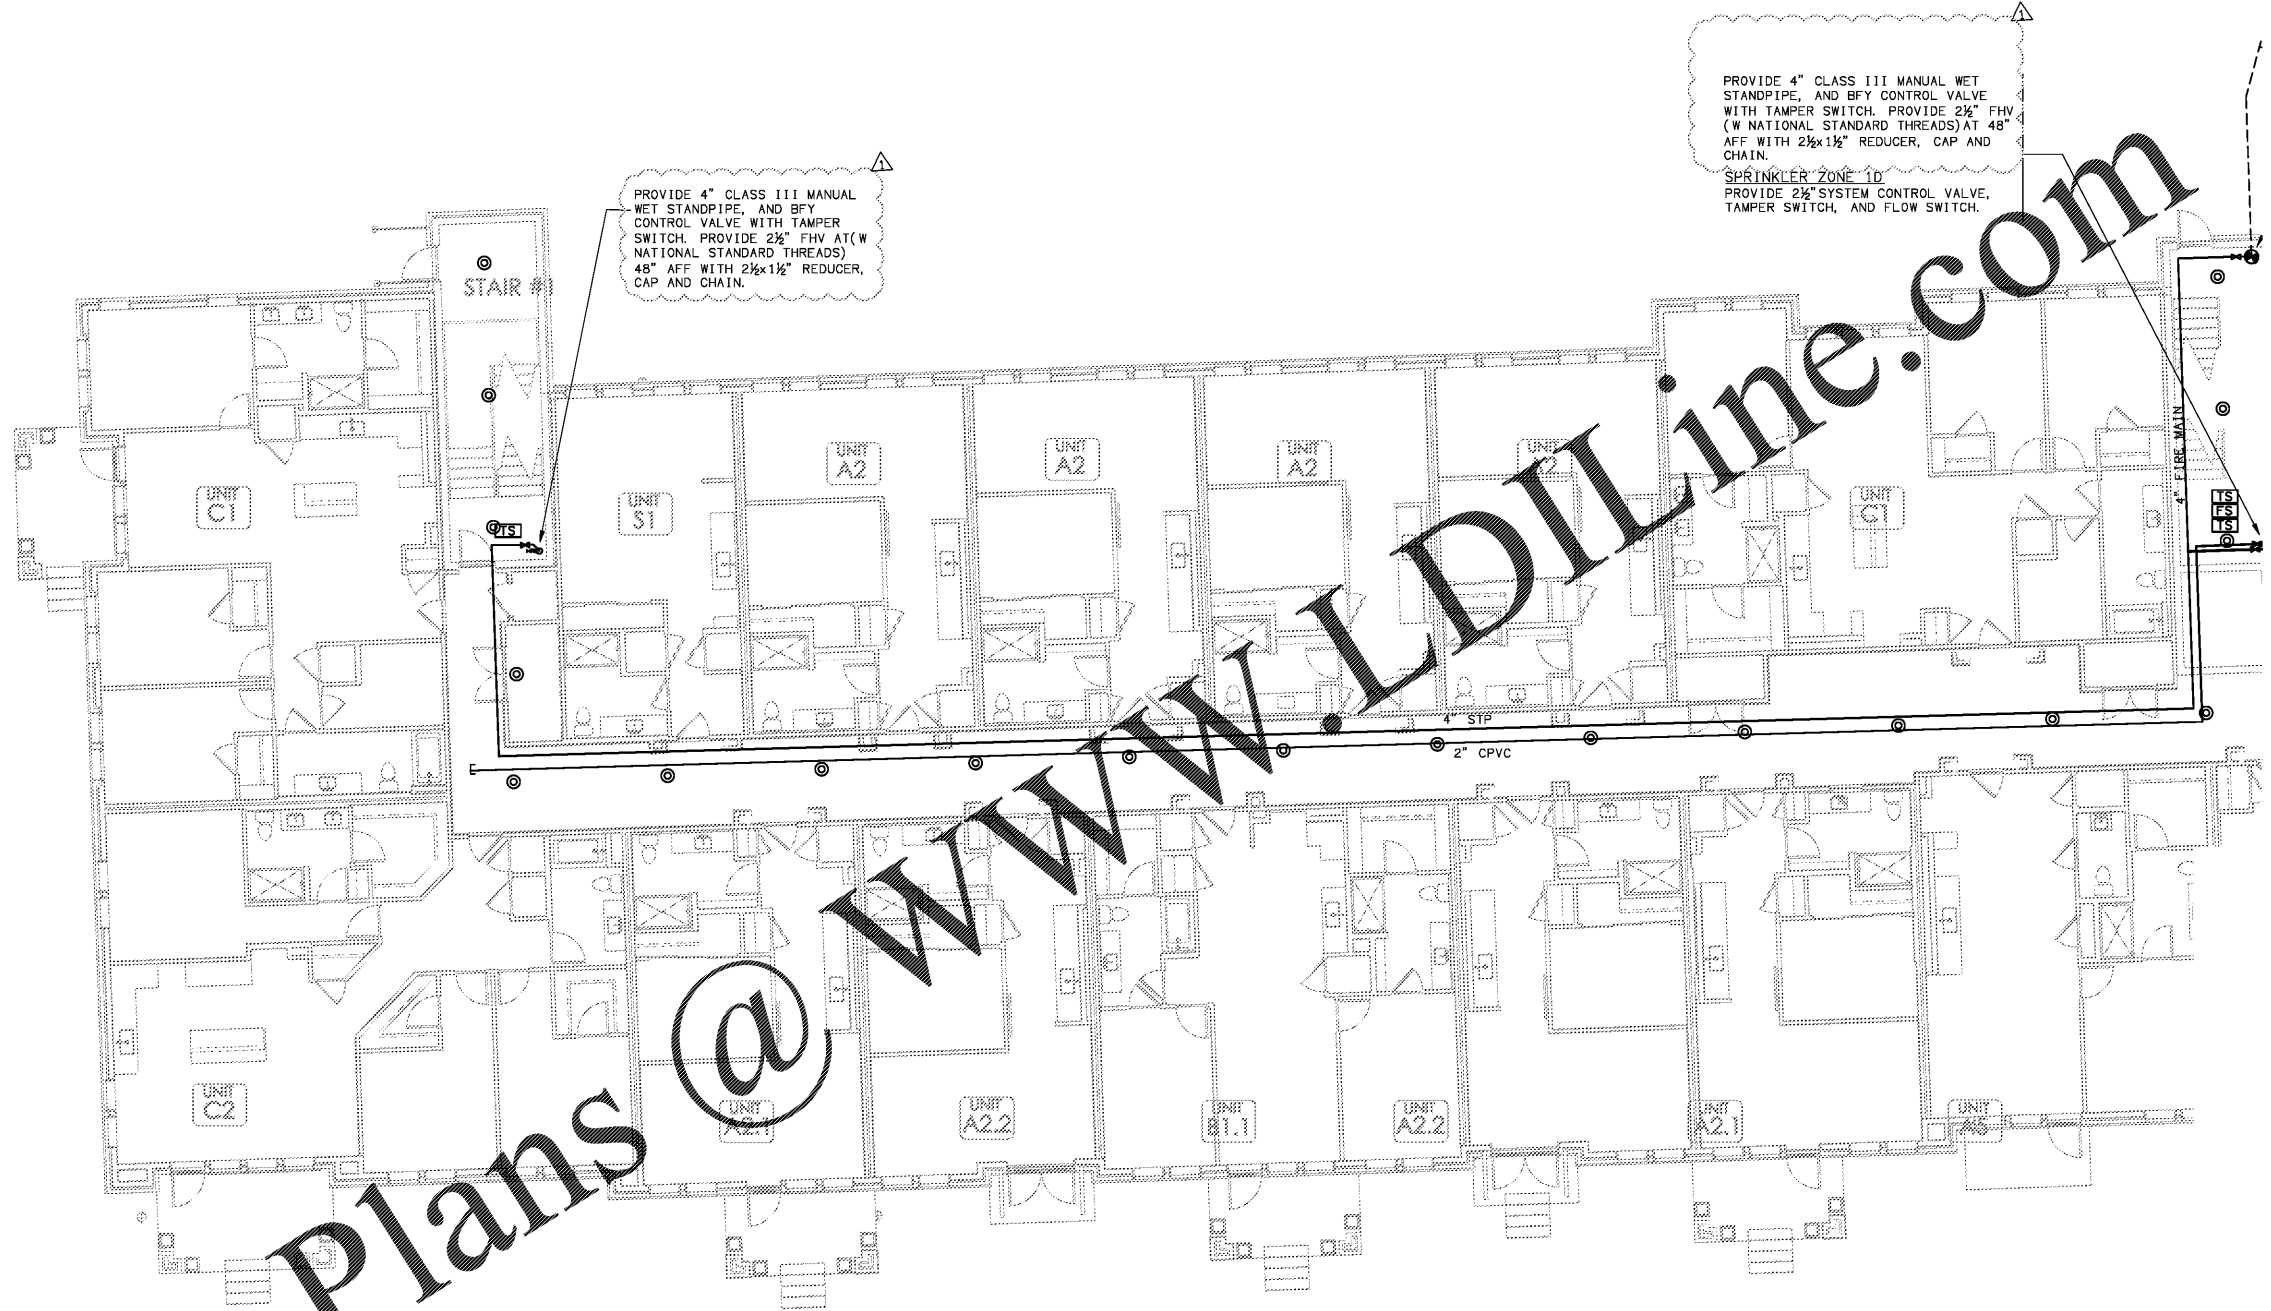

1 PARTIAL BUILDING PLAN A - (00) BASEMENT - FIRE PROTECTION PLAN
SCALE: 1/8" = 1'-0" 18026-F-BLDG

Common North, Prospect, KY
Architect: Norton Commons
Architect & Associates, A4000796

MiGre
Engineers LLC
780 FLORIDA CENTRAL PARKWAY
SUITE 224
LONGWOOD, FL 32750
PH: 407.336.7999
PROJECT #: 18025

Lyric at Norton Commons
Prospect, Kentucky
Bristol Development Group
381 Mallory Station Rd, Suite 204
Franklin, TN 37067

charlan • brock
associates
architects • planners
1770 fennell street
maitland florida 32751-7208
407.660.8900 • 407.875.5948
www.cbaarchitects.com

PARTIAL BUILDING
PLAN A - BASEMENT
FIRE PROTECTION
PLAN

date: 06-04-2019
job no: 3789.16
drawn by: GNIK
reviewed by: GNIK
file: 18026-F-BLDG
issue history:
07-03-2019

F1.10A

charlan • brock associates, inc. hereby reserves its copyright in these plans, ideas, and designs. These plans, ideas, and designs are not to be reproduced, changed or copied in any form or manner whatsoever, nor are they to be assigned to any third party, without first obtaining the express written permission from charlan • brock associates, inc. All dimensions and floor plan dimensions are in feet unless otherwise noted.