



Order Plans @

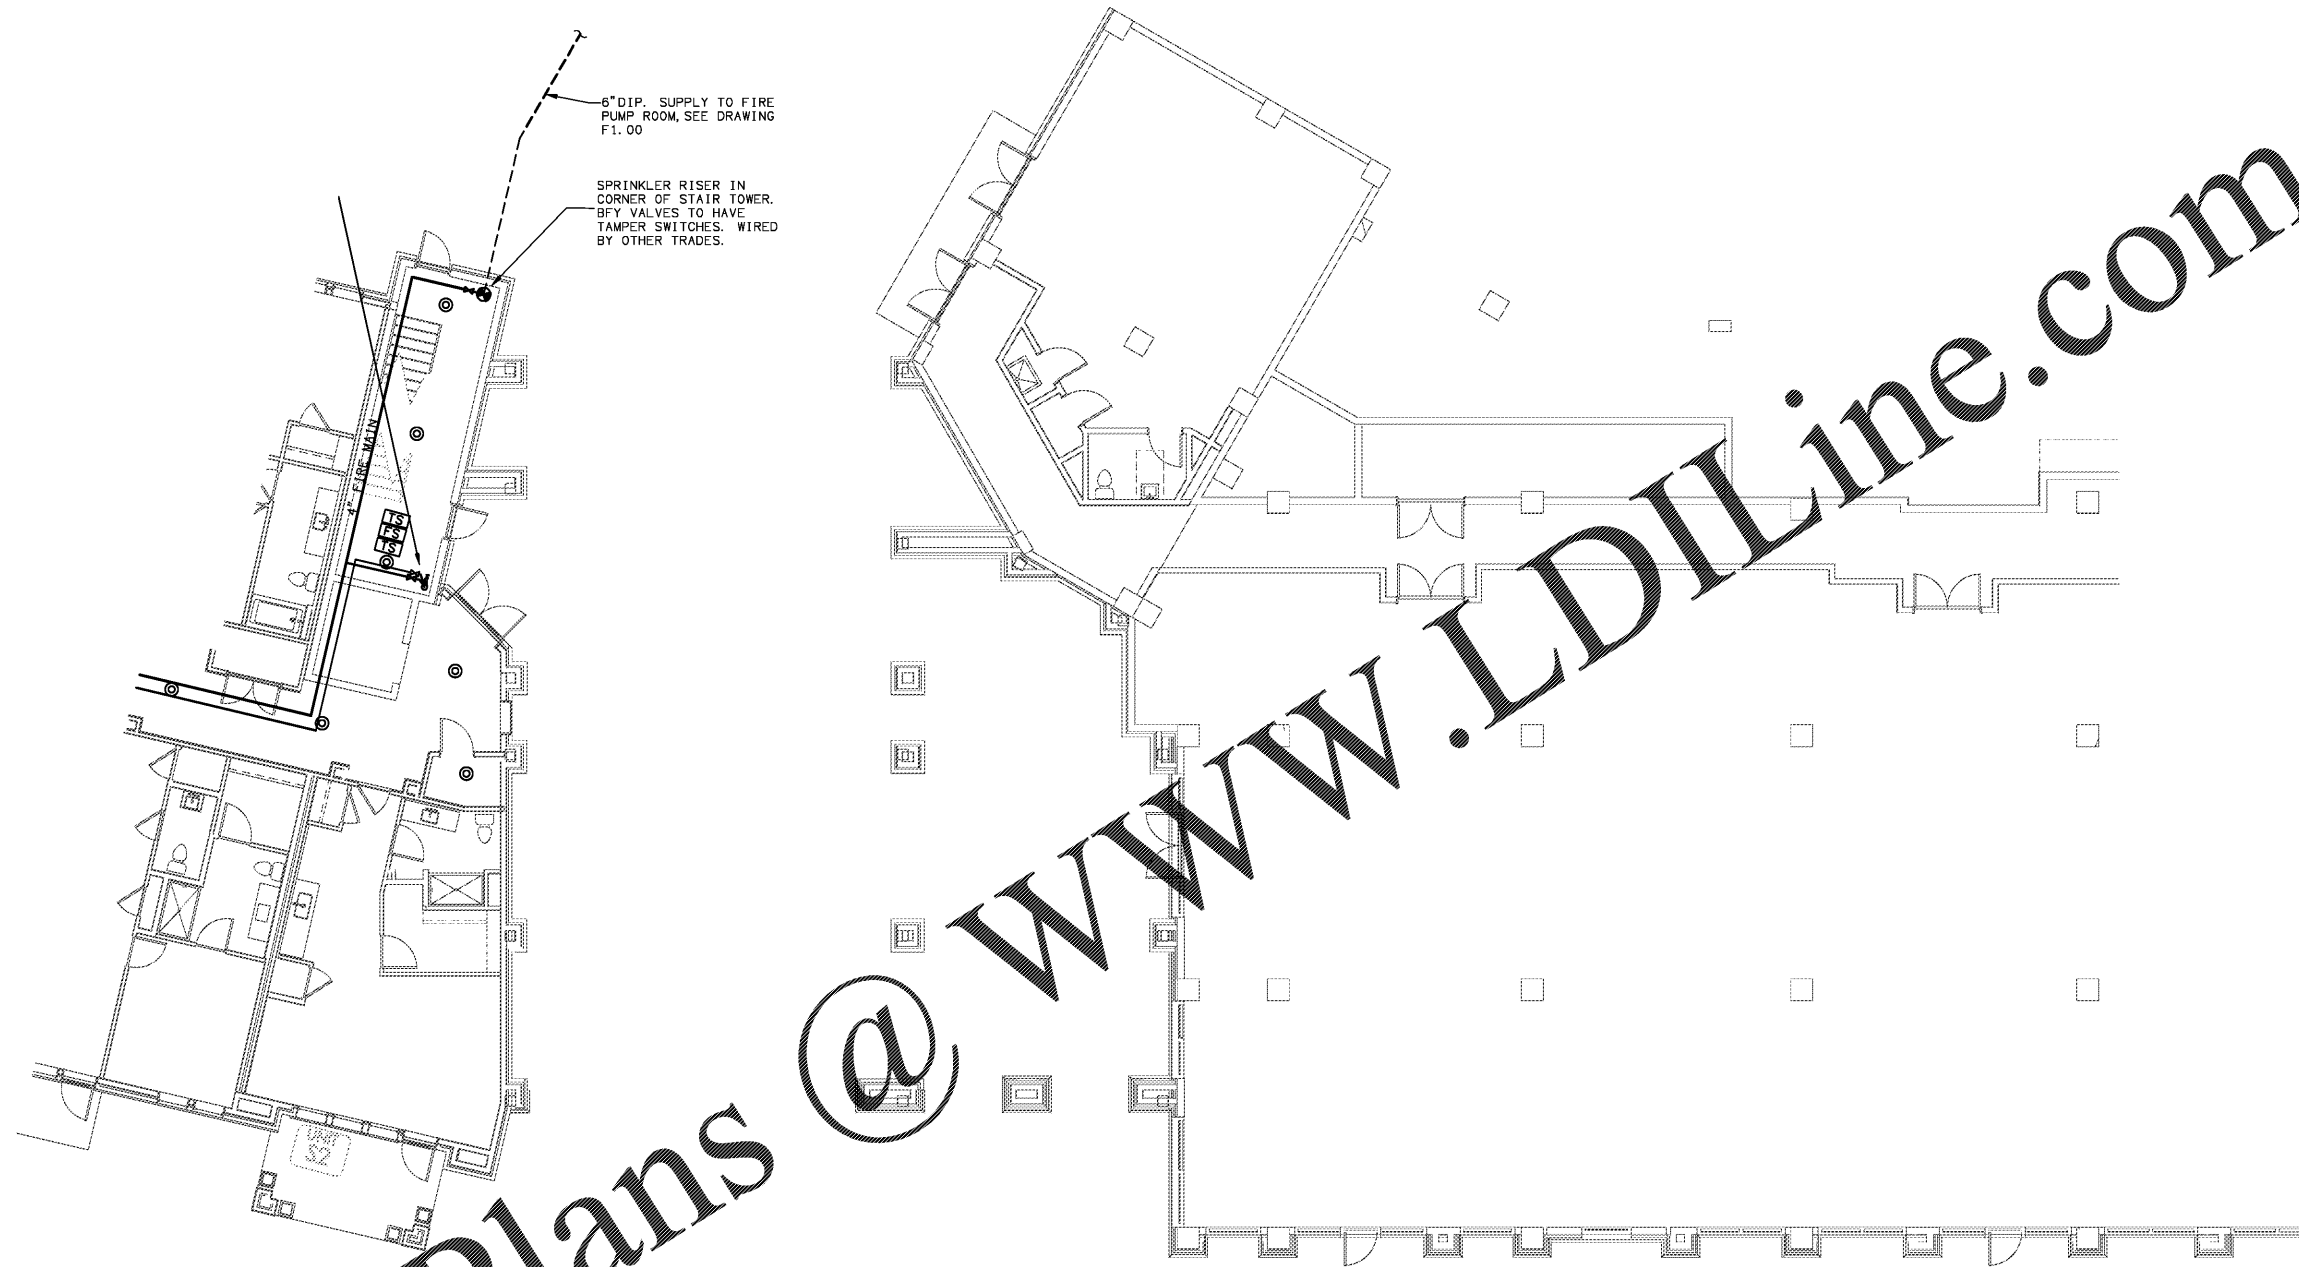

1 PARTIAL BUILDING PLAN B - (00) BASEMENT - FIRE PROTECTION PLAN  
SCALE: 1/8" = 1'-0"

18025-F-BLDG

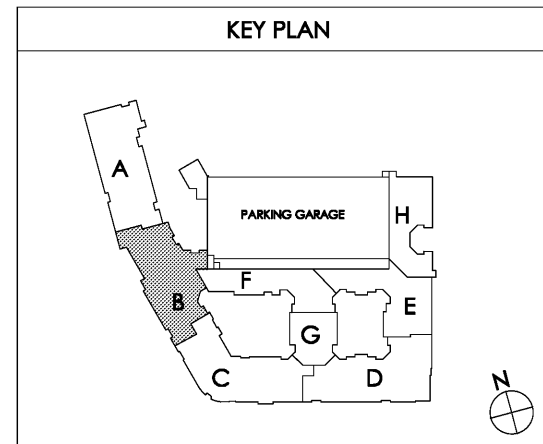

F1.10B

PLAN

FIRE PROTECTION

PLAN B - BASEMENT

PARTIAL BUILDING

architects • planners

charlan • brock  
associates

1770 fennell street  
maitland florida 32751-7208  
407.660.8900 • 407.875.5948  
www.cbaarchitects.com




Lyric at Norton Commons  
Prospect, Kentucky

Bristol Development Group  
381 Mallory Station Rd, Suite 204  
Franklin, TN 37067

Common North, Prospect, KY

MiGre  
Engineers LLC

780 FLORIDA CENTRAL PARKWAY  
SUITE 224  
LONGWOOD, FL 32750  
PH: 407.336.7999  
PROJECT #: 18025

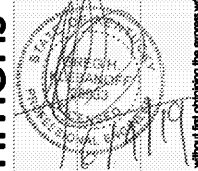

charlan • brock associates, Inc. hereby reserves its copyright in these plans, ideas, and designs. These plans, ideas, and designs are not to be reproduced, changed or copied in any form or manner whatsoever, nor are they to be assigned to any third party, without first obtaining the express written permission from C.B.A., Inc. All dimensions and floor plan dimensions are shown in feet and inches unless otherwise noted.

MiGre Engineers, LLC - 18025-F-BLDG.dwg - F1.10B - Plot Date: Thursday, June 04, 2019 10:58:10 AM