



Order Plans @

WWW.LDILINE.COM

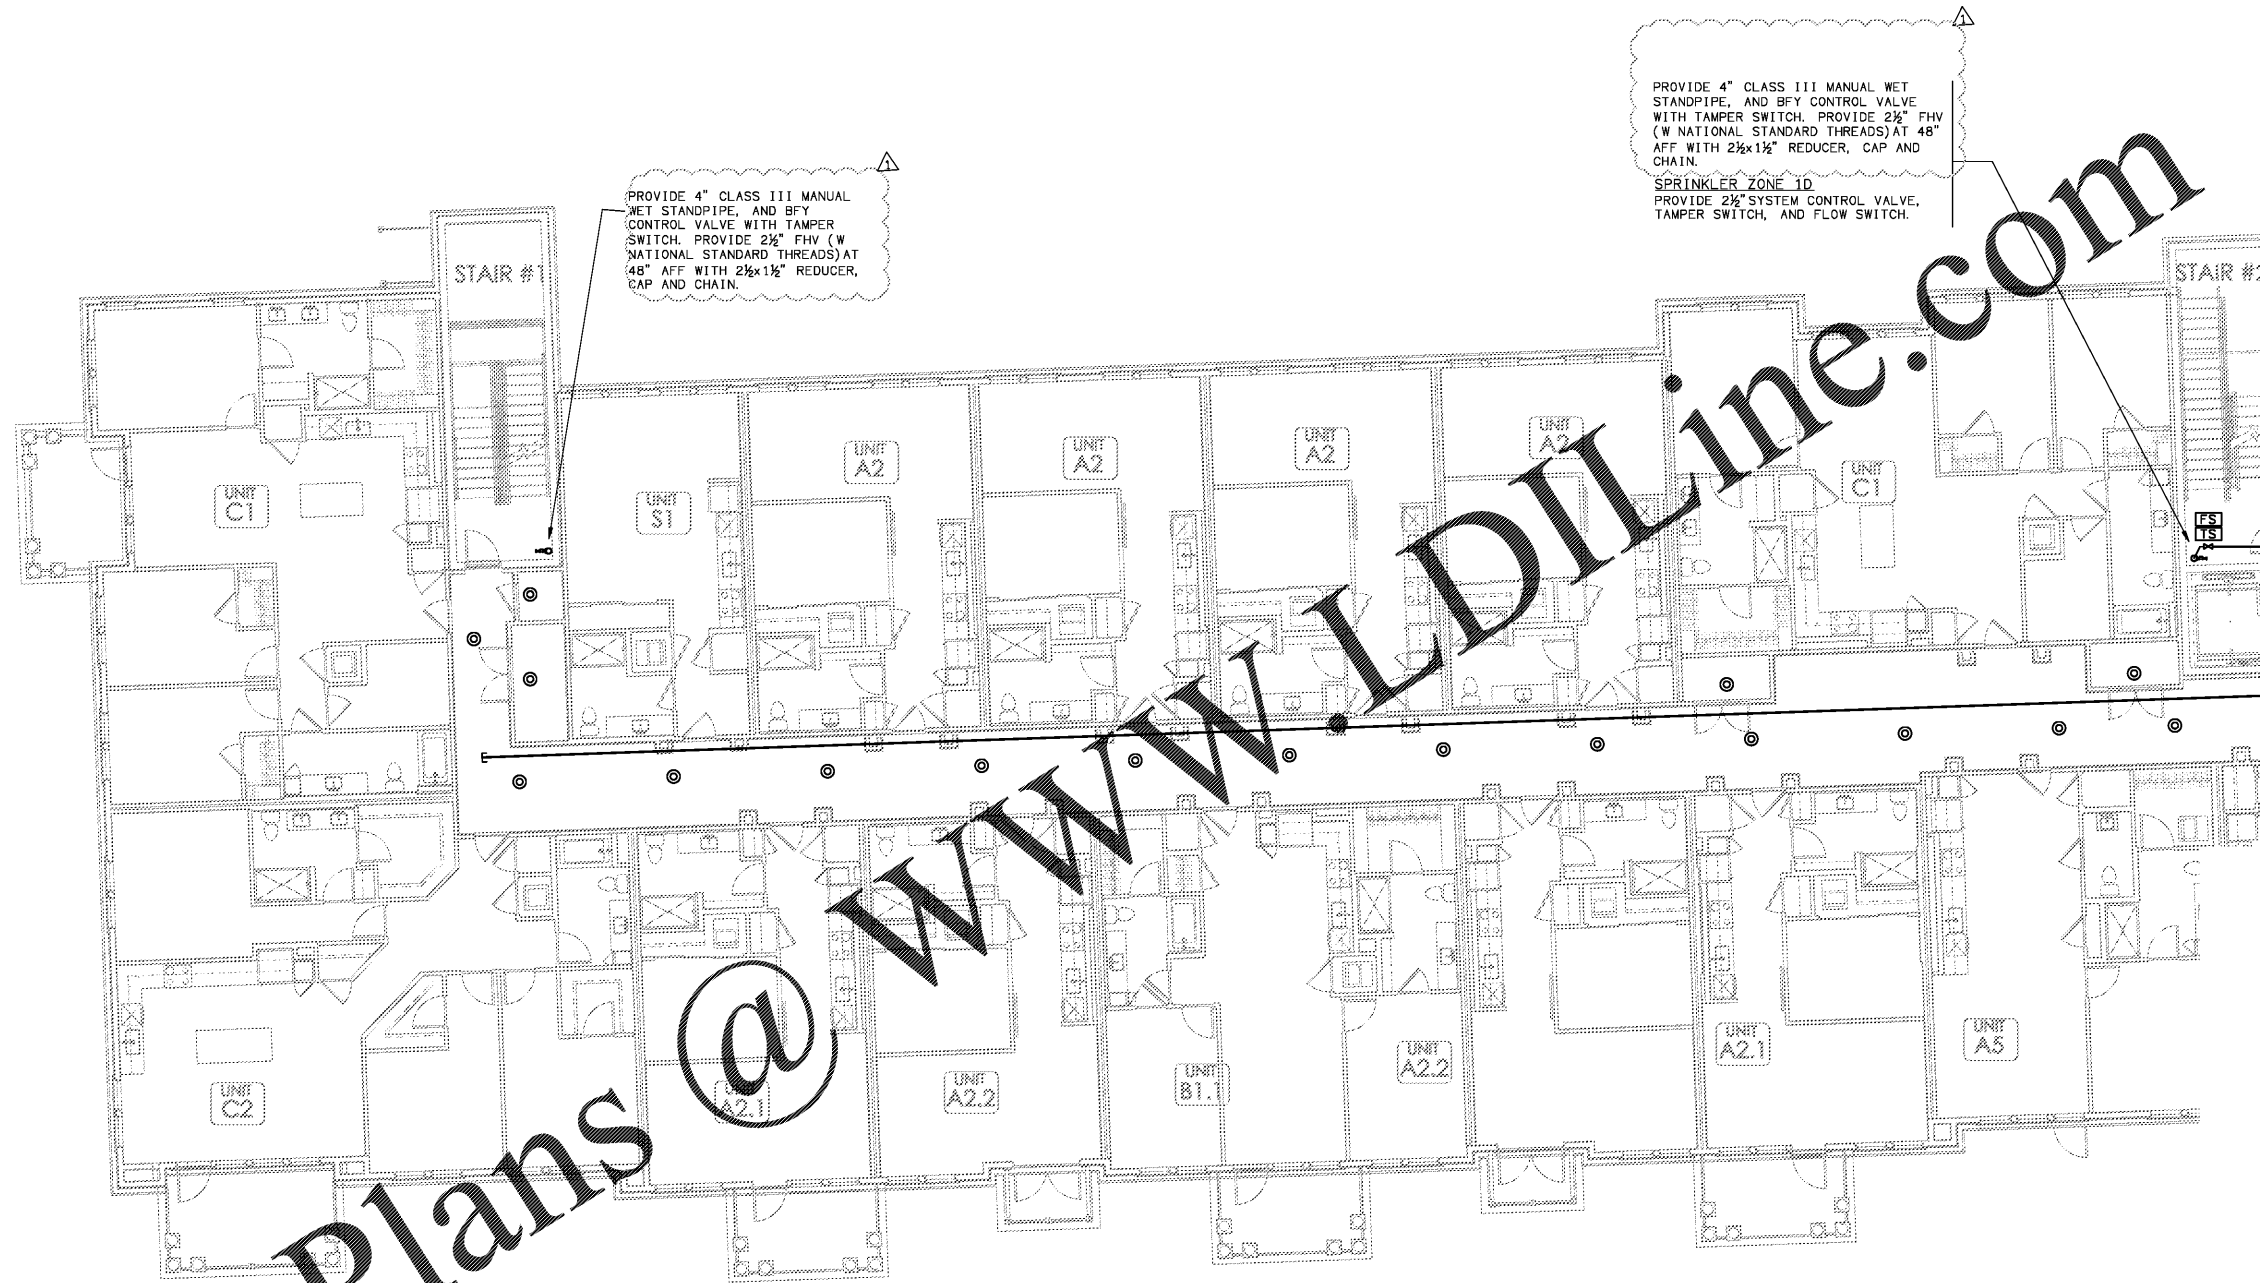

1 PARTIAL BUILDING PLAN A - (01) FIRST FLOOR - FIRE PROTECTION PLAN
SCALE: 1/8" = 1'-0"

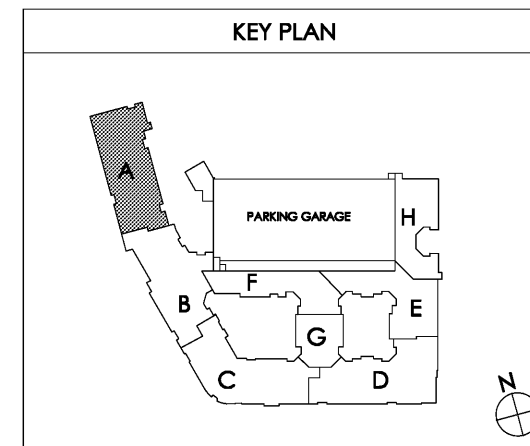

Common North, Prospect, KY

MiGre
 Engineers LLC
 780 FLORIDA CENTRAL PARKWAY
 SUITE 224
 LONGWOOD, FL 32750
 PH: 407.336.7999
 PROJECT #: 18025

Lyric at Norton Commons
 Prospect, Kentucky
 Bristol Development Group
 381 Malloy Station Rd, Suite 204
 Franklin, TN 37067

charlan • brock
 associates
 architects • planners
 1770 fennell street
 maitland florida 32751-7208
 407.660.8900 • 407.875.5948
 www.cbaarchitects.com

PARTIAL BUILDING
 PLAN A - 1ST FLOOR
 FIRE PROTECTION
 PLAN
 date: 06-04-2019
 job no: 3789.16
 drawn by: GNIK
 reviewed by: GNIK
 file: 18025-F-BLDG
 issue history:
 07-03-2019
F1.11A

charlan • brock associates, inc. hereby reserves all copyright, trademark, and other rights in these plans, ideas, and designs. These plans, ideas, and designs are the property of charlan • brock associates, inc. and shall remain the property of charlan • brock associates, inc. without limitation. No part of these plans, ideas, and designs may be reproduced, changed or copied in any form or manner whatsoever, nor are they to be assigned to any third party, without first obtaining the express written permission from charlan • brock associates, inc. within dimensions and have precedence over scale dimensions.