



Order Plans

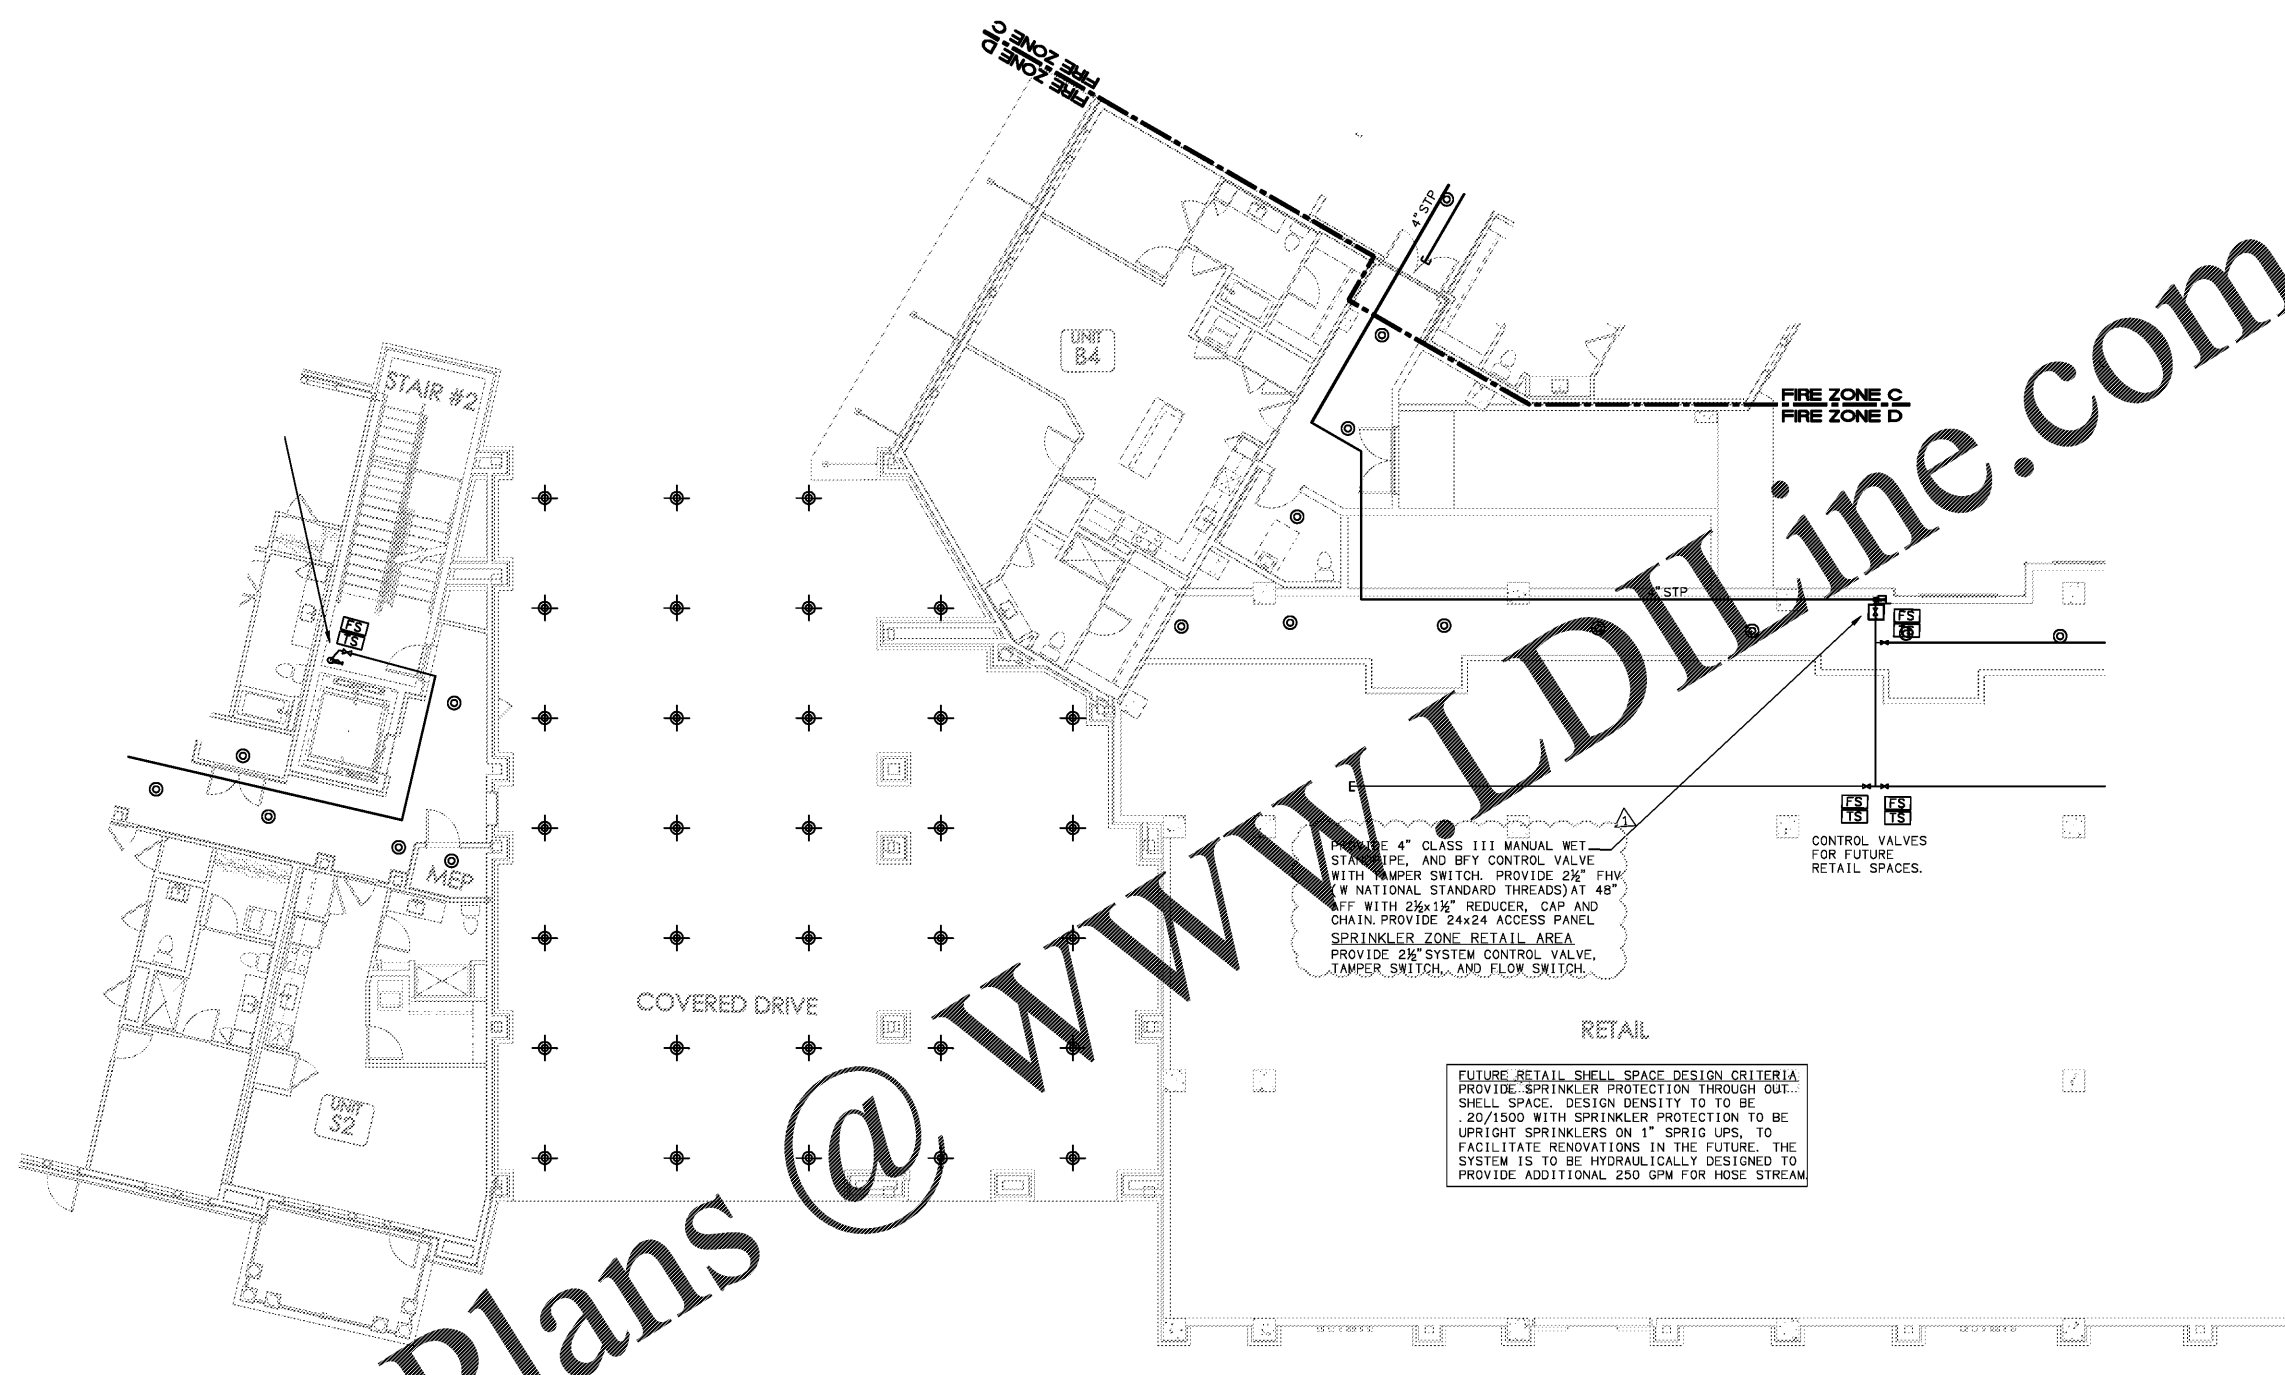

@

WWW.LDILine.com

1 PARTIAL BUILDING PLAN B - (01) FIRST FLOOR - FIRE PROTECTION PLAN
SCALE: 1/8" = 1'-0" 18025-F-BLDG

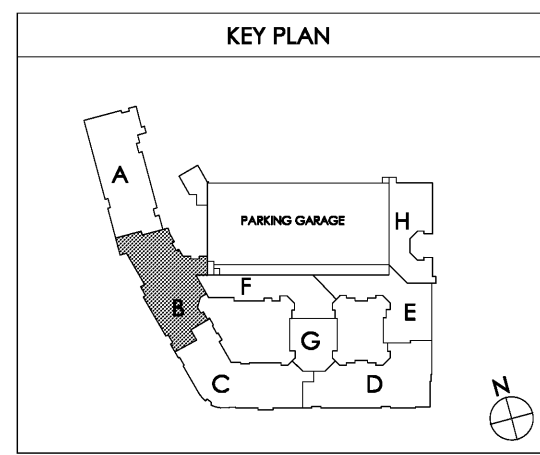

Common North, Prospect, KY

KENTUCKY

MiGre
Engineers LLC

780 FLORIDA CENTRAL PARKWAY
SUITE 224
LONGWOOD, FL 32750
PH: 407.336.7999
PROJECT #: 18025

Lyric at Norton Commons
Prospect, Kentucky

Bristol Development Group
381 Mallory Station Rd, Suite 204
Franklin, TN 37067

STATE OF KENTUCKY
OFFICE OF REGISTERED PROFESSIONAL ENGINEERS
KYLE R. KLEINHOFF
20033
PROFESSIONAL ENGINEER

charlan • brock
associates

architects • planners

1770 fennell street
maitland florida 32751-7208
407.660.8900 • 407.875.5948
www.cbarchitects.com

PARTIAL BUILDING
PLAN B - 1ST FLOOR
FIRE PROTECTION
PLAN

date: 06-04-2019
job no: 3789.16
drawn by: GNIK
reviewed by: GNIK
file: 18025-F-BLDG
issue history:
07-03-2019

F1.11B

Order Plans, Inc. hereby reserves its copyright in these plans, ideas, and designs. These plans, ideas, and designs are not to be reproduced, changed or copied in any form or manner whatsoever, nor are they to be assigned to any third party, without first obtaining the express written permission from C.D.L., Inc. All dimensions and floor plan dimensions are in feet unless otherwise indicated. The plans and specifications comply with the applicable minimum building codes and the applicable regulatory jurisdiction.