


Order Plans

WWW.LDILine.com

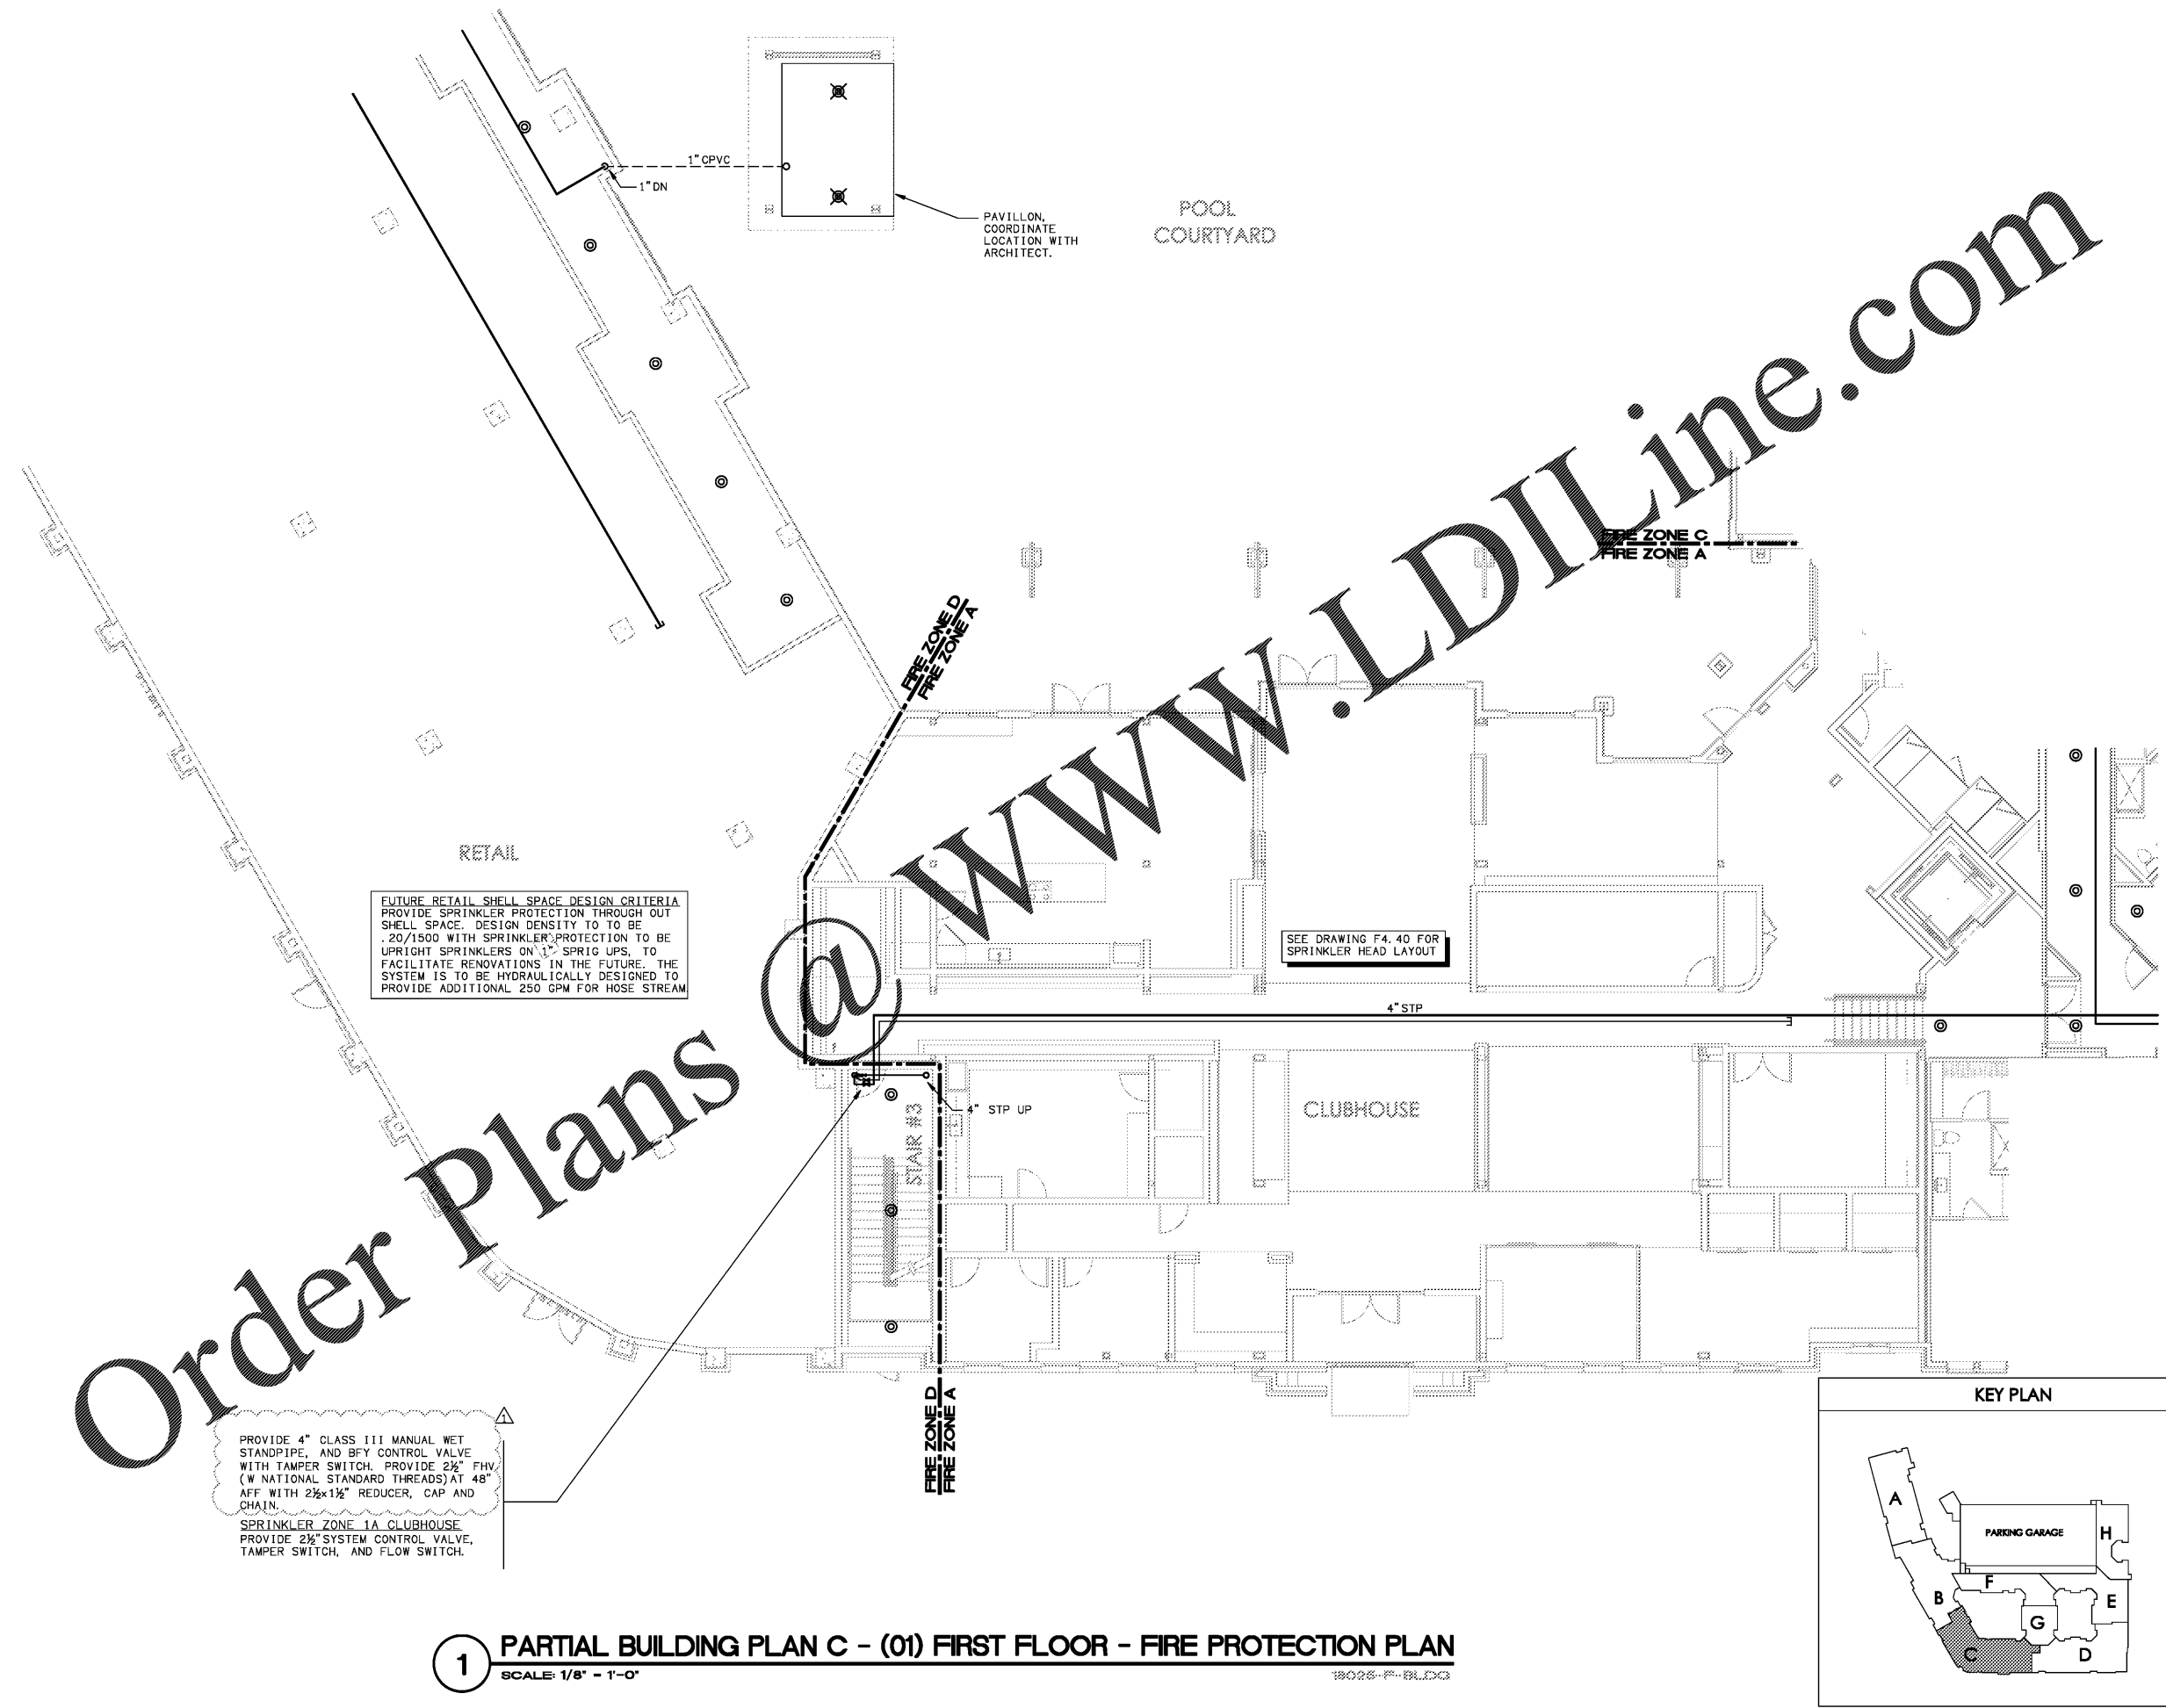


FUTURE RETAIL SHELL SPACE DESIGN CRITERIA
 PROVIDE SPRINKLER PROTECTION THROUGH OUT SHELL SPACE. DESIGN DENSITY TO BE 20/1500 WITH SPRINKLER PROTECTION TO BE UPRIGHT SPRINKLERS ON 3\"/>

SEE DRAWING F4.40 FOR SPRINKLER HEAD LAYOUT

PROVIDE 4\"/>

1 PARTIAL BUILDING PLAN C - (01) FIRST FLOOR - FIRE PROTECTION PLAN
 SCALE: 1/8" = 1'-0"

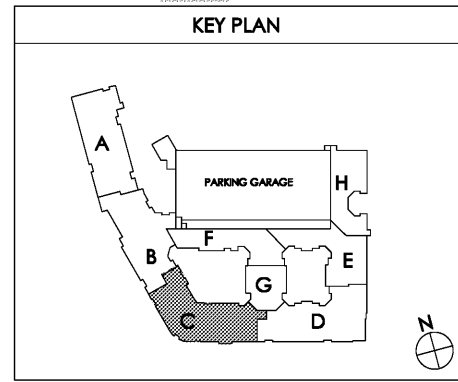

Charlan Brock Associates, Inc. hereby reserves all copyright and other rights in these plans, specifications, and details. These plans, specifications, and details are not to be reproduced, changed or copied in any form or manner whatsoever, nor are they to be employed in any filed party, without first obtaining the express written permission from C.B.A., Inc. All dimensions and notes are in feet and inches unless otherwise specified.