
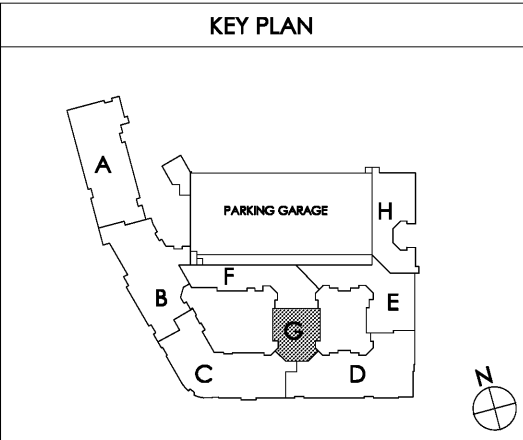


Order Plans @ WWW.LDILINE.COM

1 PARTIAL BUILDING PLAN G - (01) FIRST FLOOR - FIRE PROTECTION PLAN
 SCALE: 1/8" = 1'-0"

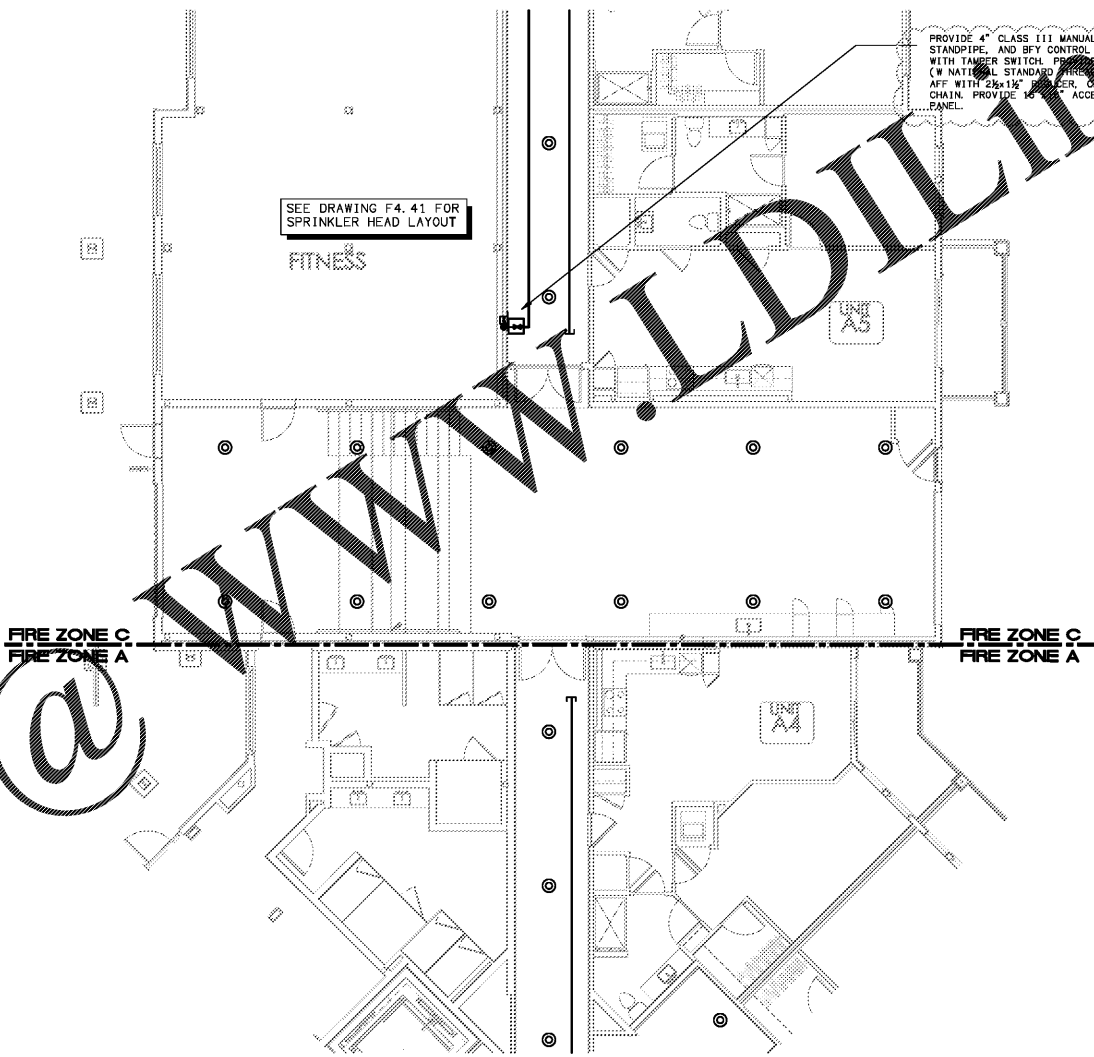

Common North, Prospect, KY

MiGre
 Engineers LLC

780 FLORIDA CENTRAL PARKWAY
 SUITE 224
 LONGWOOD, FL 32750
 PH: 407.336.7999
 PROJECT #: 18025

Lyric at Norton Commons
 Prospect, Kentucky

Bristol Development Group
 381 Mallory Station Rd, Suite 204
 Franklin, TN 37067

charlan • brock
 associates
 architects • planners

1770 fennell street
 maitland florida 32751-7208
 407.660.8900 • 407.875.5948
 www.cbaarchitects.com

PARTIAL BUILDING
 PLAN G - 1ST FLOOR
 FIRE PROTECTION
 PLAN

date: 06-04-2019
 job no: 3789.16
 drawn by: GNIK
 reviewed by: GNIK
 file: 18025-F-BLDG
 issue history:
 07-03-2019

F1.11G

Professional Engineer Seal: STATE OF KENTUCKY, OFFICE OF PROFESSIONAL ENGINEERS, GREGORY S. DILLON, No. 21933

Objections, inquiries, and requests for information should be directed to the architect. The architect is not responsible for the accuracy of the information provided in this drawing. The architect is not responsible for the accuracy of the information provided in this drawing. The architect is not responsible for the accuracy of the information provided in this drawing.