


Order Plans

WWW.LDLINE.COM

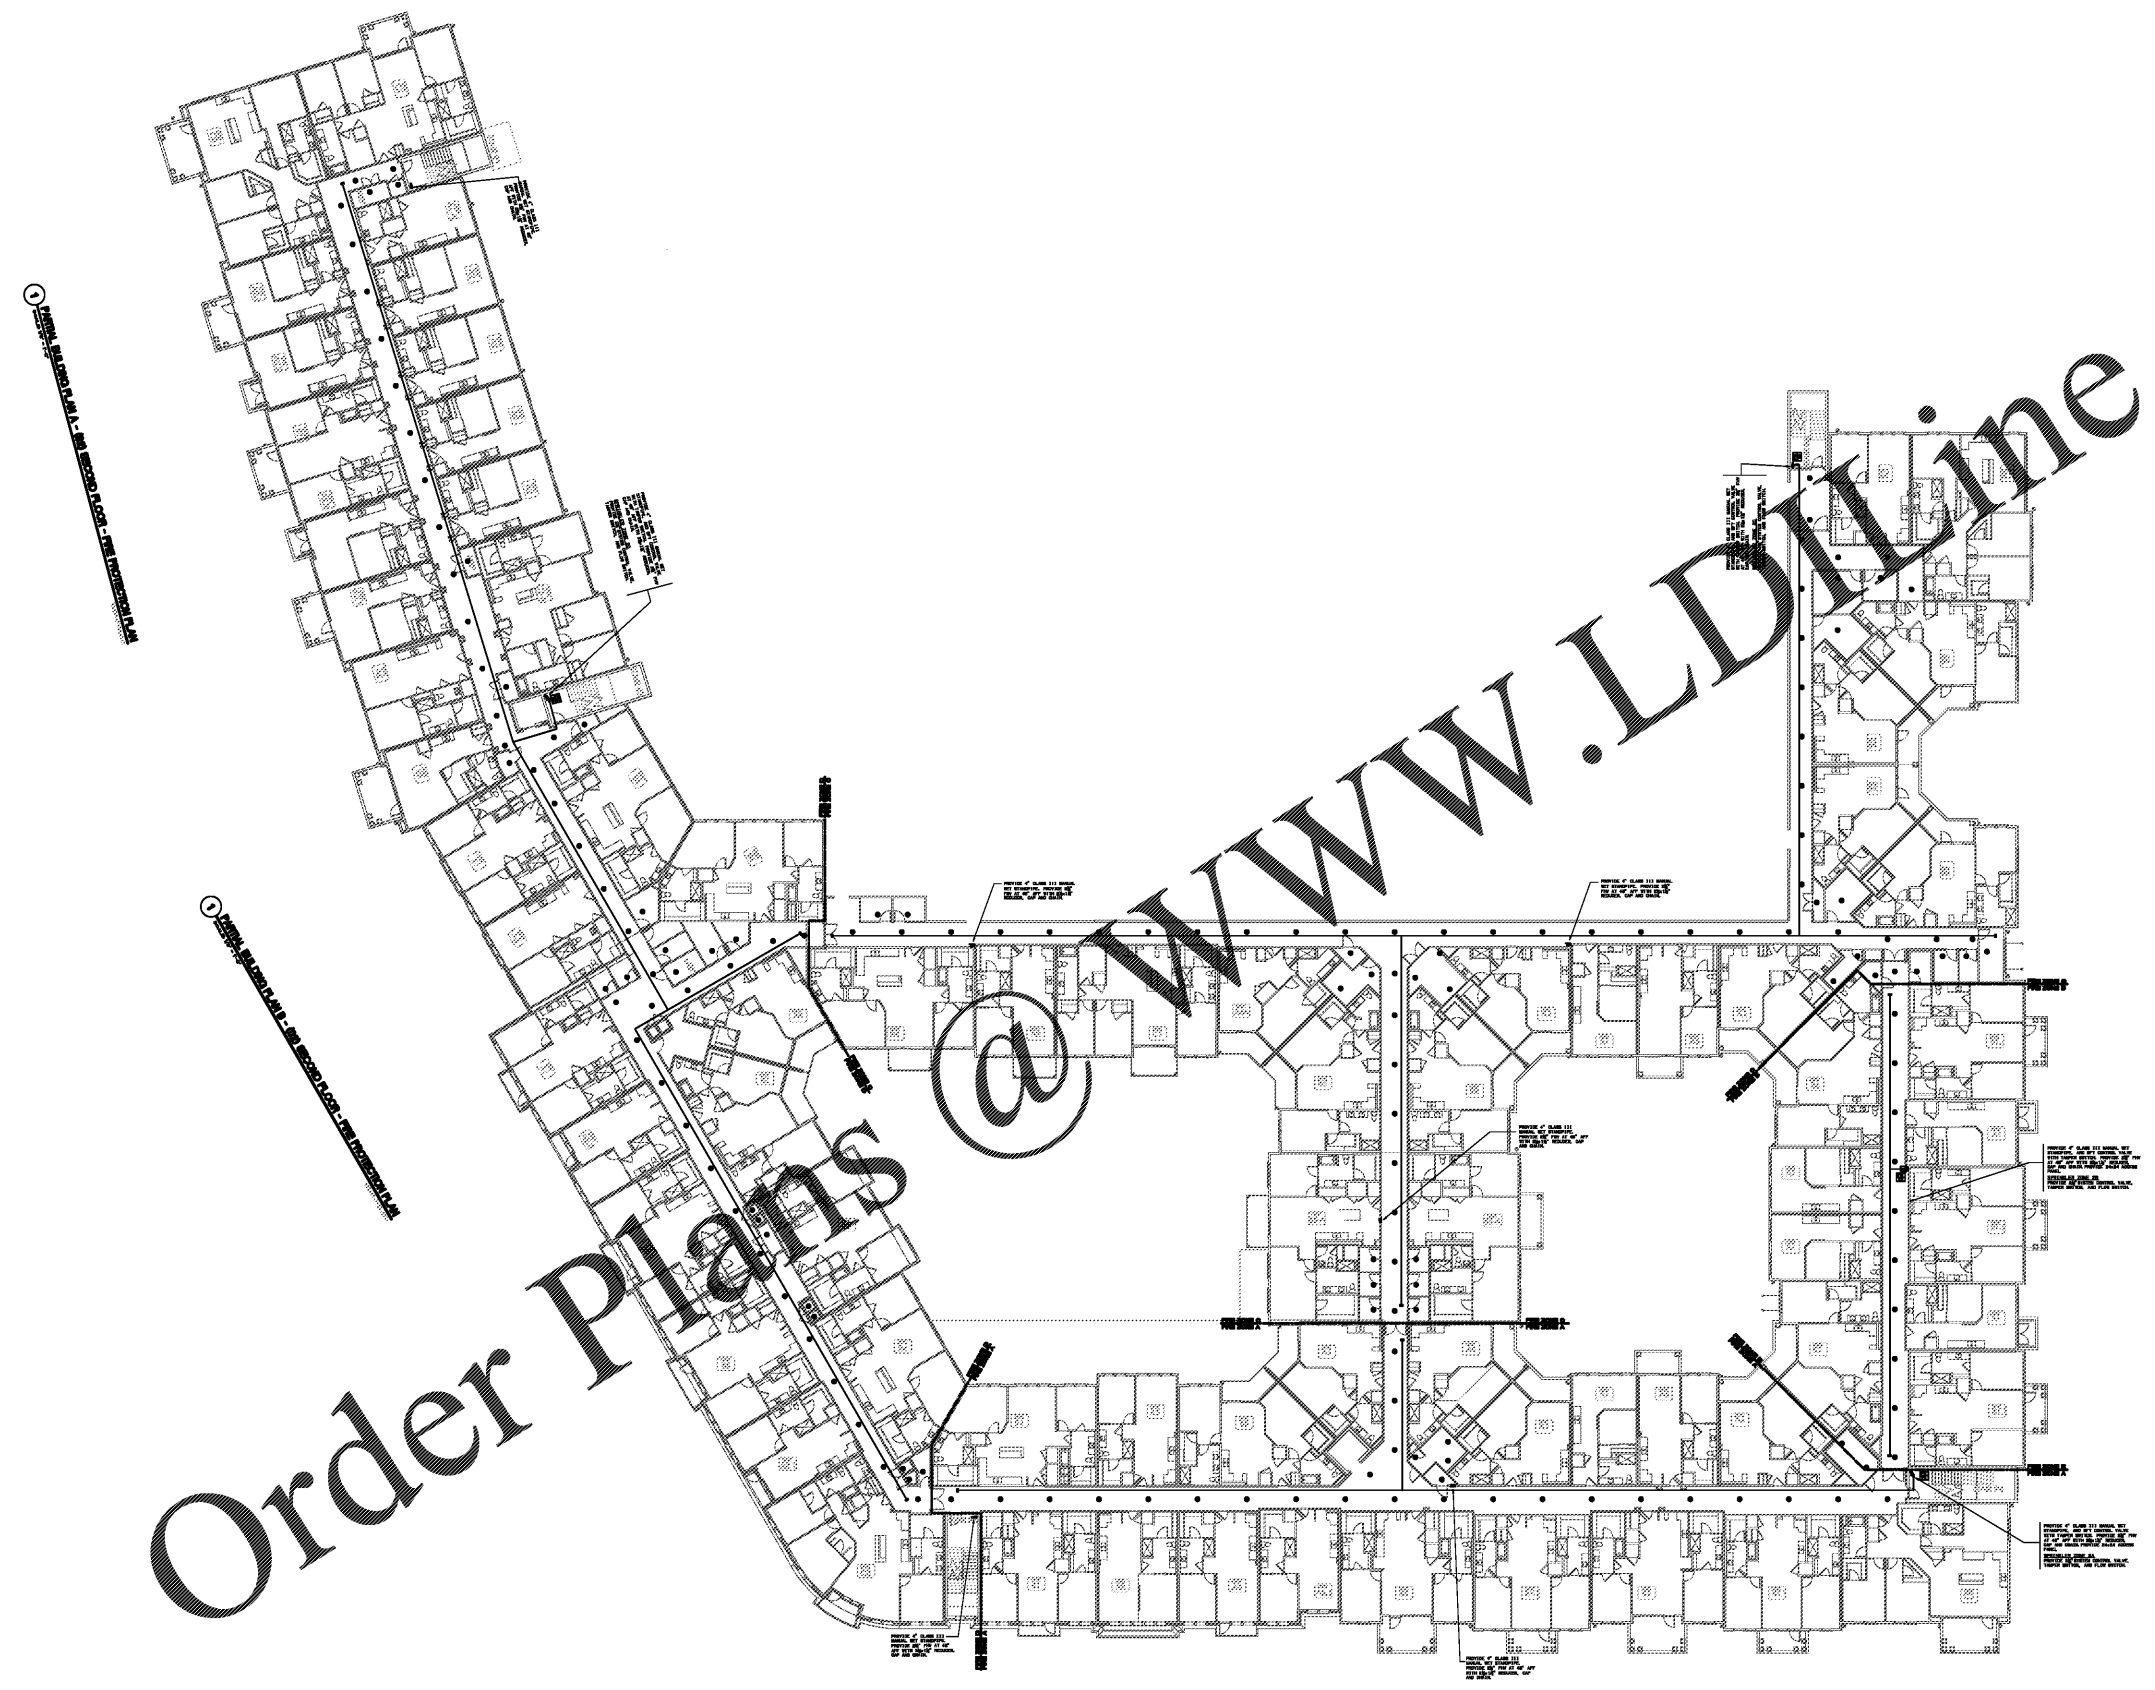

1 PARTIAL BUILDING PLAN C - 02 SECOND FLOOR - FIRE PROTECTION PLAN

1 PARTIAL BUILDING PLAN D - 02 SECOND FLOOR - FIRE PROTECTION PLAN

1 BUILDING TYPE ONE SECOND FLOOR - FIRE PROTECTION PLAN
SCALE: 1" = 25'-0"


180225-PP-0001.DWG

Common North, Prospect, KY



MiGre
Engineers LLC

780 FLORIDA CENTRAL PARKWAY
SUITE 224
LONGWOOD, FL 32750
PH: 407.336.7999
PROJECT #: 18025

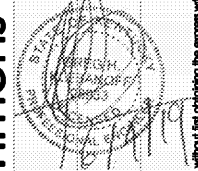

Lyric at Norton Commons
Prospect, Kentucky

Bristol Development Group
381 Mallory Station Rd, Suite 204
Franklin, TN 37067

charlan • brock
associates

architects • planners
1770 fennell street
maitland florida 32751-7208
407.660.8900 • 407.875.9948
www.cbaarchitects.com

BUILDING TYPE ONE
SECOND FLOOR
FIRE PROTECTION
PLAN

date: 06-04-2019
job no: 3789.15
drawn by: GNIK
reviewed by: GNIK
file: 18025-F-BLDG
issue history:

F1.12

charlan • brock associates, Inc. hereby reserves its copyright for copyright and other rights in these plans, ideas, and designs. These plans, ideas, and designs are not to be reproduced, changed or copied in any form or manner whatsoever, nor are they to be assigned to any third party, without first obtaining the express written permission from C.B.A., Inc. within dimensions and have precedence over scale dimensions.

MiGre Engineers, LLC - Member of LDLine.com - P.E. © 2019 MiGre Engineers, LLC - All Rights Reserved.