


Order Plans @


WWW.LDILINE.COM

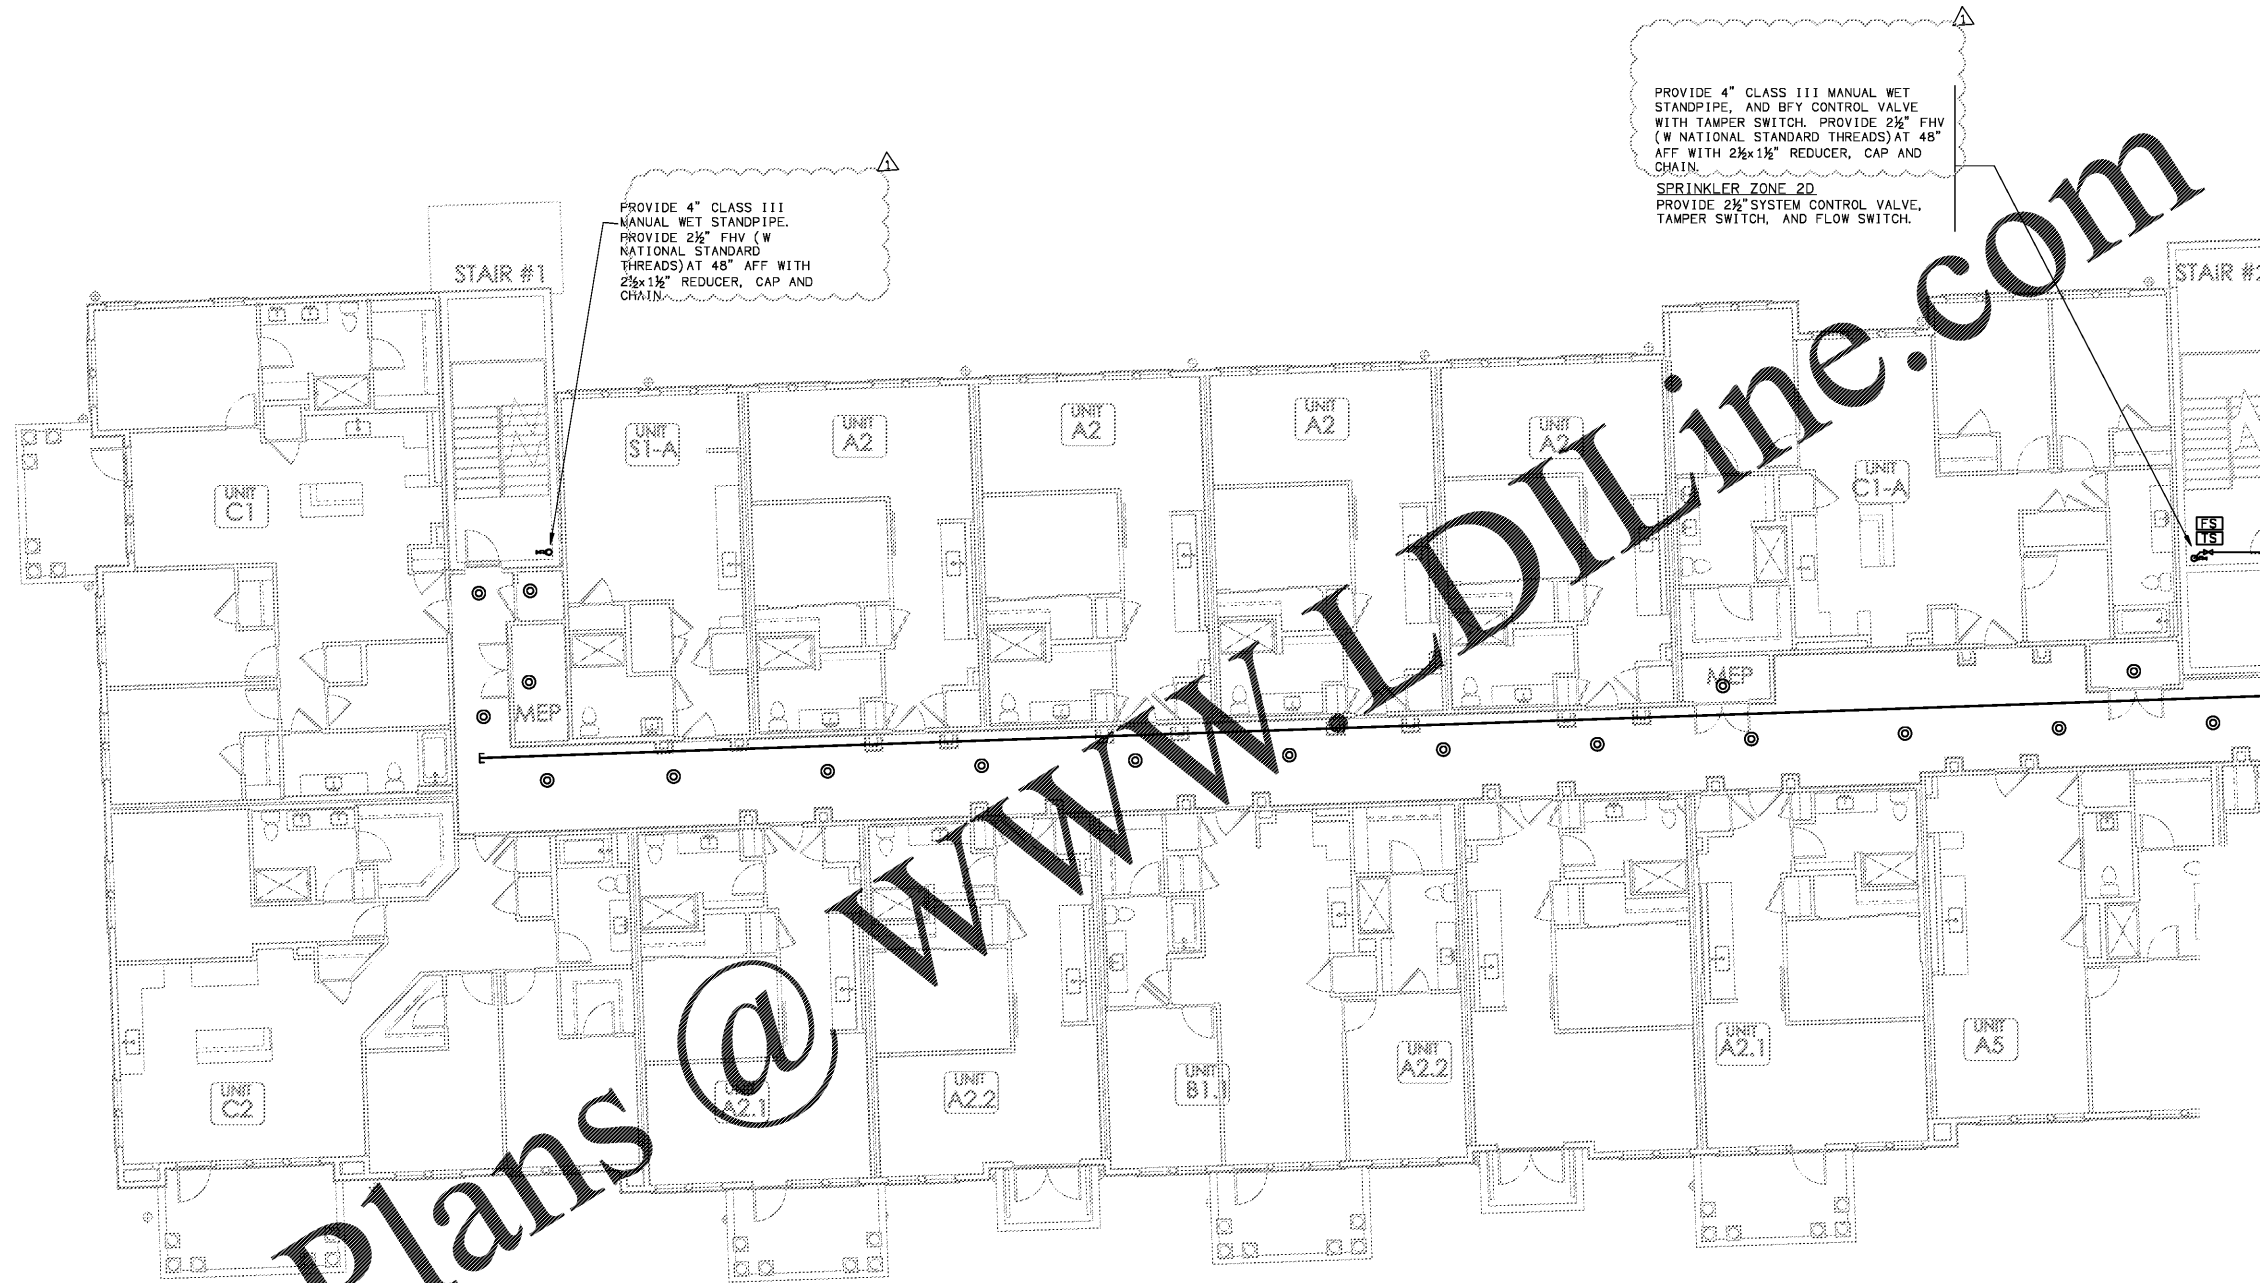

1 PARTIAL BUILDING PLAN A - (02) SECOND FLOOR - FIRE PROTECTION PLAN  
SCALE: 1/8" = 1'-0" 18025-F-BLDG

PROVIDE 4" CLASS III MANUAL WET STANDPIPE, AND BFCY CONTROL VALVE WITH TAMPER SWITCH. PROVIDE 2 1/2" FHV (W NATIONAL STANDARD THREADS) AT 48" AFF WITH 2 1/2x1 1/2" REDUCER, CAP AND CHAIN.  
SPRINKLER\_ZONE\_2D  
PROVIDE 2 1/2" SYSTEM CONTROL VALVE, TAMPER SWITCH, AND FLOW SWITCH.

PROVIDE 4" CLASS III MANUAL WET STANDPIPE, PROVIDE 2 1/2" FHV (W NATIONAL STANDARD THREADS) AT 48" AFF WITH 2 1/2x1 1/2" REDUCER, CAP AND CHAIN.

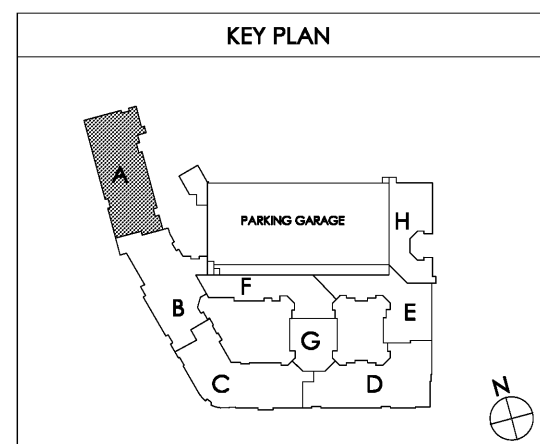

Common North, Prospect, KY  
Kentucky  
Architect Name  
Charlan Brock & Associates, A4000796

**MiGre**  
Engineers LLC  
780 FLORIDA CENTRAL PARKWAY  
SUITE 224  
LONGWOOD, FL 32750  
PH: 407.336.7999  
PROJECT #: 18025

Lyric at Norton Commons  
Prospect, Kentucky  
Bristol Development Group  
381 Mallory Station Rd, Suite 204  
Franklin, TN 37067

charlan • brock  
associates  
architects • planners  
1770 fennell street  
maitland florida 32751-7208  
407.660.8900 • 407.875.5948  
www.cbarchitects.com

PARTIAL BUILDING  
PLAN A - 2ND FLOOR  
FIRE PROTECTION  
PLAN

date: 06-04-2019  
job no: 3789.16  
drawn by: GNIK  
reviewed by: GNIK  
file: 18025-F-BLDG  
issue history:  
07-03-2019

F1.12A

Charlan Brock & Associates, Inc. hereby reserves its copyright in these plans, specifications, and other documents. No part of these documents may be reproduced, stored in a retrieval system, or transmitted in any form or by any means, electronic, mechanical, photocopying, recording, or by any information storage and retrieval system, without the prior written permission of Charlan Brock & Associates, Inc. All dimensions and notes are in inches unless otherwise specified.