
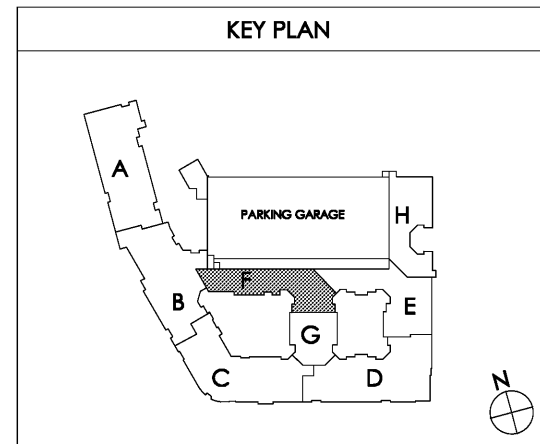


Order Plans @ WWW.LDILine.com

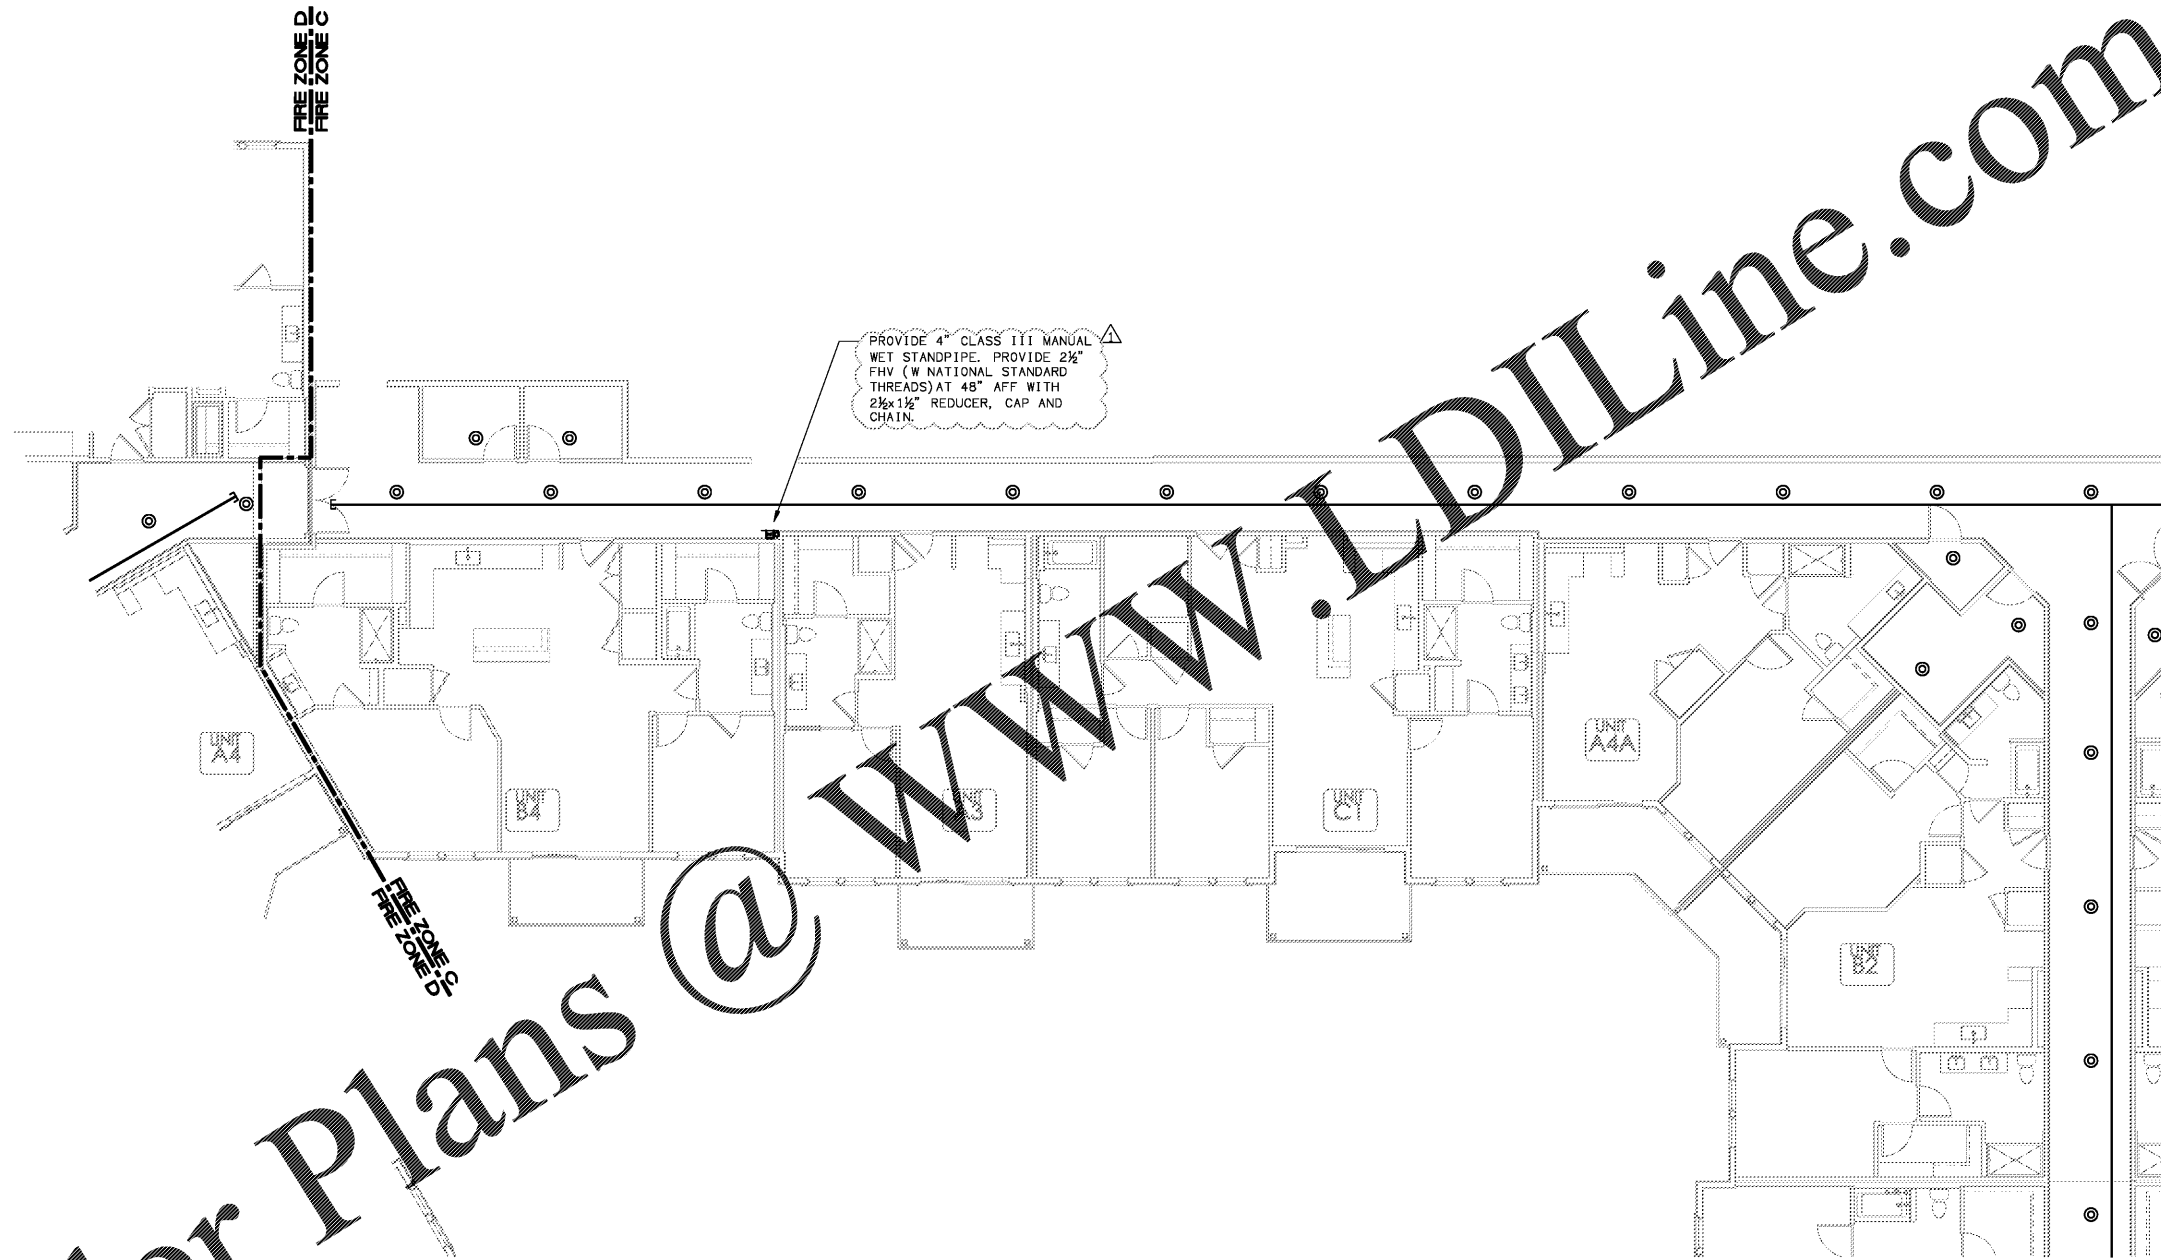

1 PARTIAL BUILDING PLAN F - (02) SECOND FLOOR - FIRE PROTECTION PLAN  
 SCALE: 1/8" = 1'-0"  
 18025-F-BLDG

Common North, Prospect, KY  
 MiGre Engineers LLC  
 780 FLORIDA CENTRAL PARKWAY  
 SUITE 224  
 LONGWOOD, FL 32750  
 PH: 407.336.7999  
 PROJECT #: 18025

Lyric at Norton Commons  
 Prospect, Kentucky  
 Bristol Development Group  
 381 Mallory Station Rd, Suite 204  
 Franklin, TN 37067

charlan • brock  
 associates  
 architects • planners  
 1770 fennell street  
 maitland florida 32751-7208  
 407.660.8900 • 407.875.5948  
 www.cbaarchitects.com

PARTIAL BUILDING  
 PLAN F - 2ND FLOOR  
 FIRE PROTECTION  
 PLAN  
 date: 06-04-2019  
 job no: 3789.16  
 drawn by: GNIK  
 reviewed by: GNIK  
 file: 18025-F-BLDG  
 issue history:  
 07-03-2019  
 F1.12F

Charlan Brock & Associates, Inc. hereby reserves its copyright in these plans, ideas, and designs. These plans, ideas, and designs are not to be reproduced, changed or copied in any form or manner whatsoever, nor are they to be assigned to any third party, without first obtaining the express written permission from C.B.A., Inc. All dimensions and floor plan dimensions are in feet and inches unless otherwise specified. The plans and specifications comply with the applicable minimum building codes and the applicable regulatory jurisdiction.