


Order Plans

WWW.LDLINE.COM

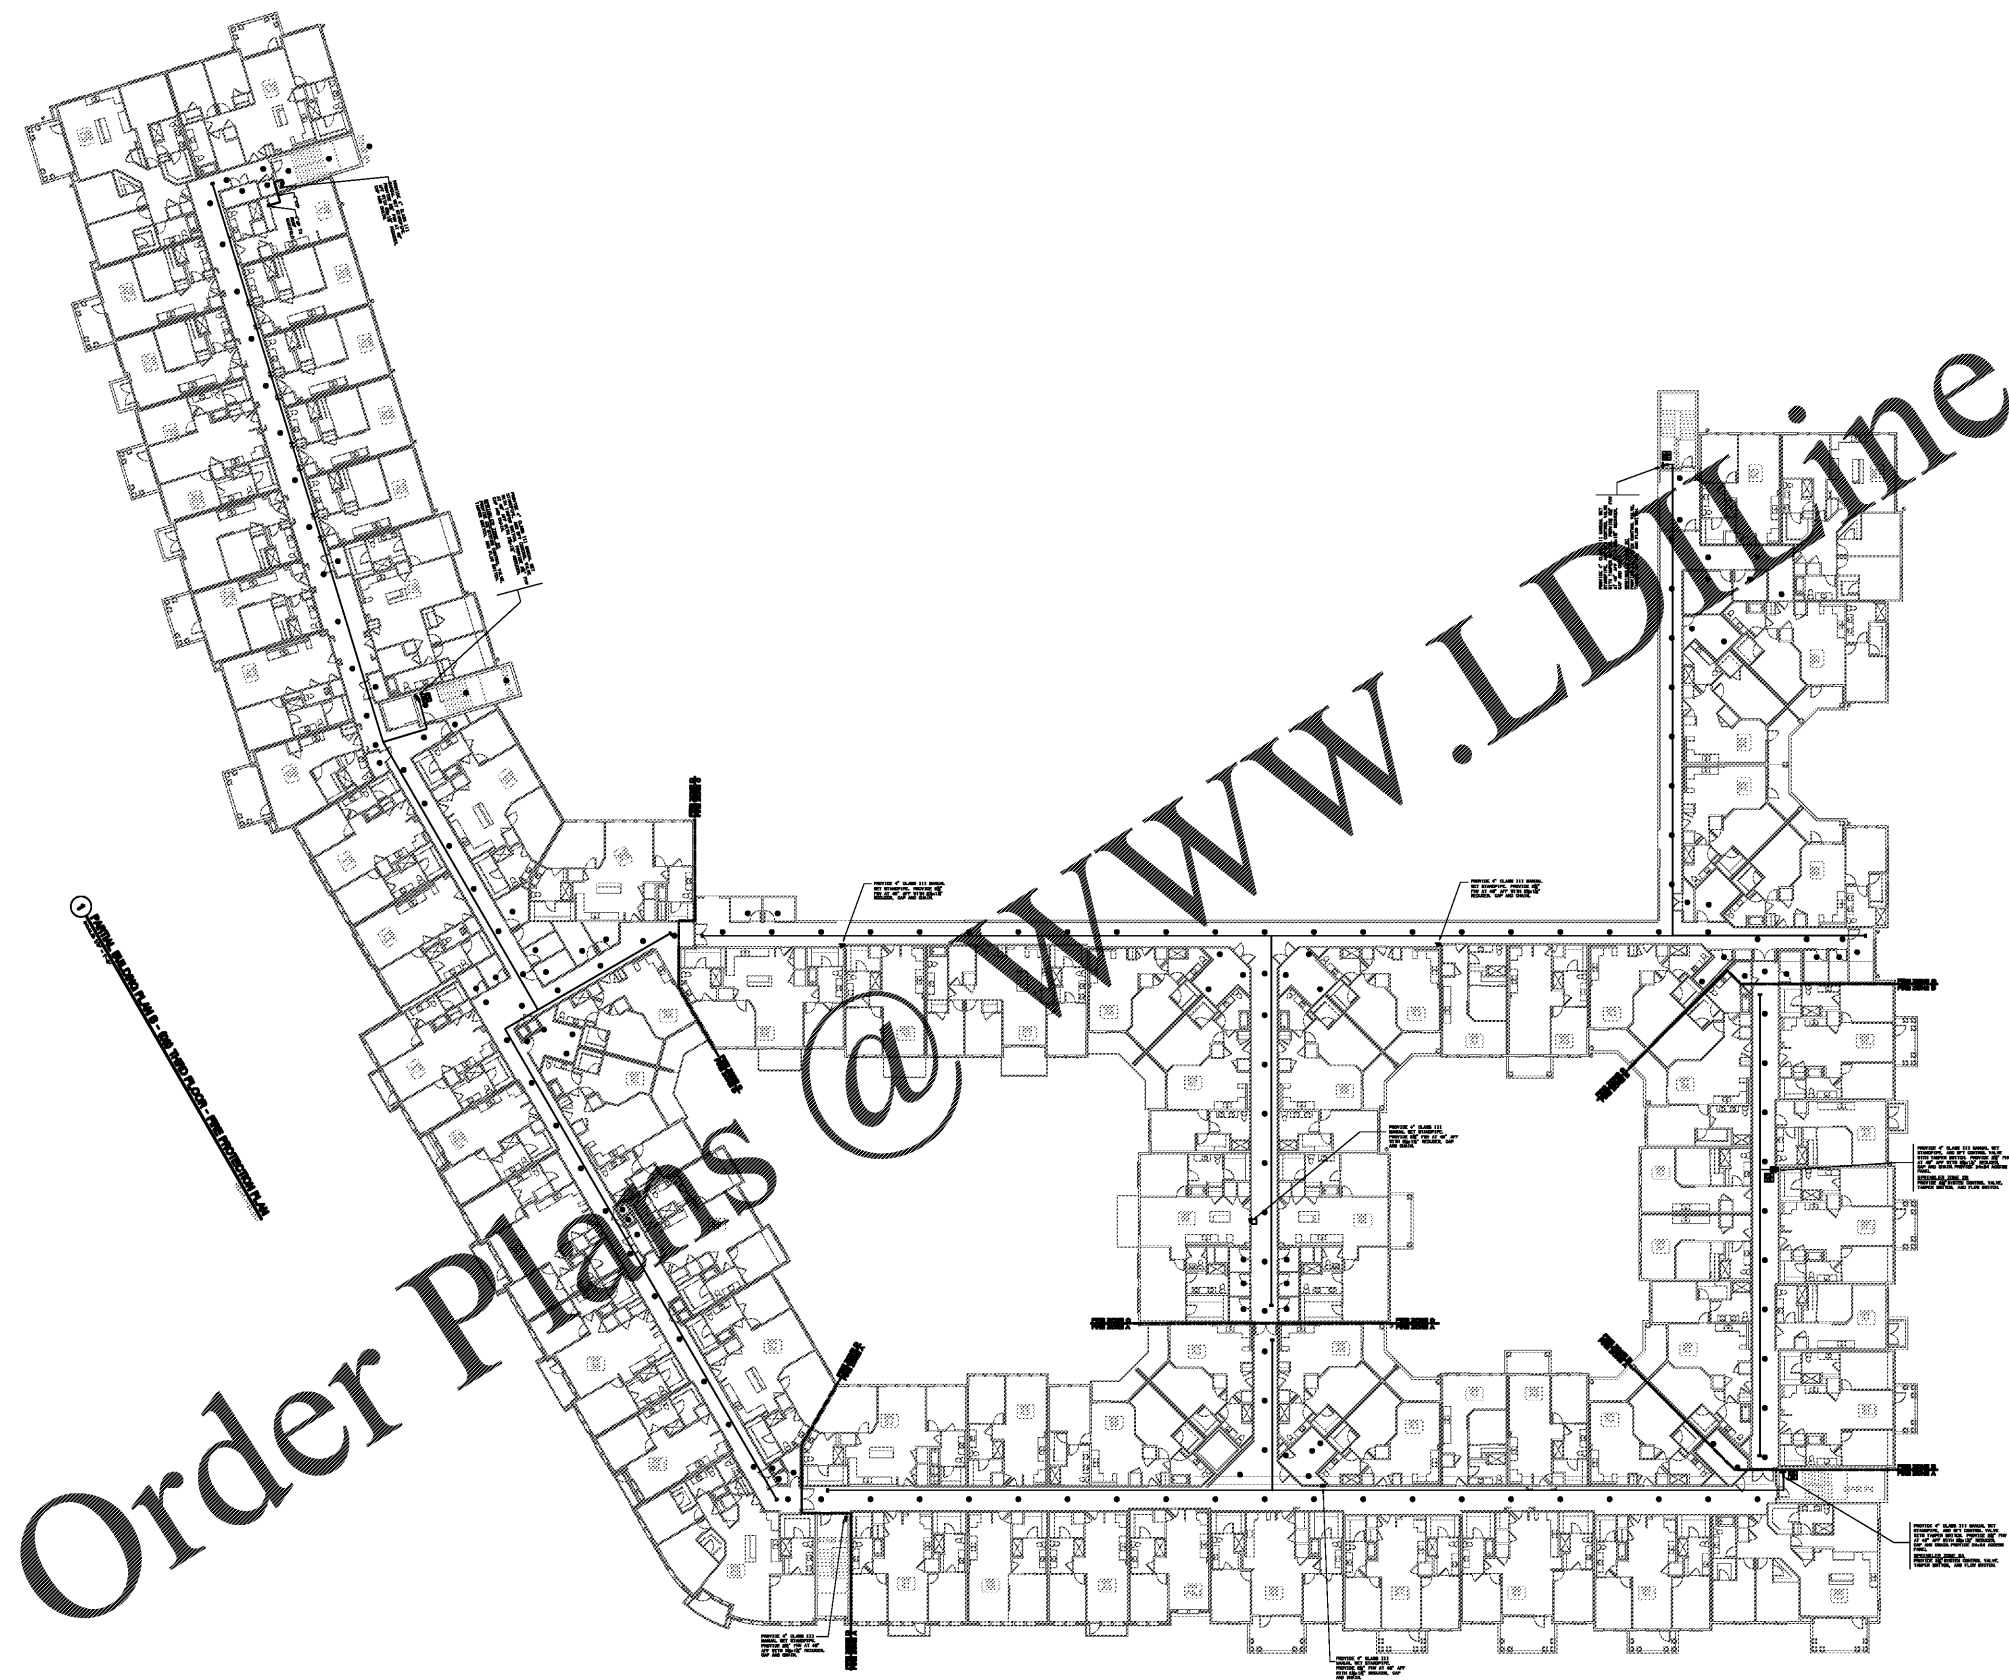

1 PARTIAL BUILDING PLAN C - 030 THIRD FLOOR - FIRE PROTECTION PLAN

1 PARTIAL BUILDING PLAN D - 030 THIRD FLOOR - FIRE PROTECTION PLAN


1 BUILDING TYPE ONE THIRD FLOOR - FIRE PROTECTION PLAN
SCALE: 1" = 25'-0"

180225-PP-030-1.DWG

Common North, Prospect, KY
 KY
 KY



780 FLORIDA CENTRAL PARKWAY
 SUITE 224
 LONGWOOD, FL 32750
 PH: 407.336.7999
 PROJECT #: 18025

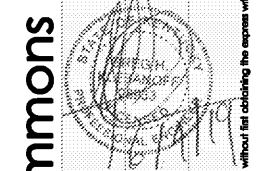

Lyric at Norton Commons
 Prospect, Kentucky

Bristol Development Group
 381 Mallory Station Rd, Suite 204
 Franklin, TN 37067



architects • planners
 1770 fennell street
 maitland florida 32751-7208
 407.660.8900 • 407.875.5948
 www.cbaarchitects.com

BUILDING TYPE ONE
 THIRD FLOOR
 FIRE PROTECTION
 PLAN

date: 06-04-2019
 job no: 3789.15
 drawn by: GNIK
 reviewed by: GNIK
 file: 18025-F-BLDG
 issue history:

F1.13

charlan • brock associates, Inc. hereby reserves its copyright for copyright and other rights in these plans, ideas, and designs. These plans, ideas, and designs are not to be reproduced, changed or copied in any form or manner whatsoever, nor are they to be assigned to any third party, without first obtaining the express written permission from C.B.A., Inc. within dimensions and have precedence over scale dimensions.

MiGre Engineers, LLC - Member of LDLine.com - P.E. - Professional Engineering License No. 2019 by Ryan L. Cooper