
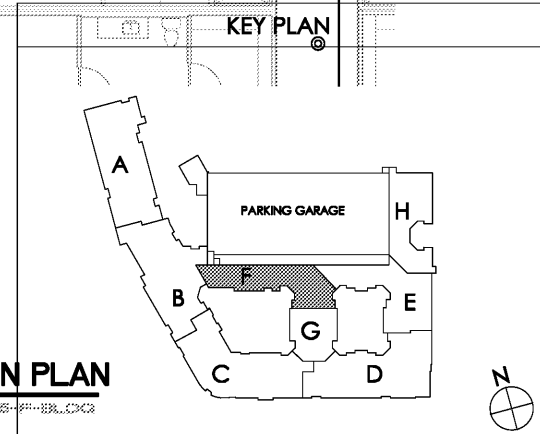


Order Plans @ WWW.LDILine.com

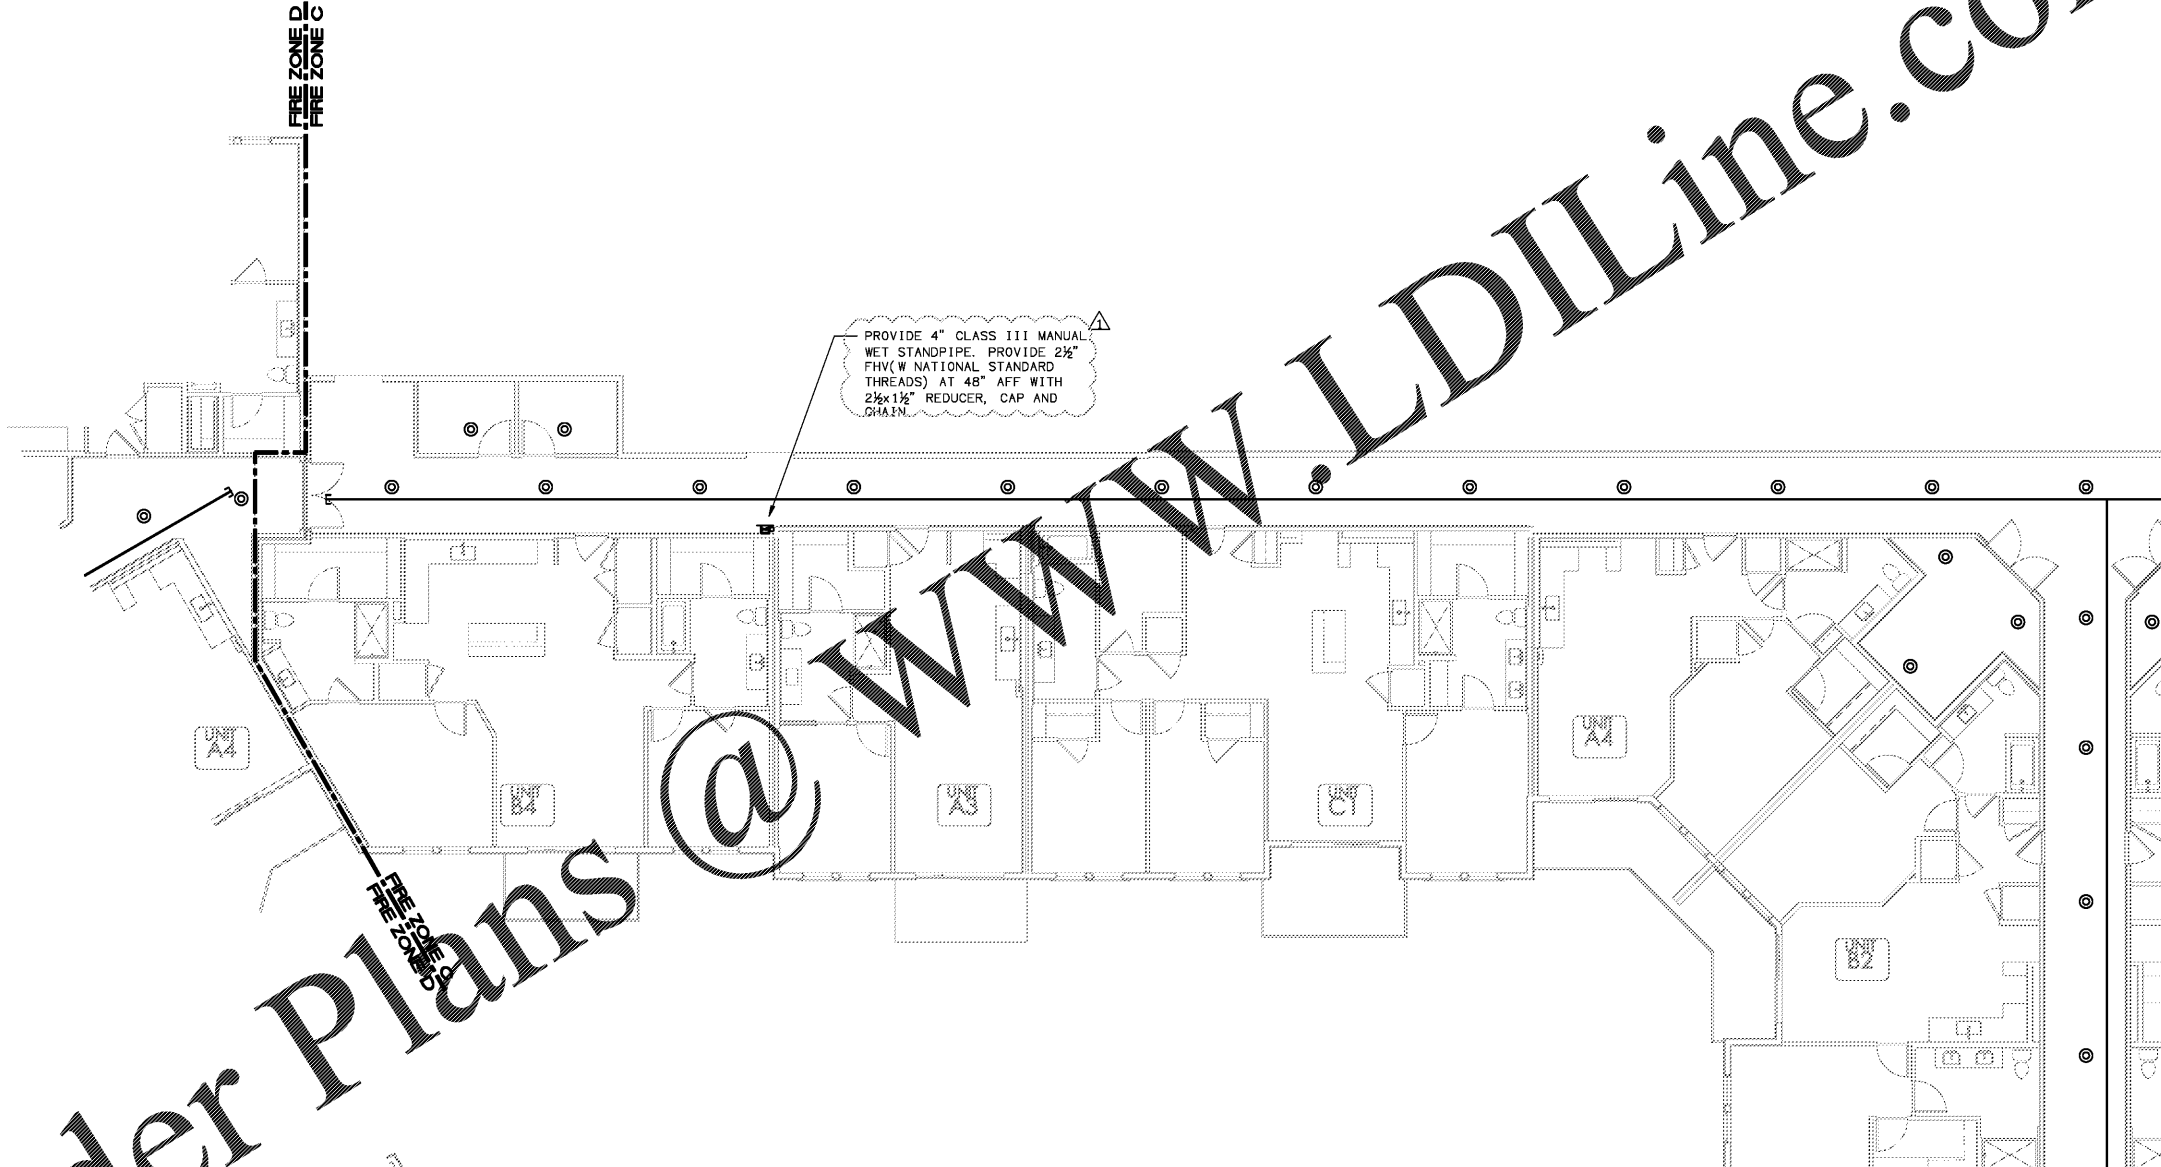

**1 PARTIAL BUILDING PLAN F - (03) THIRD FLOOR - FIRE PROTECTION PLAN**  
 SCALE: 1/8" = 1'-0"  
 18025-F-BLDG

Common North, Prospect, KY

**MiGre**  
 Engineers LLC

780 FLORIDA CENTRAL PARKWAY  
 SUITE 224  
 LONGWOOD, FL 32750  
 PH: 407.336.7999  
 PROJECT #: 18025

**Lyric at Norton Commons**  
 Prospect, Kentucky

Bristol Development Group  
 381 Mallory Station Rd, Suite 204  
 Franklin, TN 37067

**charlan • brock**  
 associates

architects • planners

1770 fennell street  
 maitland florida 32751-7208  
 407.660.8900 • 407.875.5948  
 www.cbaarchitects.com

**PARTIAL BUILDING**  
**PLAN F - 3RD FLOOR**  
**FIRE PROTECTION**  
**PLAN**

date: 06-04-2019  
 job no: 3789.16  
 drawn by: GJK  
 reviewed by: GJK  
 file: 18025-F-BLDG  
 issue history:  
 07-03-2019

**F1.13F**

Charlan Brock Associates, Inc. hereby reserves its copyright in these plans, ideas, and designs. These plans, ideas, and designs are not to be reproduced, changed or copied in any form or manner whatsoever, nor are they to be assigned to any third party, without first obtaining the express written permission from C.B.A., Inc. All dimensions and floor plan dimensions are in feet and inches unless otherwise specified. The plans and specifications comply with the applicable minimum building codes and the applicable regulatory jurisdiction.