



PROVIDE 4" CLASS III MANUAL WET STANDPIPE, AND BFW CONTROL VALVE WITH TAMPER SWITCH. PROVIDE 2 1/2" FHW (W NATIONAL STANDARD THREADS) AT 48" AFF WITH 2 1/2"x1 1/2" REDUCER, CAP AND CHAIN.

SPRINKLER ZONE 2C  
PROVIDE 2 1/2" SYSTEM CONTROL VALVE, TAMPER SWITCH, AND FLOW SWITCH.

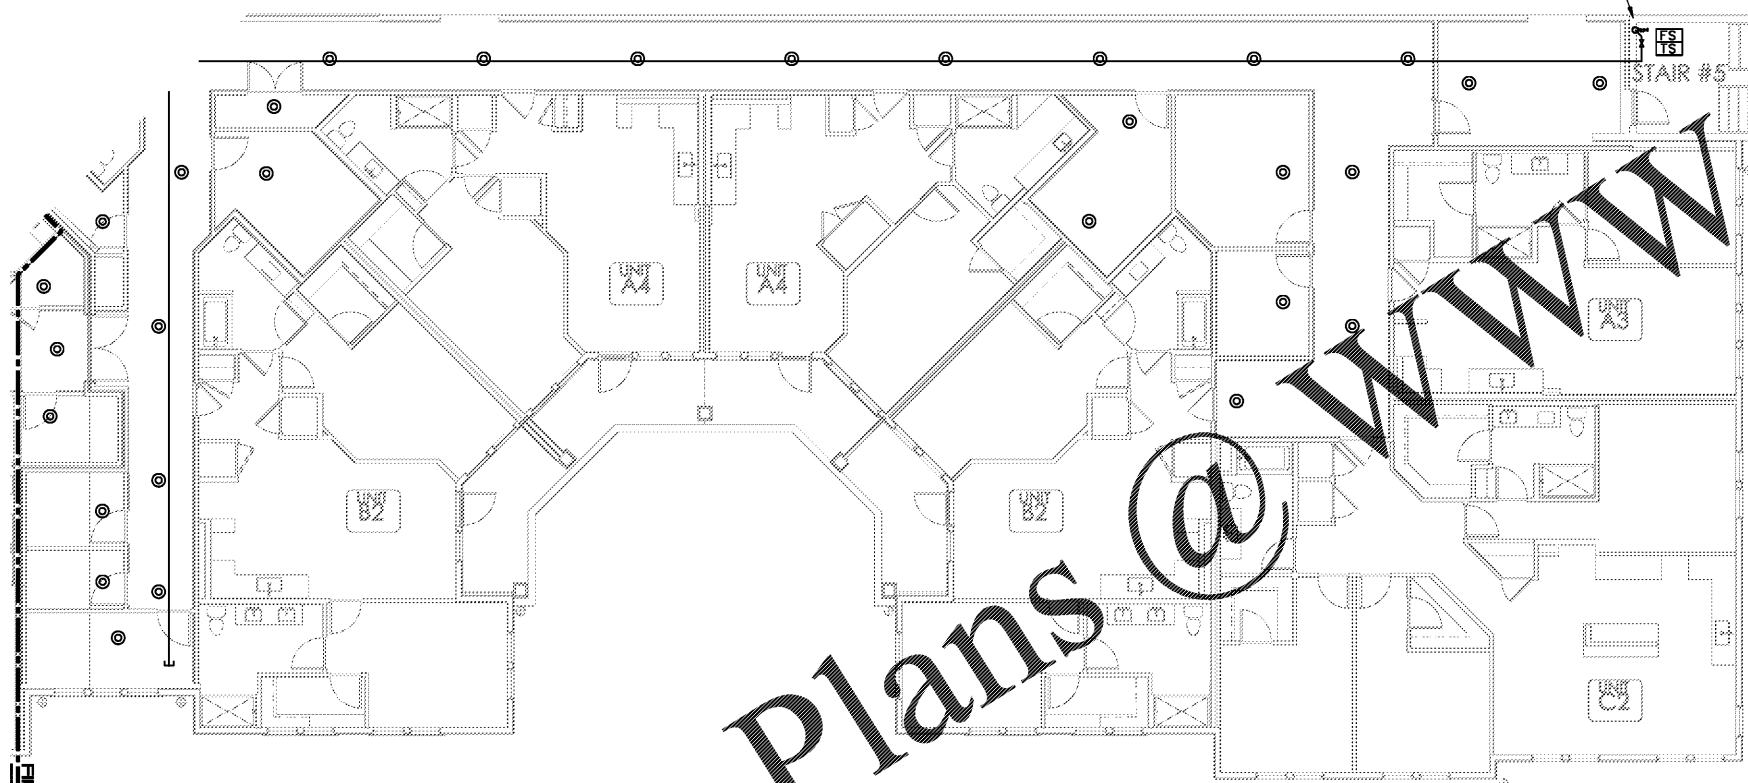

Order Plans @ [www.LDILine.com](http://www.LDILine.com)

**1 PARTIAL BUILDING PLAN H - (03) THIRD FLOOR - FIRE PROTECTION PLAN**  
SCALE 1/8" = 1'-0" 18025-F-BLDG

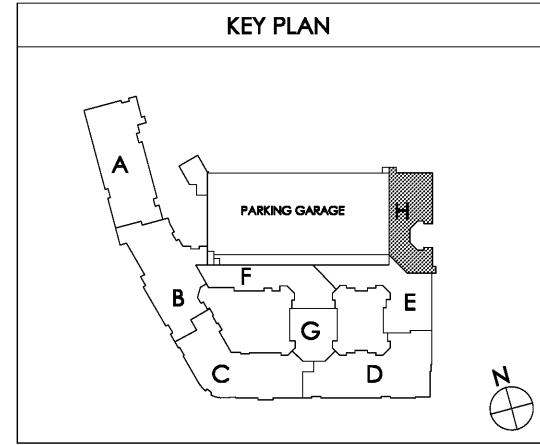

Common North, Prospect, KY  
 Common North, Prospect, KY  
 Architects & Associates, A4000796  
 Common North, Prospect, KY

**MiGre**  
 Engineers LLC  
 780 FLORIDA CENTRAL PARKWAY  
 SUITE 224  
 LONGWOOD, FL 32750  
 PH: 407.336.7999  
 PROJECT #: 18025



**Lyric at Norton Commons**  
 Prospect, Kentucky  
 Bristol Development Group  
 381 Malloy Station Rd, Suite 204  
 Franklin, TN 37067

**charlan • brock**  
 associates  
 architects • planners  
 1770 fennell street  
 maitland florida 32751-7208  
 407.660.8900 • 407.875.5948  
 www.cbaarchitects.com

**PARTIAL BUILDING**  
**PLAN H - 3RD FLOOR**  
**FIRE PROTECTION**  
**PLAN**

date: 06-04-2019  
 job no: 3789.16  
 drawn by: GNIK  
 reviewed by: GNIK  
 file: 18025-F-BLDG  
 issue history:  
 07-03-2019

**F1.13H**

charlan, brock & associates, inc. hereby reserves its copyright in these plans, ideas, and designs. These plans, ideas, and designs are not to be reproduced, changed or copied in any form or manner whatsoever, nor are they to be assigned to any third party, without first obtaining the express written permission from C.B.A., Inc. All dimensions and floor plan dimensions are in feet unless otherwise specified.