
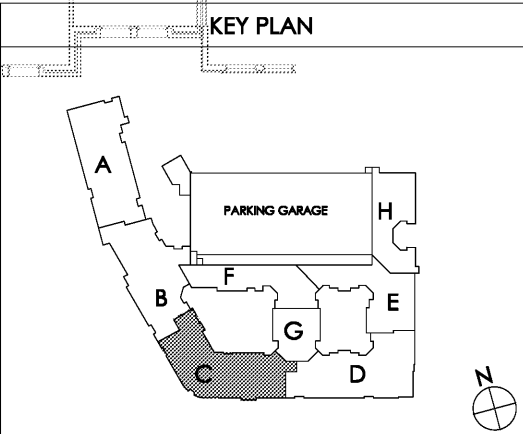


Order Plans @

WWW.LDILine.com

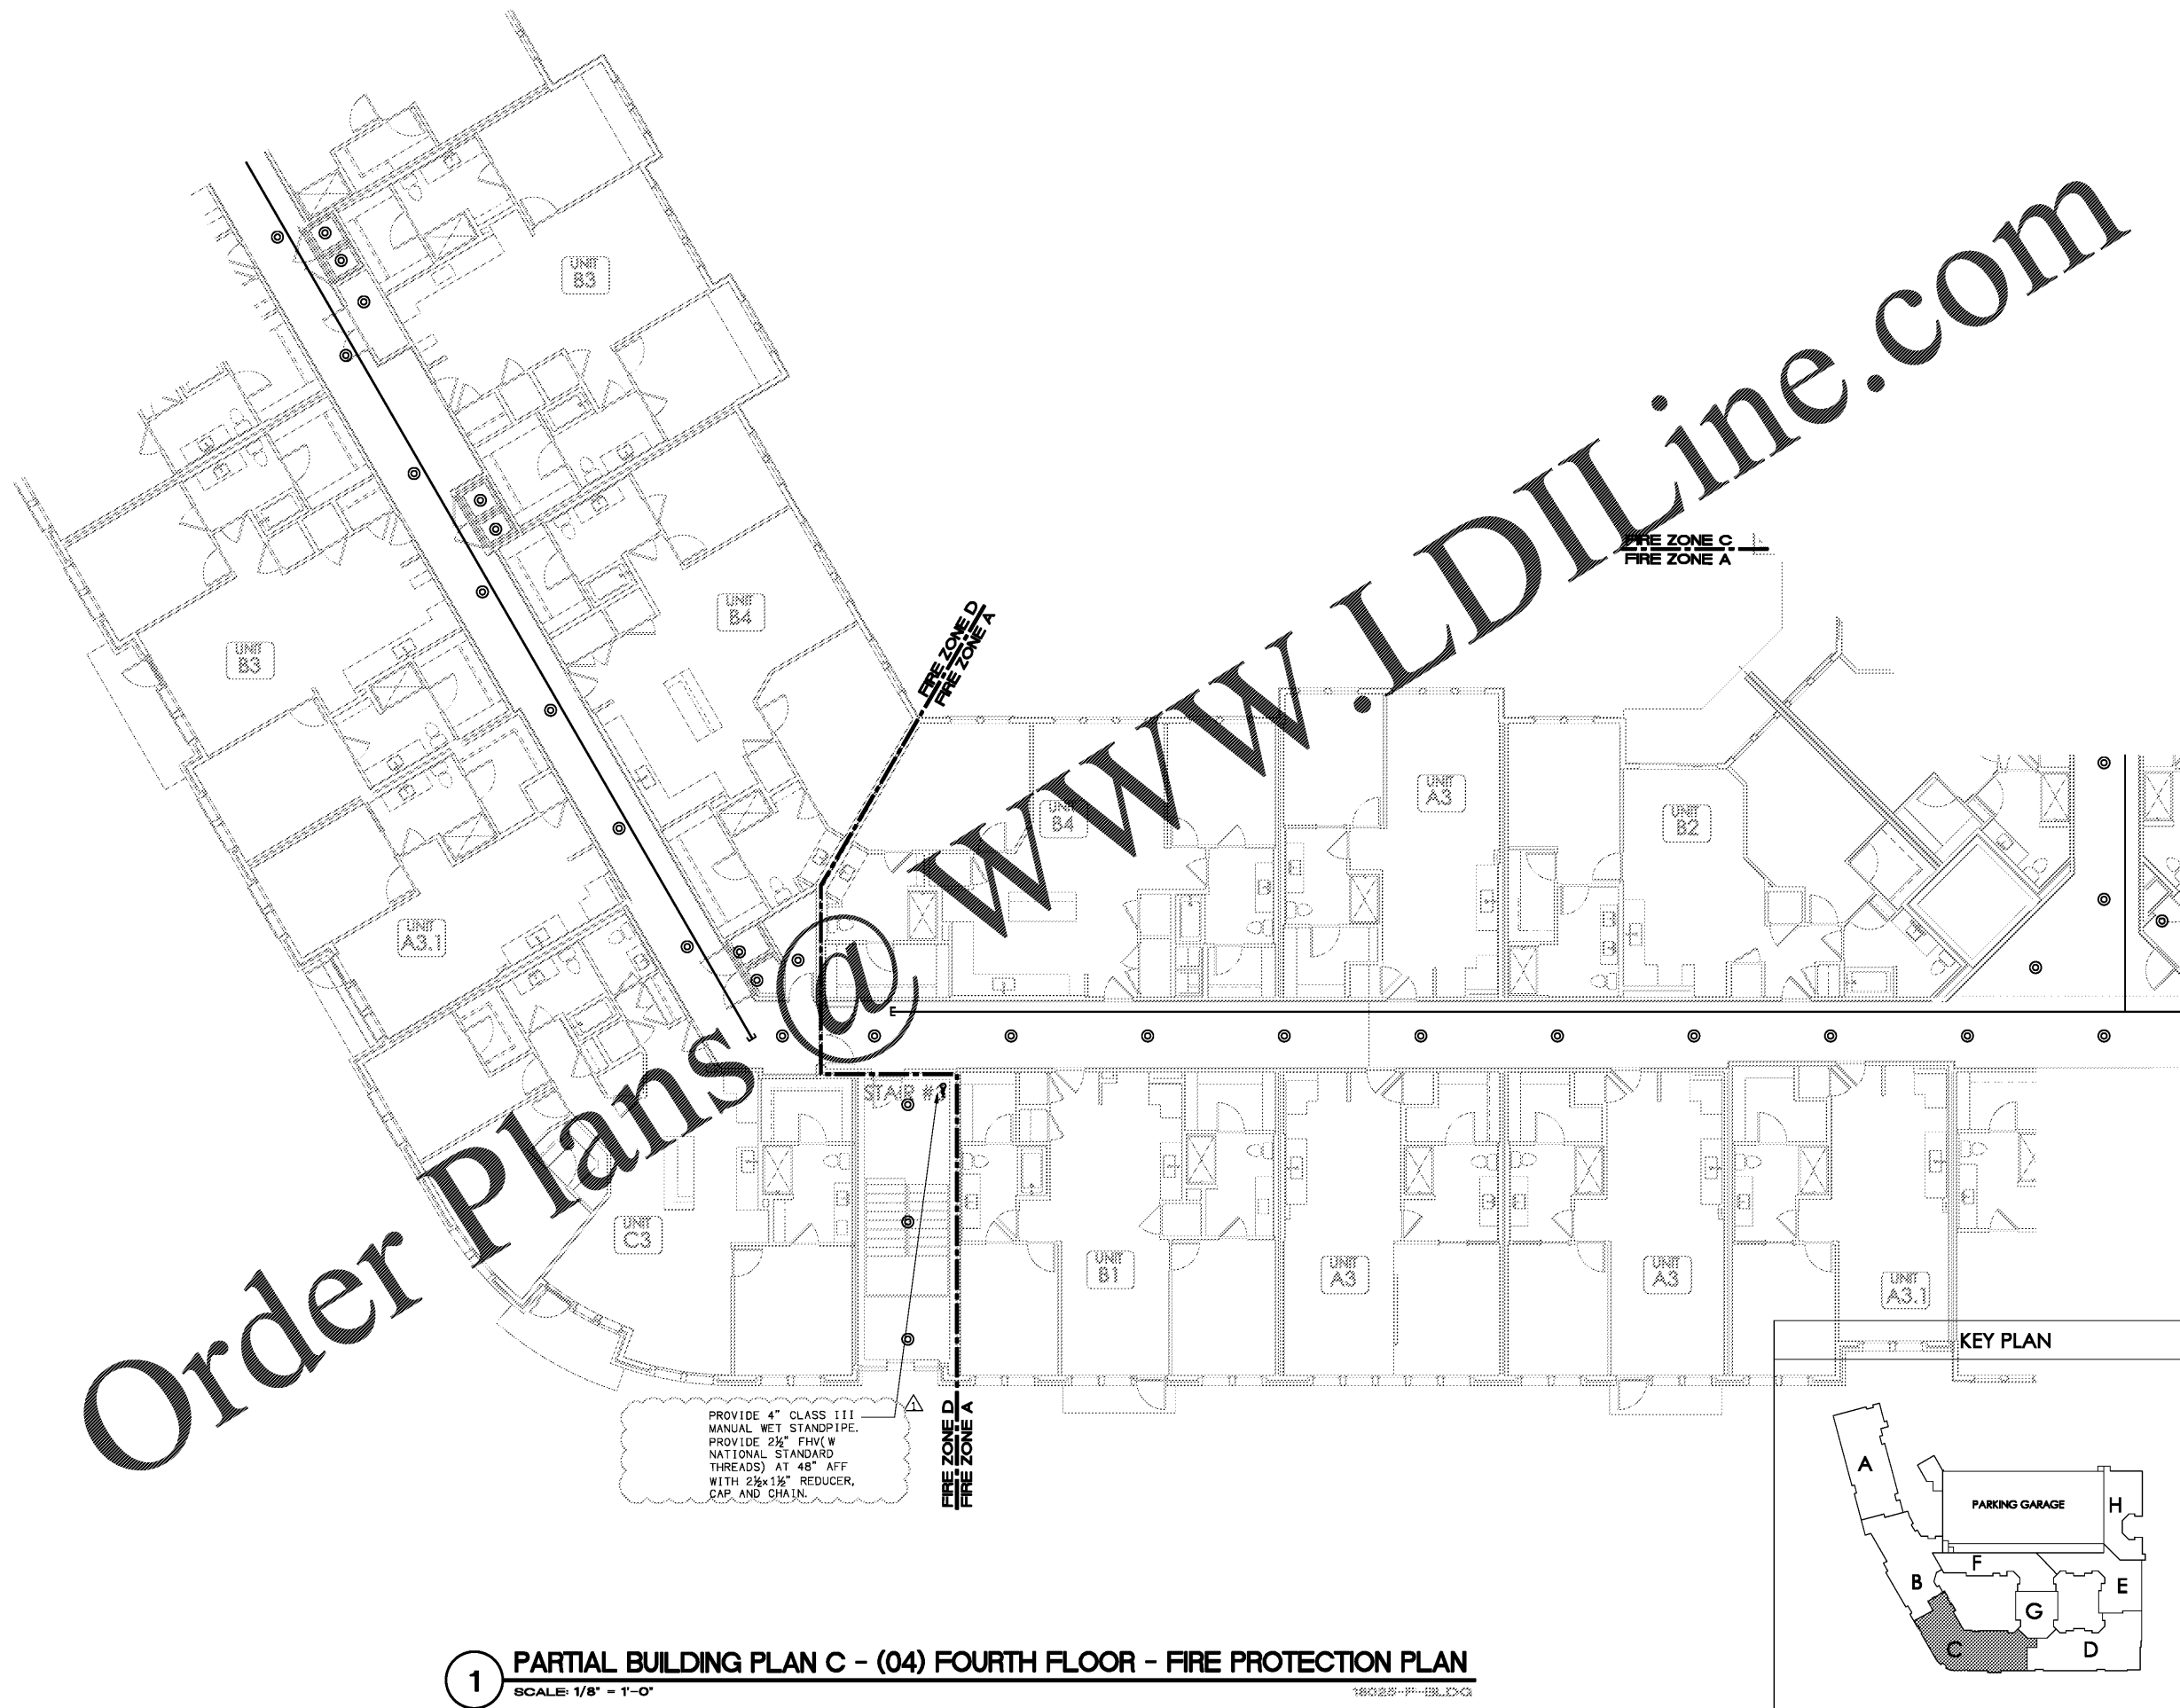

1 PARTIAL BUILDING PLAN C - (04) FOURTH FLOOR - FIRE PROTECTION PLAN
SCALE: 1/8" = 1'-0"

Common North, Prospect, KY

MiGre
Engineers LLC

780 FLORIDA CENTRAL PARKWAY
SUITE 224
LONGWOOD, FL 32750
PH: 407.336.7999
PROJECT #: 18025

STATE OF KENTUCKY
OFFICE OF REGISTERED PROFESSIONAL ENGINEERS
KENTUCKY
20033

Lyric at Norton Commons
Prospect, Kentucky

Bristol Development Group
381 Mallory Station Rd, Suite 204
Franklin, TN 37067

charlan • brock
associates
architects • planners

1770 fennell street
maitland florida 32751-7208
407.660.8900 • 407.875.5948
www.cbaarchitects.com

PARTIAL BUILDING
PLAN C - 4TH FLOOR
FIRE PROTECTION
PLAN

date: 06-04-2019
job no: 3789.16
drawn by: GNIK
reviewed by: GNIK
file: 18025-F-BLDG
issue history:
07-03-2019

F1.14C

Charlan Brock Associates, Inc. hereby reserves its copyright in these plans, specifications, and details. These plans, specifications, and details are the property of Charlan Brock Associates, Inc. and shall remain the property of Charlan Brock Associates, Inc. without dimensions and have precedence over scale dimensions.