



Order Plans @ WWW.LDILine.com

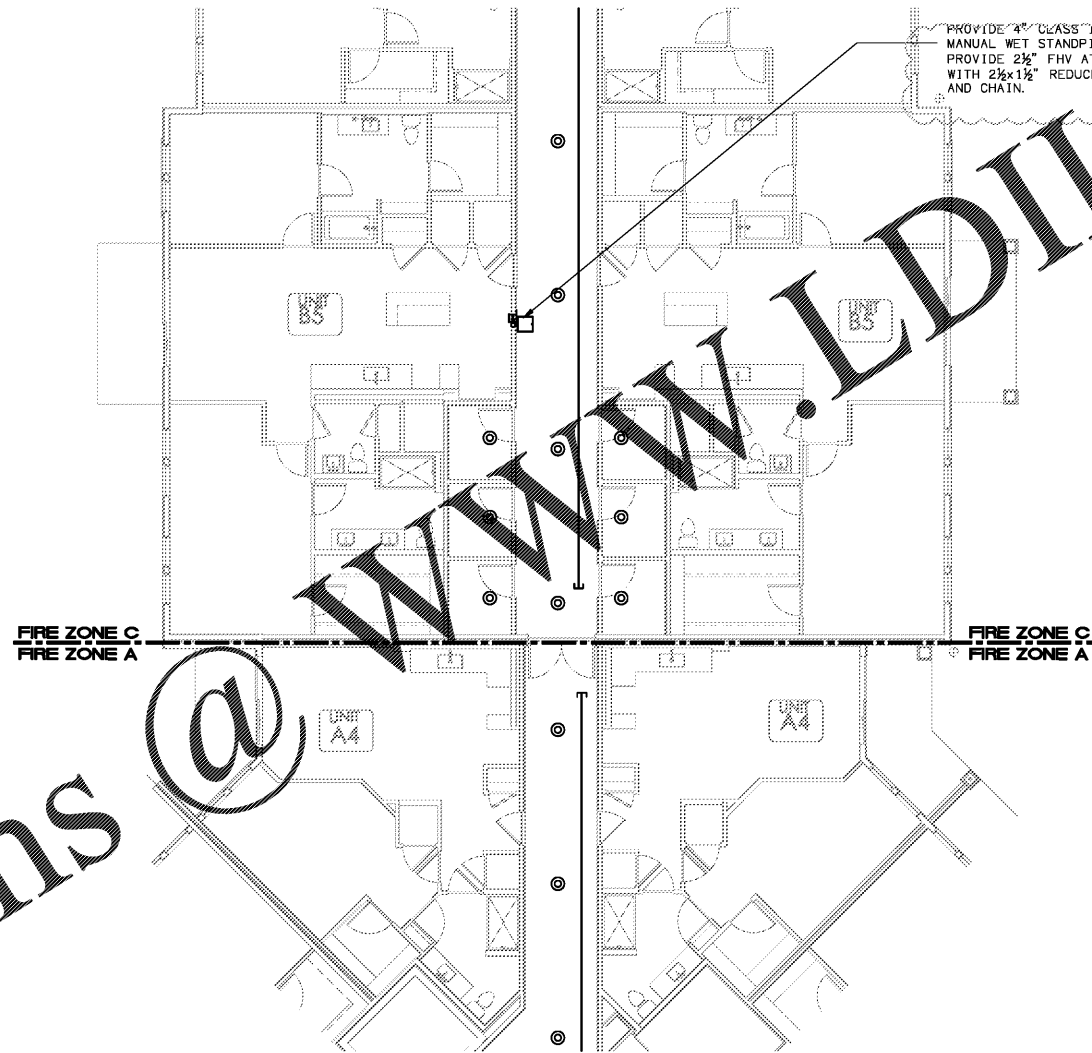

1 PARTIAL BUILDING PLAN G - (04) FOURTH FLOOR - FIRE PROTECTION PLAN
 SCALE: 1/8" = 1'-0"

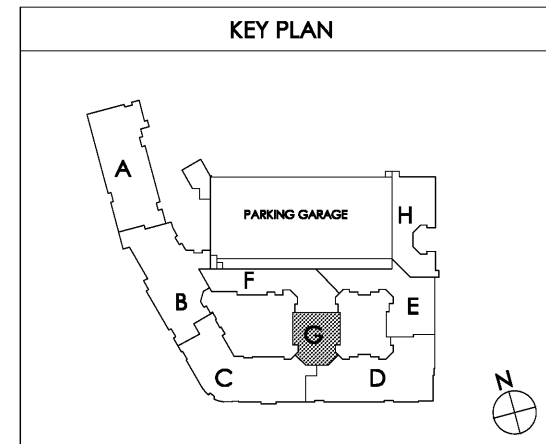

Common North, Prospect, KY
 KY
 Architect: Norton Commons
 Prospect, Kentucky
 Project #: 18025

MiGre
 Engineers LLC
 780 FLORIDA CENTRAL PARKWAY
 SUITE 224
 LONGWOOD, FL 32750
 PH: 407.336.7999
 PROJECT #: 18025

Lyric at Norton Commons
 Prospect, Kentucky
 Bristol Development Group
 381 Mallory Station Rd, Suite 204
 Franklin, TN 37067

charlan • brock
 associates
 architects • planners
 1770 fennell street
 maitland florida 32751-7208
 407.660.8900 • 407.875.5948
 www.cbaarchitects.com

PARTIAL BUILDING
 PLAN G - 4TH FLOOR
 FIRE PROTECTION
 PLAN

date: 06-04-2019
 job no: 3789.16
 drawn by: GNIK
 reviewed by: GNIK
 file: 18025-F-BLDG
 issue history:
 07-03-2019

F1.14G

This drawing is the property of the engineer and shall not be reproduced, changed or copied in any form or manner whatsoever, nor are they to be employed in any field party, without first obtaining the express written permission from C.B.A., Inc. within dimensions and have precedence over scale dimensions.