



www.migre.com

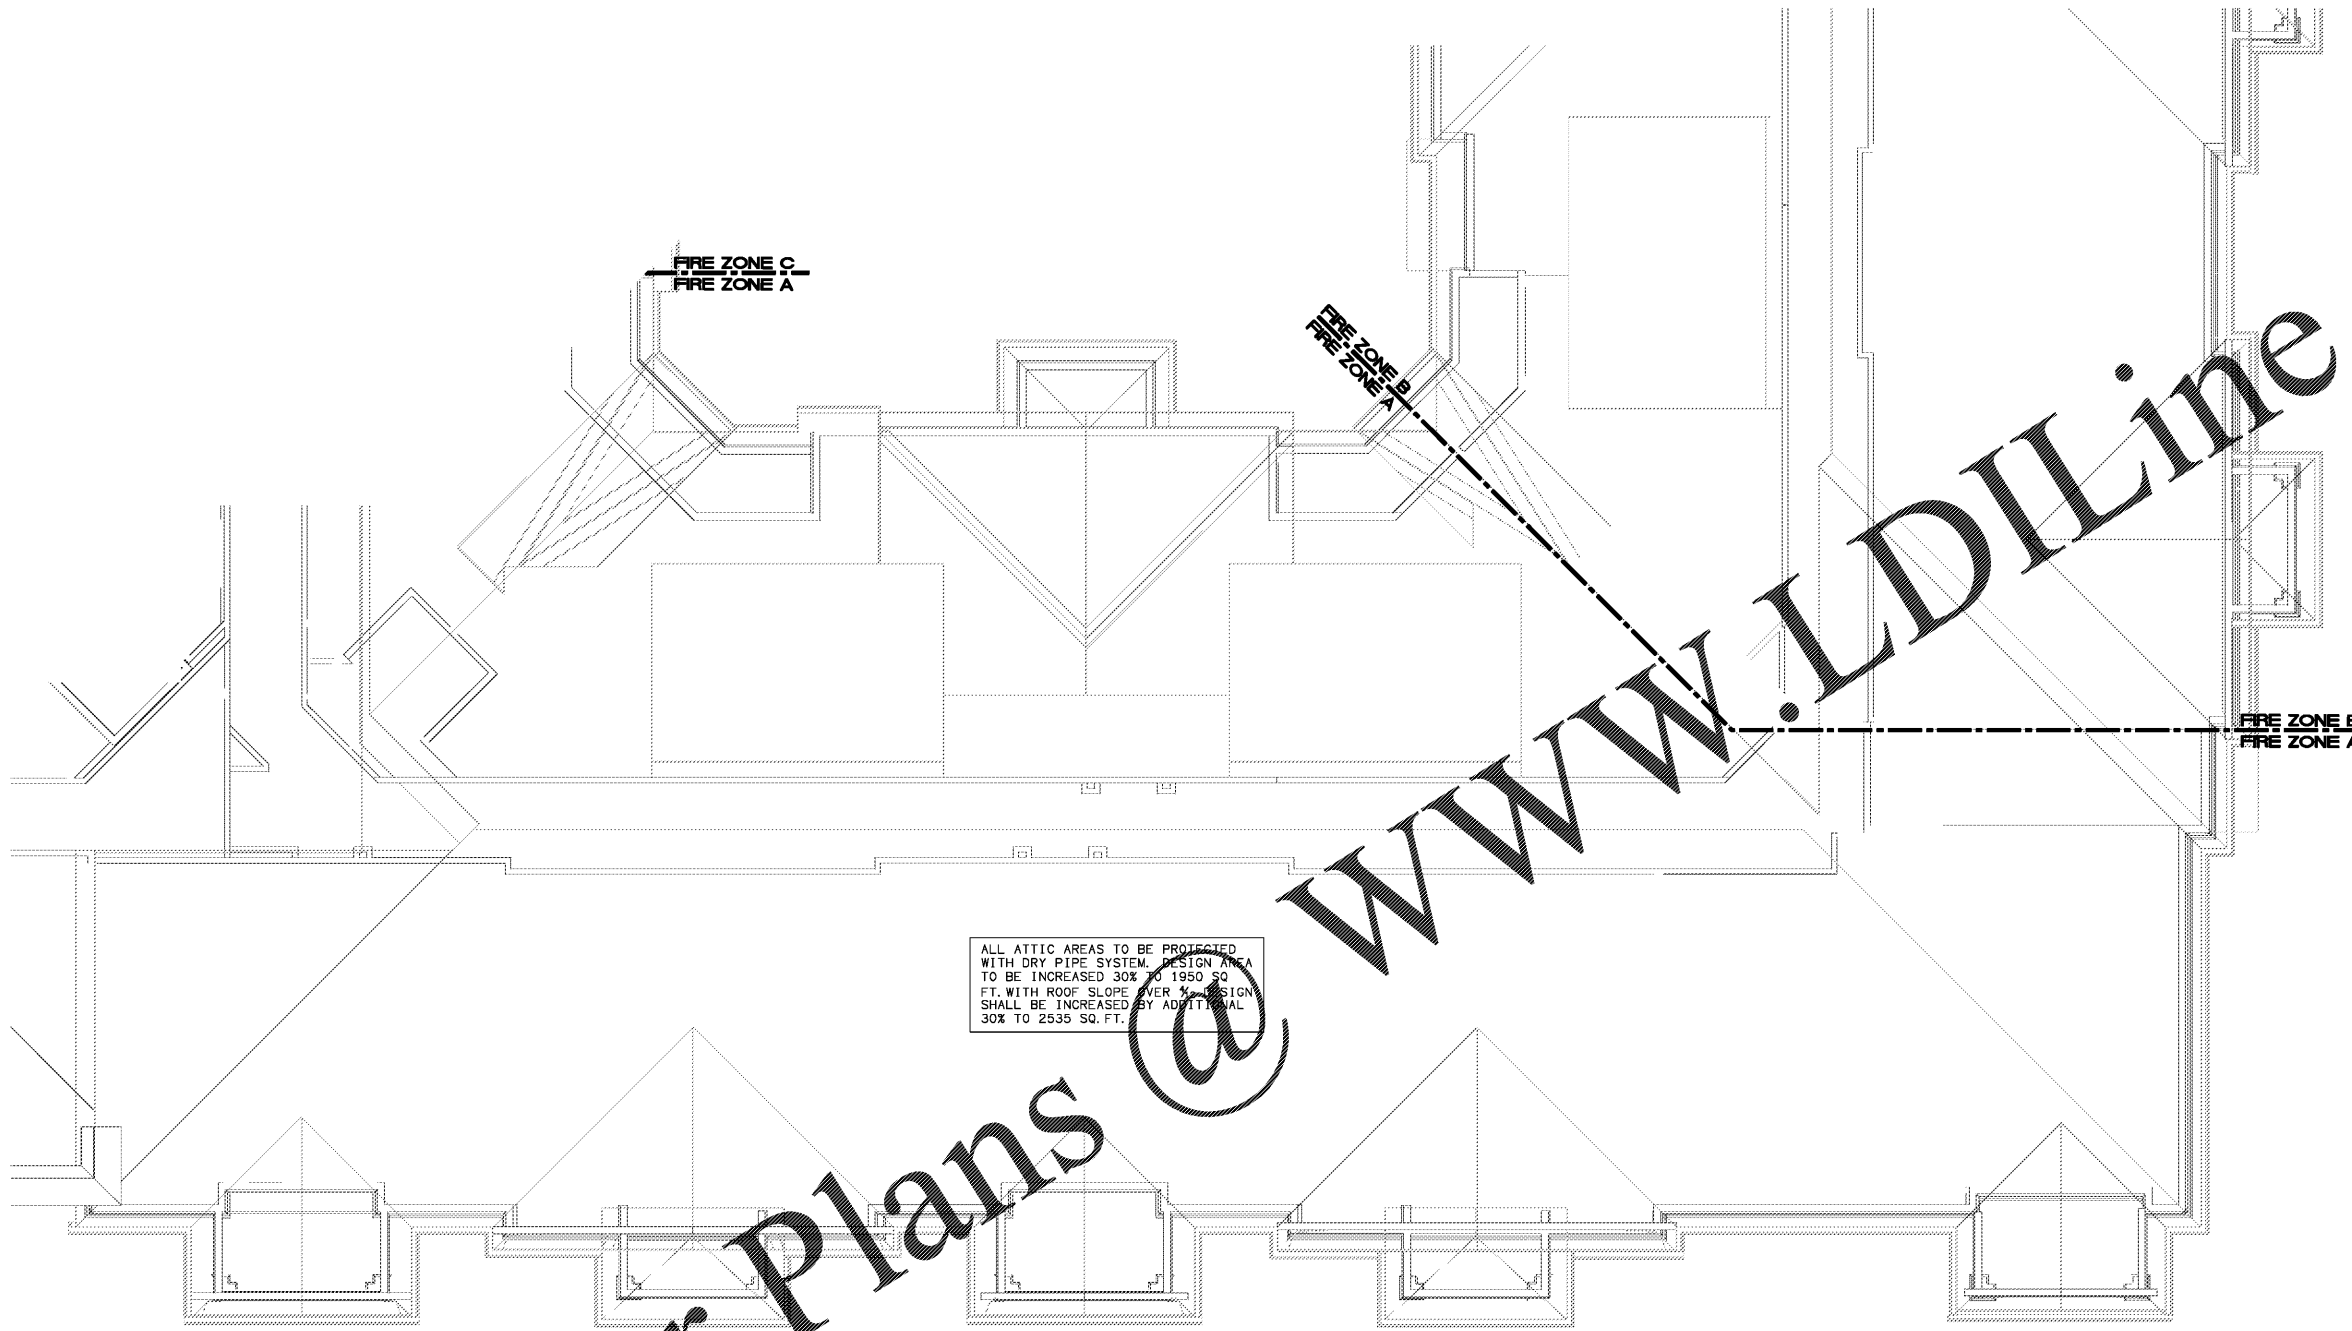


ALL ATTIC AREAS TO BE PROTECTED WITH DRY PIPE SYSTEM. DESIGN AREA TO BE INCREASED 30% TO 1950 SQ. FT. WITH ROOF SLOPE OVER 1/2". DESIGN SHALL BE INCREASED BY ADDITIONAL 30% TO 2535 SQ. FT.

Order Plans @ WWW.LDILine.com

1 PARTIAL BUILDING PLAN D - (05) ROOF - FIRE PROTECTION PLAN
SCALE: 1/8" = 1'-0" 18025-F-BLDG

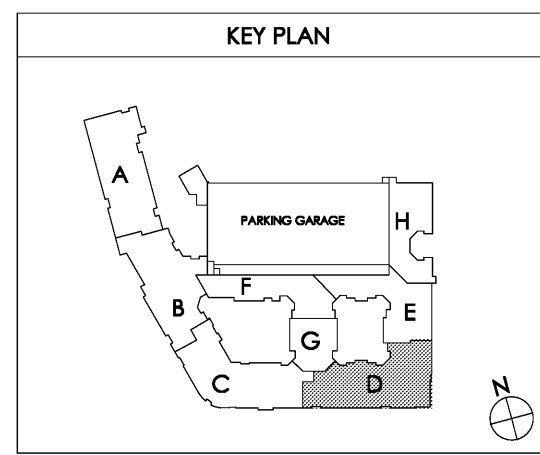

Common North, Prospect, KY
MIGRE Engineers LLC
780 FLORIDA CENTRAL PARKWAY SUITE 224
LONGWOOD, FL 32750
PH: 407.336.7999
PROJECT #: 18025

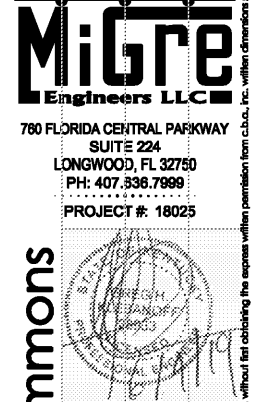

Lyric at Norton Commons
Prospect, Kentucky
Bristol Development Group
381 Malley Station Rd, Suite 204
Franklin, TN 37067

charlan • brock
associates
architects • planners
1770 fennell street
maitland florida 32751-7208
407.660.8900 ; 407.875.5948
www.cbaarchitects.com

PARTIAL BUILDING
PLAN D - ROOF
FIRE PROTECTION
PLAN

date: 06-04-2019
job no: 3789.16
drawn by: GNIK
reviewed by: GNIK
file: 18025-F-BLDG
issue history:

F1.15D

Charlan Brock, Inc. hereby reserves its copyright in these plans, ideas, and designs. These plans, ideas, and designs are not to be reproduced, changed or copied in any form or manner whatsoever, nor are they to be assigned to any third party, without first obtaining the express written permission from C.B.A., Inc. All dimensions and floor plan dimensions are in feet and inches unless otherwise specified. The plans and specifications comply with the applicable minimum building codes and the applicable regulatory jurisdiction.