



Order Plans @ WWW.LDILine.com

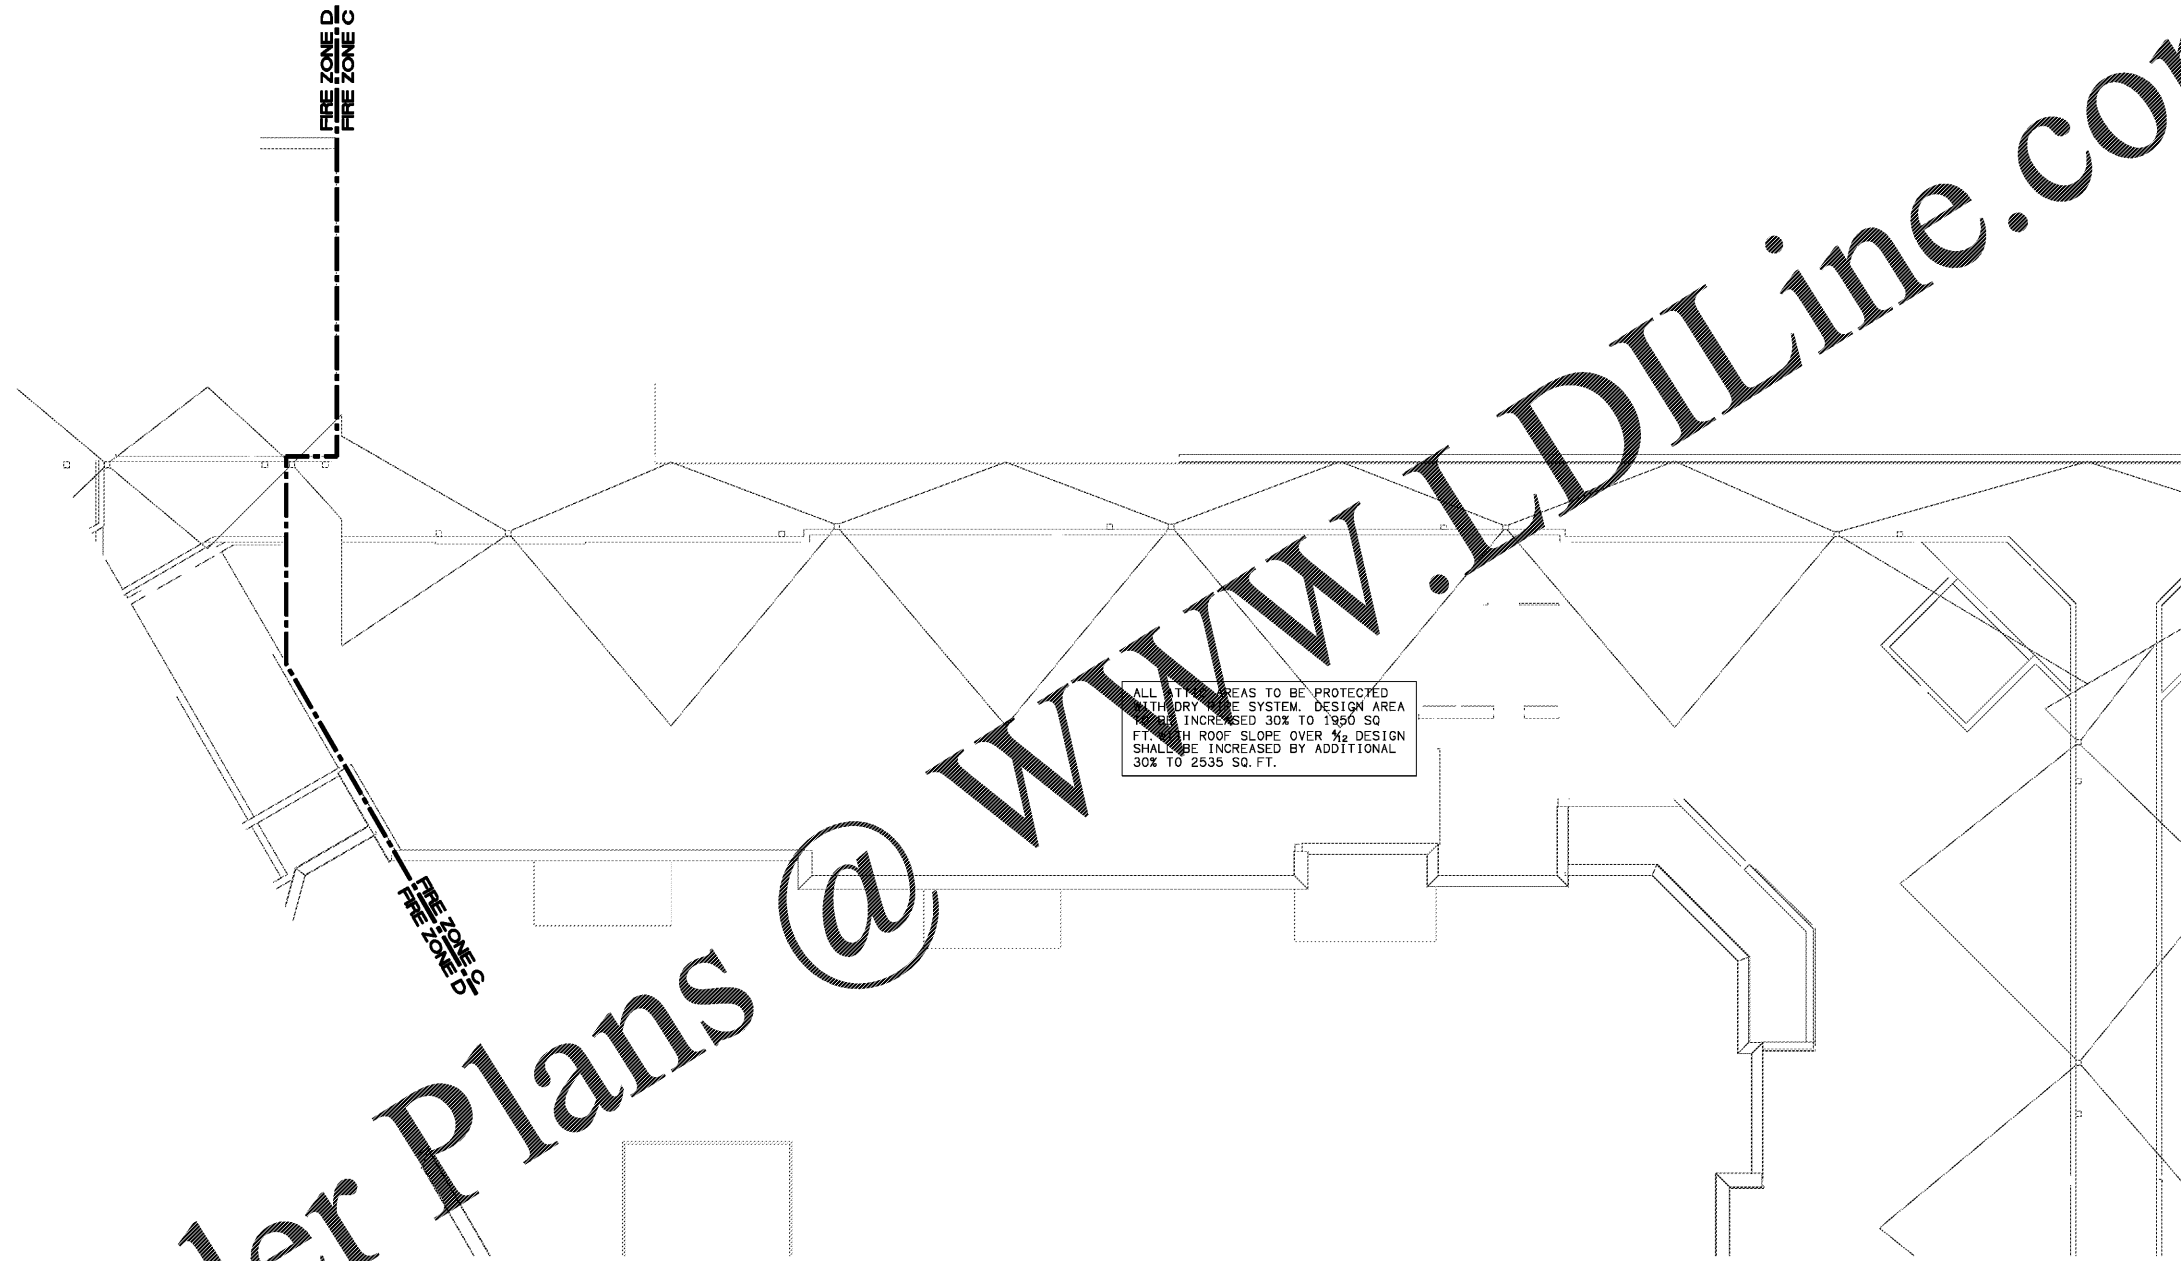

1 PARTIAL BUILDING PLAN F - (05) ROOF - FIRE PROTECTION PLAN
SCALE: 1/8" = 1'-0"

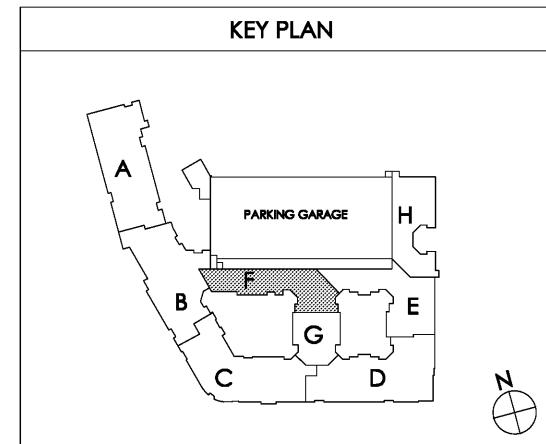


Common North, Prospect, KY



MiGre
Engineers LLC

780 FLORIDA CENTRAL PARKWAY
SUITE 224
LONGWOOD, FL 32750
PH: 407.336.7999
PROJECT #: 18025

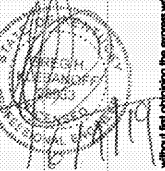

Lyric at Norton Commons
Prospect, Kentucky

Bristol Development Group
381 Mallory Station Rd, Suite 204
Franklin, TN 37067

charlan • brock
associates

architects • planners
1770 fennell street
maitland florida 32751-7208
407.660.8900 • 407.875.5948
www.cbaarchitects.com

PARTIAL BUILDING
PLAN F - ROOF
FIRE PROTECTION
PLAN

date: 06-04-2019
job no: 3789.16
drawn by: GNIK
reviewed by: GNIK
file: 18025-F-BLDG
issue history:

F1.15F

charlan • brock associates, Inc. hereby reserves all copyright, trademark, trade name, design, and other rights in these drawings, ideas, and designs. These drawings, designs, and plans are not to be reproduced, changed or copied in any form or manner whatsoever, nor are they to be assigned to any third party, without first obtaining the express written permission from C.B.A., Inc. within dimensions and have precedence over local dimensions.