



Order Plans @ WWW.IDILine.com

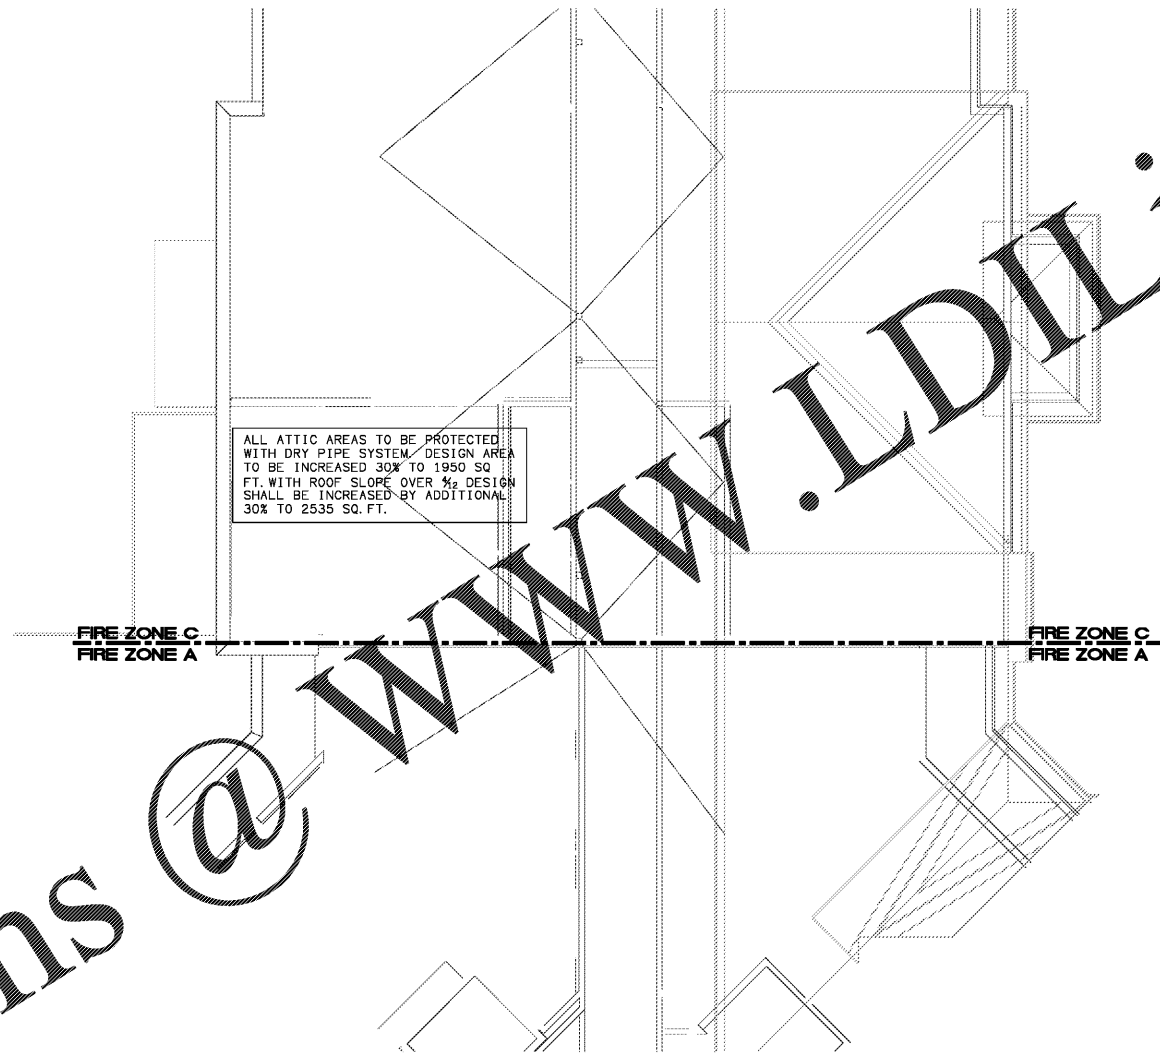

1 PARTIAL BUILDING PLAN G - (05) ROOF - FIRE PROTECTION PLAN
SCALE: 1/8" = 1'-0" 8028-F-BLDG

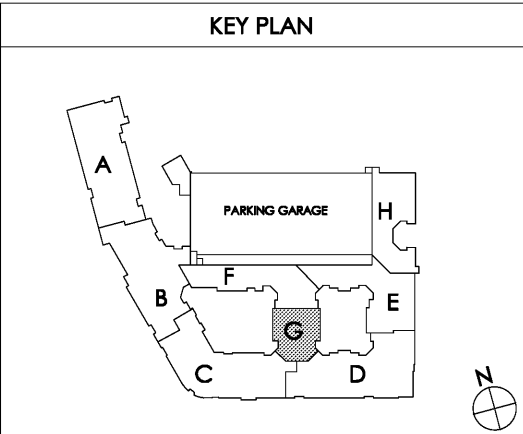

Common North, Prospect, KY

MiGre
Engineers LLC

780 FLORIDA CENTRAL PARKWAY
SUITE 224
LONGWOOD, FL 32750
PH: 407.336.7999
PROJECT #: 18025

Lyric at Norton Commons
Prospect, Kentucky

Bristol Development Group
381 Mallory Station Rd, Suite 204
Franklin, TN 37067

charlan • brock
associates
architects • planners

1770 fennell street
maitland florida 32751-7208
407.660.8900 • 407.875.5948
www.cbaarchitects.com

PARTIAL BUILDING
PLAN G - ROOF
FIRE PROTECTION
PLAN

date: 06-04-2019
job no: 3789.16
drawn by: GNIK
reviewed by: GNIK
file: 18025-F-BLDG
issue history:

F1.15G

Architect's Name: Charlan Brock & Associates, A4000796
I.C., within dimensions and have precedence over scale dimensions.