



**FIRE PROTECTION GENERAL NOTES - NFPA 13 SYSTEM**

1. THE INTENT OF THESE DRAWING IS TO SHOW SPRINKLER HEAD LOCATIONS THAT HAVE BEEN COORDINATED WITH OTHER ENGINEERING TRADES (ELECTRICAL AND HVAC). IT IS THE INSTALLING CONTRACTOR THAT IS RESPONSIBLE COMPLETING FULLY COORDINATED DRAWINGS THAT INCLUDE THE PIPING LAYOUT AND HYDRAULIC CALCULATIONS.
2. ALL FIRE SPRINKLER SYSTEMS SHALL BE MONITORED BY AN APPROVED SUPERVISING STATION IN ACCORDANCE WITH NFPA 72
3. THIS BUILDING TO BE PROTECTED IN ACCORDANCE WITH NFPA-13 2013 EDITION AND 2012 IBC AND 2012 IFC
4. ALL DWELLING UNITS TO BE HYDRAULICALLY DESIGNED TO PROVIDE 0.05 DENSITY RATED UP TO 100 FT SPRINKLERS WITH A CONSTRUCTION CREATING THE GREATEST HYDRAULIC DEMAND USING 5" 150 LB GALLON SIDEWALL SPRINKLERS OR 4.9K DEMAND SPRINKLERS SPACED IN ACCORDANCE WITH THEIR LISTING. SPRINKLERS MAY BE OMITTED IN THE FOLLOWING AREAS IN ACCORDANCE WITH:
  - A. BATHROOMS UNDER 55 SQ. FT.
  - B. CLOTHES, LINEN CLOSETS AND PANTRIES UNDER 12 SQ. FT.
  - C. ATTICS, CRAWL SPACES, FLOOR/CEILING SPACES AND ALL OTHER CONCEALED SPACES THAT ARE NOT USED OR INTENDED FOR LIVING PURPOSES OR STORAGE.
6. ALL SOFFITS THAT ARE 8" OR GREATER IN WIDTH SHALL BE PROTECTED BELOW BY PENDANT SPRINKLERS, WITH A SIDEWALL SPRINKLER INSTALLED ON THE FACE OF THE SOFFIT TO WITHIN 4"-6" OF THE CEILING. IF THE SOFFIT IS LESS THAN 8" IN WIDTH, THEN SPRINKLERS BENEATH CAN BE OMITTED.
7. SPRINKLERS ARE REQUIRED ON ALL PORCHES, OR BALCONIES, THAT ARE OPEN AND ATTACHED.
8. COMBUSTIBLE CONCEALED SPACES: SPRINKLERS ARE NOT REQUIRED IN ALL COMBUSTIBLE CONCEALED SPACES THAT ARE FILLED ENTIRELY WITH NON COMBUSTIBLE INSULATION. THE BUILDING OWNER IS TO BE RESPONSIBLE TO MEET THE REQUIREMENTS OF NFPA-13, SECTION 8.15.1.2.7: CONCEALED SPACES ENTIRELY FILLED WITH NONCOMBUSTIBLE INSULATION SHALL NOT REQUIRE SPRINKLER PROTECTION. SECTION 8.15.1.2.7: CONCEALED SPACES WITHIN WOOD JOIST CONSTRUCTION AND COMPOSITE WOOD JOIST CONSTRUCTION HAVING NONCOMBUSTIBLE INSULATION FILLING THE SPACE FROM THE CEILING UP TO THE BOTTOM EDGE OF THE JOIST OF THE ROOF DECK, PROVIDED THAT IN COMPOSITE WOOD JOIST CONSTRUCTION THE JOIST CHANNELS ARE FIRE STOPPED INTO VOLUMES EACH NOT EXCEEDING 160 SQ. FT. TO THE FULL DEPTH OF THE JOIST WITH MATERIAL EQUIVALENT TO THE WEB CONSTRUCTION, SHALL NOT REQUIRE SPRINKLER PROTECTION.

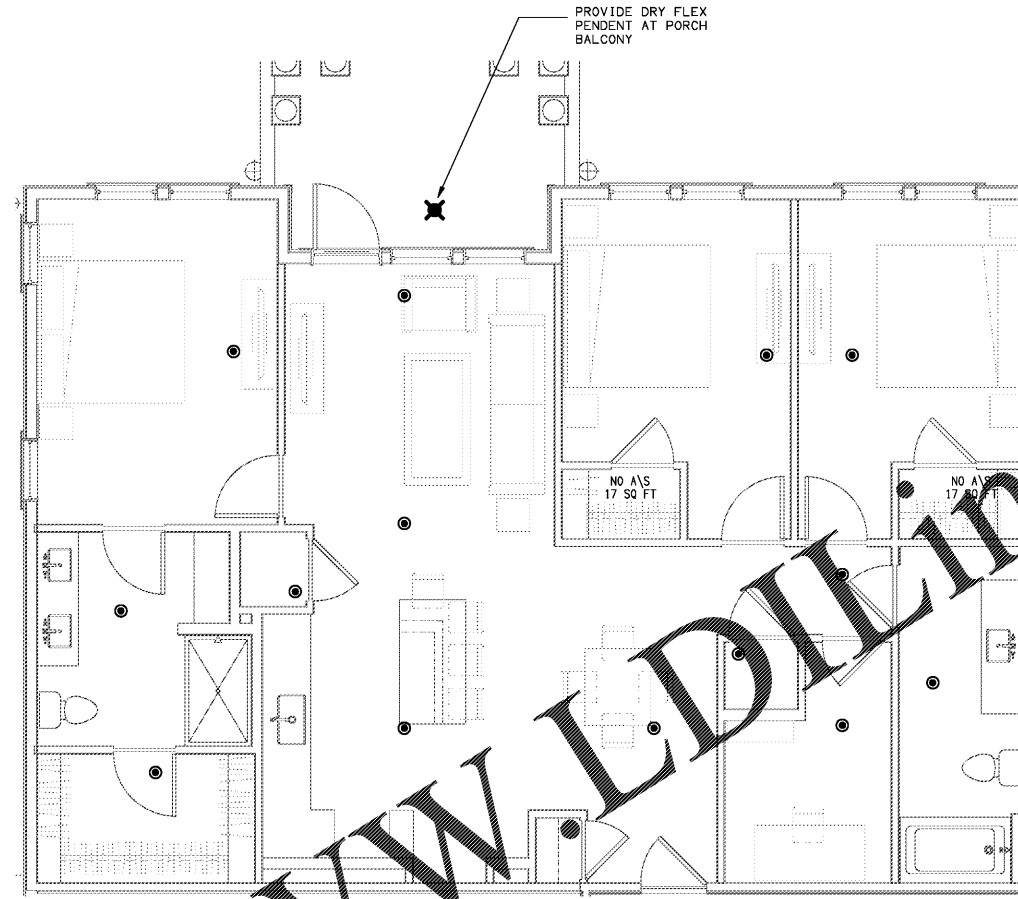

 
**1 UNIT C1 - FIRE PROTECTION PLAN**  
SCALE: 1/4"=1'-0"

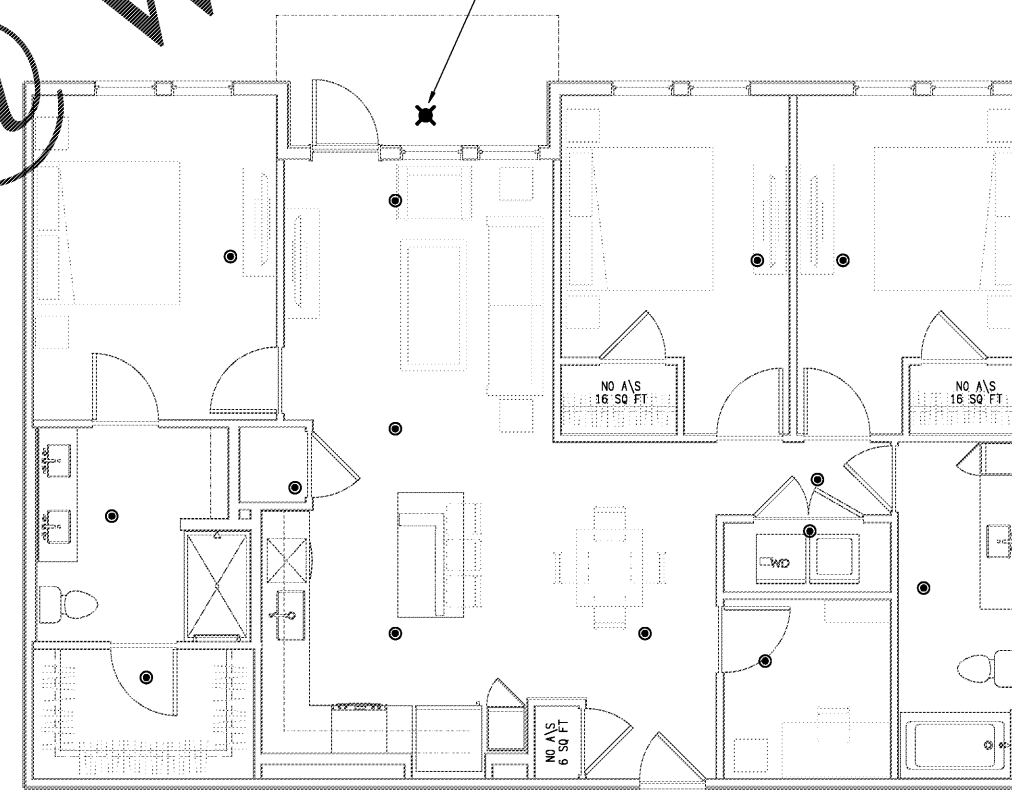

**2 UNIT C1-A - FIRE PROTECTION PLAN**  
SCALE: 1/4"=1'-0"

Order Plans @ WWW.LDLINE.COM

Common North, Prospect, KY



780 FLORIDA CENTRAL PARKWAY  
SUITE 224  
LONGWOOD, FL 32750  
PH: 407.336.7999  
PROJECT #: 18025

Lyric at Norton Commons  
Prospect, Kentucky



architects • planners  
1770 fennell street  
maitland florida 32751-7208  
407.660.8900 • 407.875.9948  
www.cbaarchitects.com

UNIT C1 AND C1-A  
FIRE PROTECTION  
PLANS

date: 06-04-2019  
job no: 3789.15  
drawn by: GNIK  
reviewed by: GNIK  
file: 18025-F-UNIT  
issue history:

F4.07

charlan brock associates, inc. hereby reserves all copyright, trademark, trade name, design, and plan are not to be reproduced, changed or copied in any form or manner whatsoever, nor are they to be assigned to any third party, without first obtaining the express written permission from charlan brock associates, inc. within dimensions and have precedence over scale dimensions.